


**SYMBOL REFERENCE**

10 x 10 Tent	15 x 15 Tent	20 x 20 Tent	40 x 40 Tent
Carnival Game, No Tent	6' Table	8' Table	Catering Truck
Barricade	Fire Truck	Ice Maker	
Propane use, Food Tent	Beverage Tent	Garbage	Generator
Pink Flag	AV	DJ	Back-of-House

**SYMBOL REFERENCE CITY INFRASTRUCTURE**

LIGHT POST	LIGHT POST WITH POWER	110v OUTLET	ELECTRICAL BOX
PARKING PAY STATION	WATER HOOK UP	HYDRANT	FLAG POLE
RECYCLE	TRASH	RESTROOM	RESTROOM
STORM SEWER MANHOLE	BROWARD BICYCLE		

SCALE: 1/32" = 1'-0"

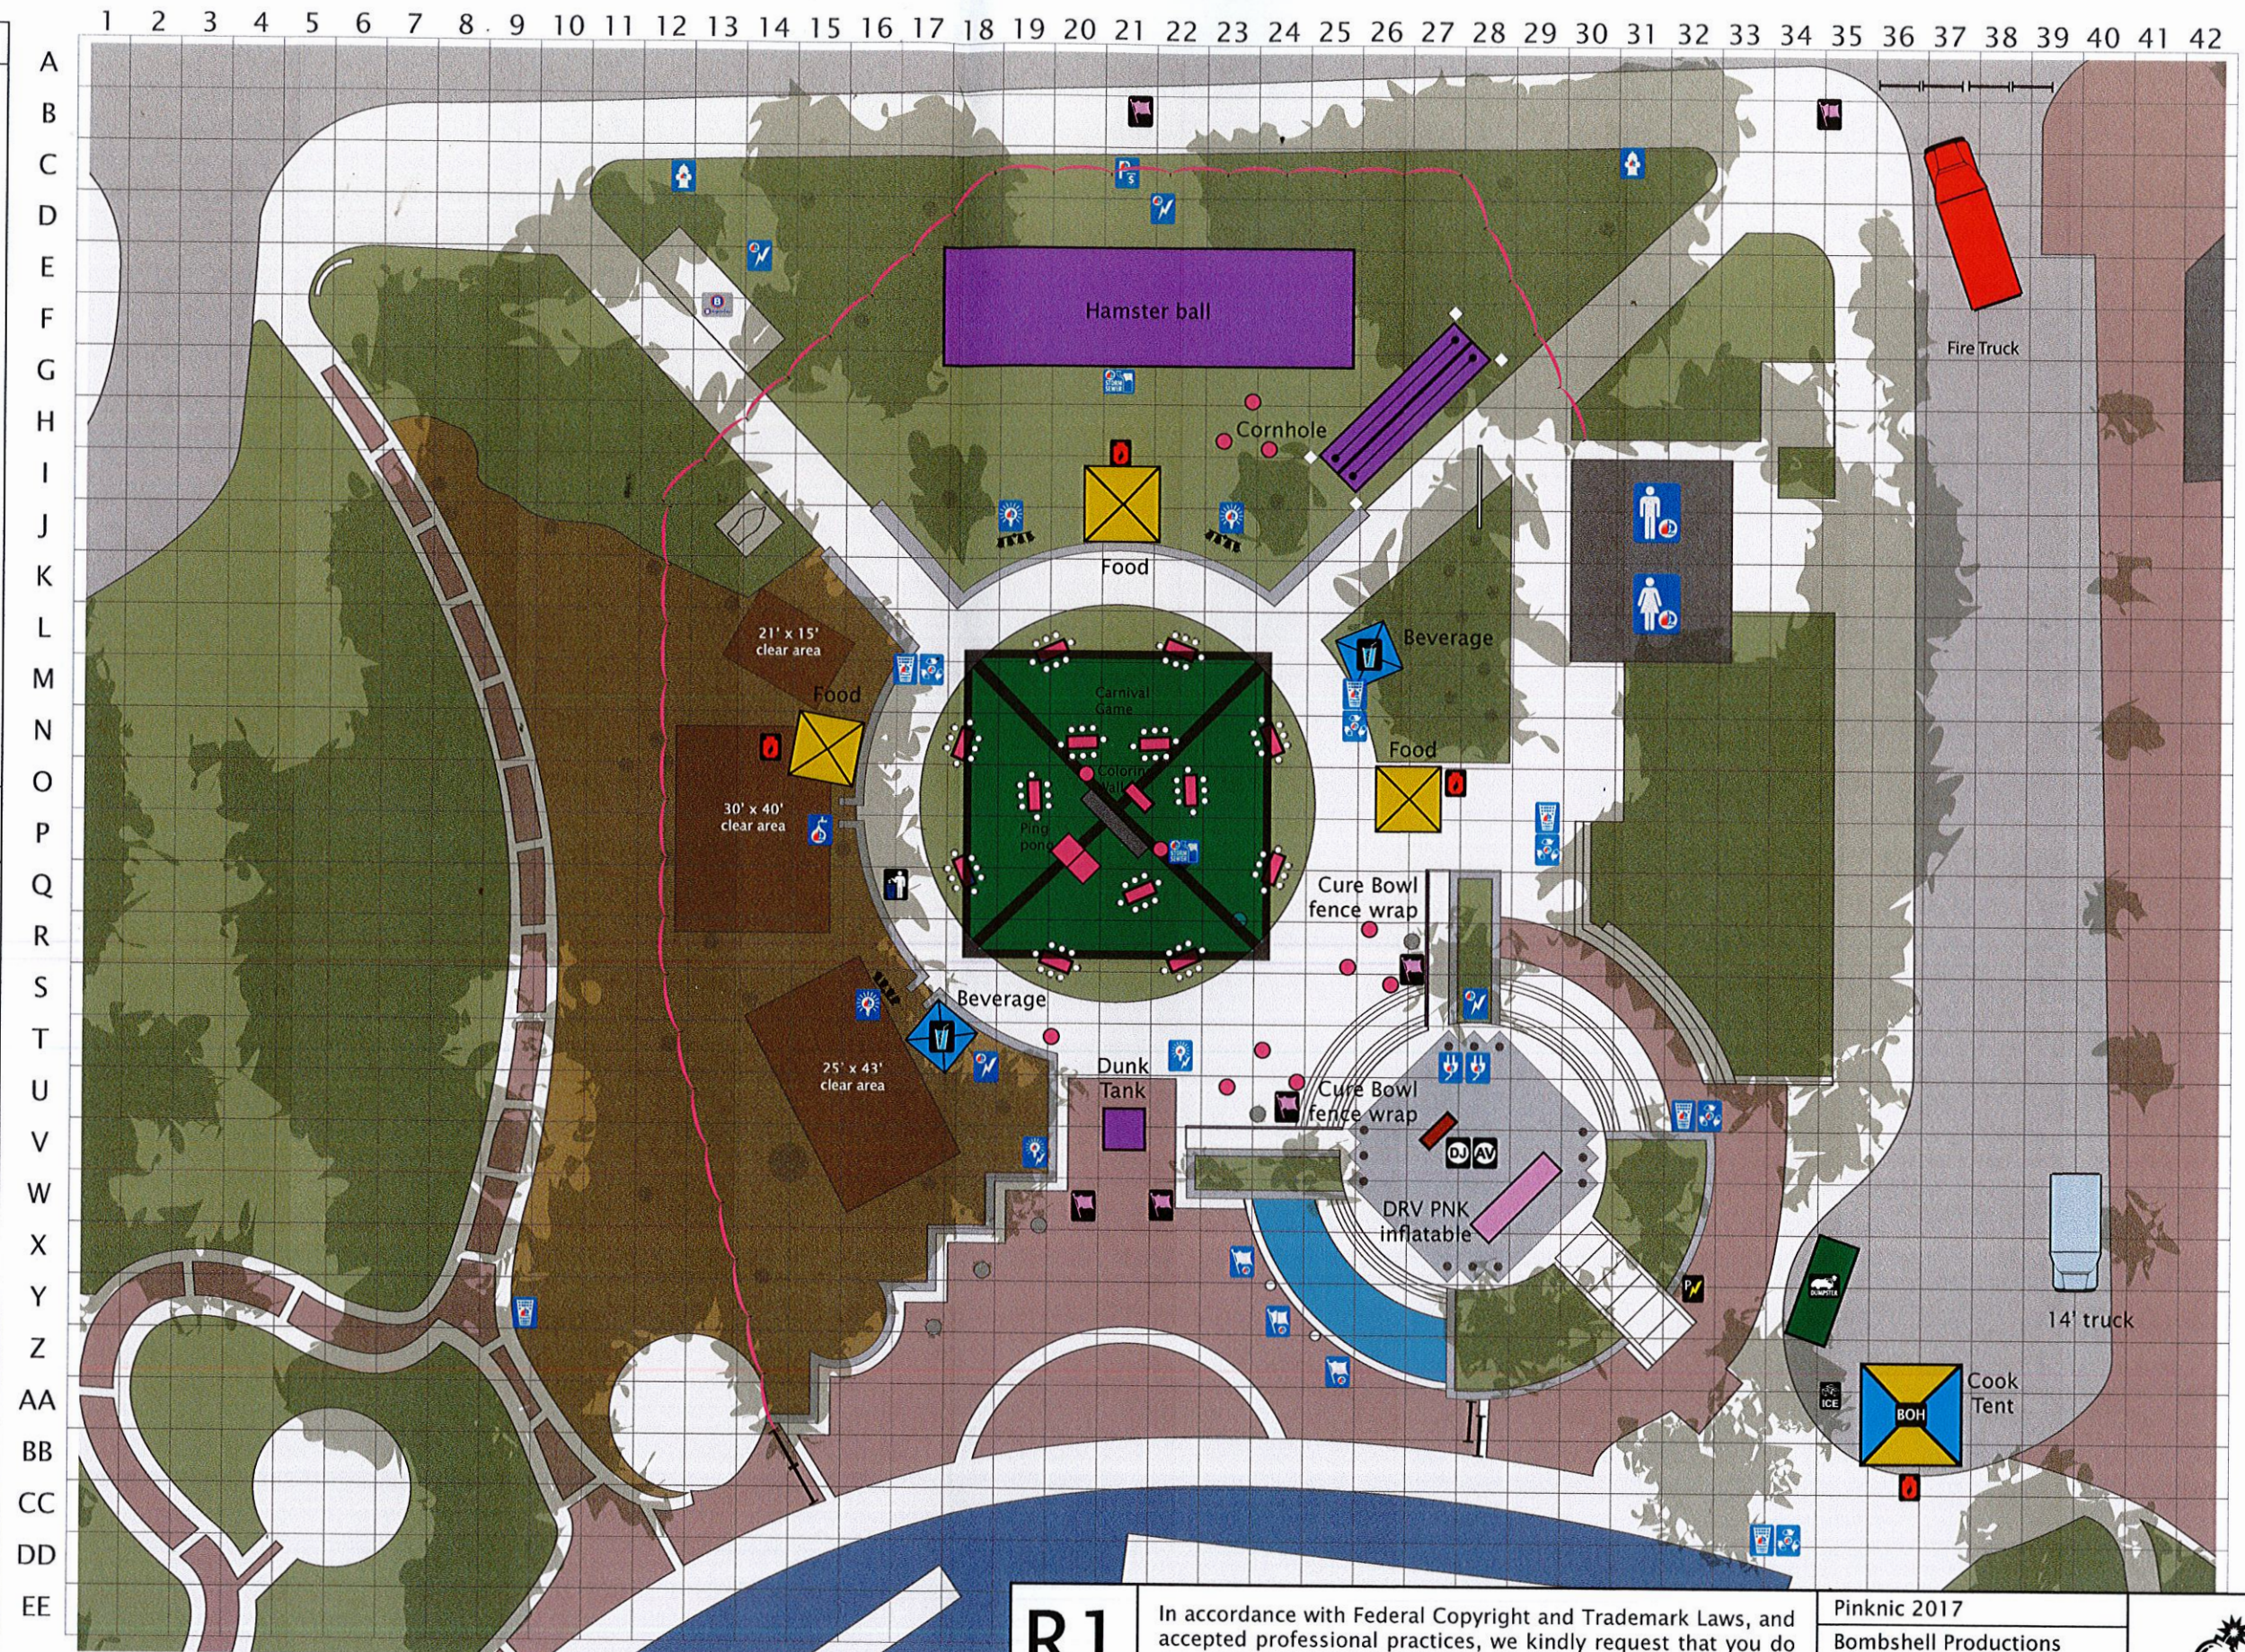

1 ESPLANADE PARK  
SITE PLAN SCALE: 1/32" = 1'-0"

<b>R1</b>	In accordance with Federal Copyright and Trademark Laws, and accepted professional practices, we kindly request that you do not allow any of these materials to be used, copied, or distributed in any matter whatsoever without the express written permission of Bombshell Productions, Inc.	Pinknic 2017
	07/14/17	Bombshell Productions 954.703.6650 www.Bombshellpro.com Drawn By: Boggs

