

NEW HOPE RENTALS

1316 N.W. 6th STREET,
FT. LAUDERDALE, FL 33311

PROJECT INFORMATION

No.	Description	Date



Arvin M. Wyanden, Architect
 Architect - Interior Designer - Planner
 Lic. # AR93138
 2138 Roca Road
 Shreveport, Louisiana 71119
 P: (504) 854-4312
 E: Email: jmw@wyarch.com

DRAWING INDEX		CODE RESEARCH	
A-00 GENERAL NOTES		GOVERNING CODE	2020 Florida Building Code-7th Ed., 2020 Florida Accessibility Code, Florida Fire Prevention Code Seventh Edition.
A-01 SITE PLAN		BUILDING HEIGHT	40'-0" Approximately
A-02 FLOOR PLANS		PROJECT AREA	
A-03 PERSPECTIVES 1		TYPE OF CONSTRUCTION	Type III-B
A-04 PERSPECTIVES 2		MAXIMUM TRAVEL DISTANCE	200
A-05 PERSPECTIVE 3		OCCUPANCY CLASSIFICATION	R
		FOLIO #:	5042 04 06 0570, 5042 04 06 0580 & 5042 04 06 0590
		LEGAL DESCRIPTION	FIRST ADD TO TUSKEGEE PARK S 45 B LOT 1 LESS RD BLK 4
		SCOPE OF WORK	27 NEW APARTMENTS WITH PARKING ON LOWER LEVEL, FITNESS CENTER, TRASH ROOM, ELEVATORS, STAIRWELL, ADMIN OFFICE, POST ROOM, ELECTRIC ROOM & WAITING AREA.
			Fire Alarm System / Fire Sprinkler System

GENERAL NOTES

THE CONTRACTOR SHALL VISIT THE SITE AND FAMILIARIZE HIMSELF WITH THE EXISTING CONDITIONS AND NOTIFY THE ARCHITECT OF ANY DISCREPANCIES IN WRITING PRIOR TO SUBMITTING HIS BID.

THE CONTRACTOR SHALL VISIT THE PROJECT SITE PRIOR TO THE SUBMISSION OF ANY BIDS, AND VERIFY THE ARCHITECT'S DIMENSIONS, DETAILS AND INFORMATION PERTAINING TO THE PROJECT. IF ANY DISCREPANCIES, CONFLICTING INFORMATION, ERRORS OR OMISSIONS ARE PRESENT, THE CONTRACTOR SHALL NOTIFY THE ARCHITECT AND OWNER IMMEDIATELY IN WRITING. ANY DISCREPANCY, OR CONFLICT NOT BROUGHT TO THE ATTENTION OF THE ARCHITECT AND OWNER PRIOR TO THE FINAL BID SUBMISSION SHALL BE CORRECTED BY THE CONTRACTOR AT NO ADDITIONAL COST TO THE OWNER. THE CONTRACTOR SHALL NOT SCALE THE DRAWINGS. WRITTEN DIMENSIONS TAKE PRECEDENCE OVER SCALED DIMENSIONS.

THE GENERAL CONTRACTOR AND ALL SUBCONTRACTORS SHALL CARRY PUBLIC LIABILITY, PROPERTY, AND WORKMEN'S COMPENSATION INSURANCE. VALID CERTIFICATES OF ALL SHALL BE PROVIDED.

THE CONTRACTOR SHALL INCLUDE ALL WORK NECESSARY TO ASSURE THE PROJECTS COMPLIANCE WITH THE MOST STRINGENT REQUIREMENTS OF THE FLORIDA BUILDING CODE, CURRENT LOCAL EDITION, NFPA-101 AND ALL OTHER REGULATION CODES.

THE CONTRACTOR SHALL OBTAIN ALL PERMITS, AND SECURE ALL CERTIFICATES OF INSPECTION AND OCCUPANCY THAT ARE REQUIRED BY THE GOVERNING JURISDICTION. THE OWNER SHALL RECEIVE A COPY OF THE PERMIT UPON ISSUANCE.

THE CONTRACTOR SHALL REFERENCE THE BUILDING SHELL DRAWINGS FOR ALL INFORMATION RELATIVE TO THE BUILDING SHELL AND FOR COORDINATION OF NEW WORK.

THE GENERAL CONTRACTOR AND ALL SUBCONTRACTORS/VENDORS SHALL FAMILIARIZE THEMSELVES WITH AND CONFORM TO ALL REQUIREMENTS SET FORTH BY THE BUILDING OWNER OR MUNICIPALITY RELATIVE TO THE HOURS OF WORK.

THE CONTRACTOR SHALL SUBMIT A DETAILED CONSTRUCTION SCHEDULE COORDINATION ALL SUBCONTRACTORS, SUPPLIERS AND VENDORS.

THE CONTRACTOR SHALL NOT ALLOW ON THE PROJECT ANY MATERIALS CONTAINING ASBESTOS, PETROLEUM OR PCB.

THE CONTRACTOR SHALL BE RESPONSIBLE FOR OBTAINING AND DISTRIBUTING ALL CURRENT DRAWINGS TO THE SUBCONTRACTORS/VENDORS AS WELL AS SUPERVISING AND COORDINATING THE WORK OF ALL TRADES IN ACCORDANCE WITH THE SPECIFICATIONS AND MAKING ADJUSTMENTS IN LAYOUT AS REQUIRED. THE ARCHITECT SHALL BE NOTIFIED PRIOR TO THE EXECUTION OF THEIR REVISIONS TO AVOID CONFLICT BETWEEN TRADES FOR PROPER EXECUTION OF THE WORK.

THE CONTRACTOR SHALL INSTALL ANY APPARATUS, APPLIANCE, MATERIAL OR WORK NOT SHOWN ON THE DRAWINGS BUT MENTIONED IN THE SPECIFICATIONS, OR VICE VERSA, OR ANY INCIDENTAL ACCESSORIES NECESSARY FOR COMPLETION OF THE WORK FOR OPERATION WITHOUT ADDITIONAL EXPENSE TO OWNER.

THE CONTRACTOR SHALL COORDINATE ALL OWNER/TENANT SUPPLIED ITEMS AND INCORPORATE THE INSTALLATION INTO THE CONSTRUCTION SCHEDULE.

THE CONTRACTOR SHALL PROVIDE ANY TEMPORARY UTILITIES INCLUDING, ELECTRIC, WATER, AND TELEPHONE REQUIRED FOR THE COMPLETION OF THE PROJECT.

THE CONTRACTOR SHALL HAVE A DIGITAL CAMERA ON SITE TO DOCUMENT ANY ISSUES THAT MAY NEED TO BE CLARIFIED. THESE PICTURES SHALL BE EMAILED TO THE ARCHITECT ALONG WITH AN RFI FOR CLARIFICATION.

THE CONTRACTOR SHALL PROVIDE AT ALL TIMES PROTECTION FROM THE WEATHER AND EXCESSIVE DUST THAT MAY IN ANY WAY DAMAGE THE WORK, MATERIAL, FIXTURES, AND EQUIPMENT, OR PRESENT DANGER TO PERSONNEL. ANY WORK UNDER CONTRACT BY THE GENERAL CONTRACTOR DAMAGED BY A FAILURE TO PROVIDE ADEQUATE PROTECTION SHALL BE REMOVED AND REPLACED WITH NEW WORK AT THE SOLE EXPENSE OF THE CONTRACTOR.

THE CONTRACTOR SHALL MAINTAIN THE JOB SITE FREE FROM RUBBISH AND DEBRIS. DISPOSAL OF CONSTRUCTION DEBRIS SHALL CONFORM TO BUILDING REGULATIONS.

THE CONTRACTOR SHALL RUN FIRE RATED WALLS AND PARTITIONS TO UNDERSIDE OF RATED ROOF/CEILING ASSEMBLY ABOVE. TAPE AND SEAL JOINTS. PROVIDE FIRE DAMPERS AT DUCT PENETRATIONS AS REQUIRED BY CODE. TAPE AND SEAL OTHER PENETRATIONS TO MAINTAIN INTEGRITY OF FIRE-RATED PARTITION USING ONLY UL APPROVED MATERIAL.

THE CONTRACTOR SHALL FINISH GYPSUM WALLBOARD ABUTTING OTHER MATERIAL WITH METAL EDGE STRIPS. CONCEAL PIPING, DUCTWORK, AND CONDUIT.

THE CONTRACTOR SHALL BACK ALL ELECTRICAL CABINETS, FIRE EXTINGUISHERS, CABINETS AND OTHER RECESSED EQUIPMENT LOCATED IN FIRE-RATED WALLS WITH 5/8" TYPE 'X' GYPSUM BOARD AS REQUIRED TO MAINTAIN THE RATING.

THE CONTRACTOR SHALL PROVIDE BRACING OR BLOCKING AS REQUIRED TO SUPPORT WALL MOUNTED EQUIPMENT, CABINETS, GRILLERS, DOORS, WINDOWS, ETC. WOOD BLOCKING SHALL BE FIRE RETARDANT TREATED. METAL STUDS MAY BE USED IN LIEU OF WOOD BLOCKING.

THE CONTRACTOR SHALL NOT CUT ANY STEEL, WOOD, OR OTHER MAIN STRUCTURAL MEMBERS WITHOUT WRITTEN APPROVAL OF THE STRUCTURAL ENGINEER.

ANY ROOM, WALL, FLOOR, OR CEILING FINISH NOT SCHEDULED SHALL BE ASSUMED TO BE IDENTICAL TO THE CLOSEST ROOM OF SIMILAR USE AND TYPE FOR PURPOSES OF BIDDING AND CONSTRUCTION. NOTIFY THE ARCHITECT OF ANY OBSERVED APPARENT DISCREPANCIES IN WRITING PRIOR TO COMMENCING WITH THE WORK.

ANY DETAIL NOT SPECIFICALLY REFERENCED SHALL BE ASSUMED TO BE SIMILAR TO THAT SHOWN IN THE CLOSEST POSITION WHERE A SIMILAR CONDITION OCCURS FOR THE PURPOSES OF BIDDING AND CONSTRUCTION. NOTIFY THE ARCHITECT IN WRITING OF ANY OBSERVED APPARENT DISCREPANCIES PRIOR TO COMMENCING WITH THE WORK.

WHERE TWO OR MORE DETAILS, MATERIALS, OR CONDITIONS OCCUR IN APPARENT CONFLICT, THE CONTRACTOR SHALL INCLUDE THE MOST COSTLY SOLUTION IN HIS BID AND NOTIFY THE ARCHITECT OF ANY APPARENT DISCREPANCIES PRIOR TO START OF CONSTRUCTION.

THE CONTRACTOR SHALL PROVIDE UPON COMPLETION OF THE WORK A SET OF "AS-BUILT" NEATLY MARKED UP PLANS, THE ELECTRICAL CONTRACTORS "AS-BUILT" DRAWINGS SHALL BE INCLUDED. THESE DRAWINGS SHALL BE TRANSMITTED TO THE OWNER.

BUILDER, SUBCONTRACTOR, SUPPLIER, ETC. SHALL VERIFY ALL DIMENSIONS, PLANS, SPECIFICATIONS, CONDITIONS AT JOBSITE, ETC. PRIOR TO STARTING ANY WORK AND WITHIN (7) SEVEN CALENDAR DAYS OF BUILDER'S RECEIPT OF THESE PLANS SHALL NOTIFY THE DESIGNER (IN WRITING ONLY) OF ANY AND ALL DISCREPANCIES (WHETHER DISCREPANCIES ARE ERRORS OF COMMISSION OR OMISSION OR NOT). OTHERWISE THE DESIGNER WILL ASSUME NO RESPONSIBILITY FOR ANY ERRORS AND CORRECT ERRORS AT THEIR OWN EXPENSE. NOTE: ALL DIMENSIONS ARE NOMINAL, TO FACE OF STUD, STEM WALL, OR MONOLITHIC FOOTINGS UNLESS OTHERWISE NOTED. THE DESIGNER DOES NOT HAVE FIELD SUPERVISION NOR CONSTRUCTION ADMINISTRATION ON THIS PROJECT. ALL CONTRACTORS AND SUBCONTRACTORS SHALL HOLD HARMLESS THE DESIGNER FOR ANY PERSONAL INJURY OR DAMAGE TO THE PROJECT OR TO ADJACENT PROPERTIES AND OMISSIONS.

NATURE OF SOIL: ASSUMED BEARING VALUES FOR UNDISTURBED SAND, OR SAND AND ROCK SOIL SHALL BE 2500 P.S.F. THE ASSUMED SOIL CONDITIONS (W/ 2500 P.S.F.) IS CAPABLE OF SUSTAINING THE CONSTRUCTION OF A ONE OR TWO STORY RESIDENCE. SITE WORK: FILL UNDER ALL SLABS SHALL BE CLEAN SAND AND SHALL BE COMPACTED TO MINIMUM OF 95% DENSITY AS PER ASTM D-1557. CONTRACTOR SHALL VERIFY AFTER COMPACTION.

CONCRETE: ALL CONCRETE TO HAVE A COMPRESSIVE STRENGTH OF 2500 P.S.I. AT 28 DAYS UNLESS NOTED OTHERWISE. CONCRETE PER ASTM C95. CONCRETE WORK PER ACI 301.

ANY CHANGES, REVISIONS, ALTERATIONS, ETC. REQUIRED TO THESE PLANS, DRAWINGS, SPECIFICATIONS, ETC. SHALL BE REQUESTED IN WRITING ONLY BY THE BUILDER OR THE OWNER TO THE DESIGNER. ANY CHANGES, REVISIONS, ALTERATIONS, DEVIATIONS, ETC. NOT MADE BY THE DESIGNER WILL FULLY UNCONDITIONALLY AND TOTALLY RELEASE THE DESIGNER FROM ANY AND ALL RESPONSIBILITY, CLAIMS, OR LIABILITIES AGAINST THE DESIGNER FOR CULPABILITY, ETC. FROM DATE SHOWN ON PLANS ORIGIN UNTIL THE END OF TIME.

REBAR: ALL REINFORCEMENT STEEL TO BE ASTM A-615 GRADE 60, BENT, LAPPED AND PLACED IN ACCORD WITH THESE DRAWINGS AND THE LATEST SPECIFICATIONS IN ACI 318.

CONTRACTOR IS RESPONSIBLE FOR ALL STRUCTURAL COORDINATION AND SHALL NOTIFY DESIGNER OF ANY DISCREPANCIES PRIOR TO POURING OF FLOOR SLABS, FOOTINGS, OR PADS.

THESE PLANS AS DRAWN AND NOTED COMPLY WITH THE BUILDING ENVELOPE ENERGY REQUIREMENTS OF THE FLORIDA MODEL ENERGY CODE. CONTRACTOR SHALL FAMILIARIZE HIMSELF WITH THE GOVERNING CODE IN ITS ENTIRETY AND BUILD IN ACCORDANCE WITH ALL PROVISIONS OF THIS CODE WHICH MAY BE SPECIFICALLY ADDRESSED ON THE PLANS AND NOTES.

LUMBER USED FOR JOISTS, RAFTERS, TRUSSES, COLUMNS, BEAMS AND / OR STRUCTURAL MEMBERS SHALL BE STRESS GRADE NOT LESS THAN 16 # 1000 PSI UNLESS OTHERWISE SPECIFIED. REFER TO STRUCTURAL DRAWINGS.

ALL LUMBER IN CONTACT WITH MASONRY OR CONCRETE TO BE PRESSURE TREATED.

APPLY AND/OR INSTALL ALL PRODUCTS AND MATERIALS ACCORDING TO MANUFACTURERS PUBLISHED INSTRUCTIONS OR, IF NO INSTRUCTIONS EXIST, INSTALL PER STANDARD INDUSTRY PRACTICES.

SMOKE DETECTORS TO BE POWERED BY HOUSE ELECTRIC SERVICE AND HAVE BATTERY BACK-UP. MULTIPLE DETECTORS MUST BE INTERCONNECTED AS PER F.B.C. SECTION 905.2.5.

MIRRORS OVER 9 S.F. SHALL BE ANCHORED TO STUDS.

ALL VERTICAL ELEVATION DATUM FOLLOWED BY "AFF" (ABOVE FINISHED FLOOR) IS REFERENCED FROM THE 0'-0" FINISHED FLOOR. IF NOT FOLLOWED BY "AFF" THE VERTICAL ELEVATION DATUM IS REFERENCED FROM THAT ROOM'S FLOOR ELEVATION.

TRUSS MANUFACTURER SHALL SUBMIT THREE (3) COPIES OF SHOP DRAWINGS AND ENGINEERING CALCULATIONS, SIGNED AND SEALED BY A FLORIDA REGISTERED ENGINEER OF THEIR ROOF TRUSS DESIGN FOR APPROVAL INCLUDING ONE (1) COPY FOR ARCHITECT'S REVIEW PRIOR TO FABRICATION. TRUSSES TO BE DESIGNED TO CARRY LOADS OF MISCELLANEOUS EQUIPMENT. COORDINATE LOCATIONS WITH CONTRACTOR PRIOR TO FABRICATION AND INDICATE ON TRUSS DRAWINGS. IF THERE IS A DISCREPANCY ON THE DOCUMENTS THE TRUSS MANUFACTURER SHALL NOTIFY THE DESIGNER AND CLOUD THE AREA IN QUESTION ON THE TRUSS MANUFACTURER'S SHOP DRAWINGS. IF ANY DEVIATIONS ARE MADE BY THE TRUSS MANUFACTURER WITHOUT NOTIFICATION TO THE DESIGNER, TRUSS MANUFACTURER SHALL BE RESPONSIBLE FOR ANY CORRECTIONS DEEMED NECESSARY AND ABSORB ALL COSTS INCURRED. ALL CONNECTOR STRAPS SHALL BE OF GALVANIZED STEEL, ASTM A446-75 GRADE A (W/ 33,000 psi). ALL STEEL SEAT DETAILS SUPPORTING GIRDER TRUSSES SHALL BE COORDINATED WITH THE TRUSS MANUFACTURER FOR SIZE AND BOLT SPACING REQUIREMENTS. (SEE PLAN) TRUSS BRACINGS SHALL CONFORM TO F.B.C SECTION 2318.17.2 FOR CLGS DIRECTLY ATTACHED TO UNDERSIDE OF TRUSSES, AND SECT. 2318.17.1.3 FOR CLGS DIRECTLY ATTACHED TO 1"x3" FURRING STRIPS. TEMPORARY & PERMANENT BRACING TO BE IN ACCORDANCE WITH T.P.I. PROCEDURES.

SYMBOLS

	IDENTIFICATION NUMBER	DETAIL SYMBOL		ELEVATION
	SHEET NUMBER	SECTION SYMBOL		KEY NOTE
	IDENTIFICATION NUMBER	SECTION SYMBOL		DOOR SYMBOL
	SHEET NUMBER	SECTION SYMBOL		WINDOW SYMBOL
	IDENTIFICATION NUMBER	SECTION SYMBOL		WALL TYPE
	SHEET NUMBER	SECTION SYMBOL		EXISTING WALL
	ELEVATION NUMBER	INTERIOR ELEVATIONS		NEW WALL
	ENLARGED PLAN CALL OUT	ENLARGED PLAN CALL OUT		EXISTING WALLS TO BE REMOVED
				BATT INSULATION
				FIRE RATED WALL

LOCATION MAP



NEW HOPE RENTALS
 1316 N.W. 6th STREET,
 FT. LAUDERDALE, FL 33311

PROJECT NO.	
DRAWN BY	JMW
CHECKED BY	JMW
DATE	02/16/2022
FILE NAME	

GENERAL NOTES & SITE PLAN

SHEET NO.	A-00
SHEET	OF



No.	Description	Date



Jarvis M. Wyanden, Architect
 Architect - Interior Designer - Planner
 Lic. # AR94338
 4748 Pace Road
 Shreveport, Louisiana 71119
 P: (504) 854-4312
 Email: jmwanden@gmail.com

NEW HOPE RENTALS
 1316 N.W. 6th STREET,
 FT. LAUDERDALE, FL 33311

SEAL

PROJECT NO:
 DRAWN BY: JMW
 CHECKED BY: JMW
 DATE: 02/16/2022
 FILE NAME:

PERSPECTIVE 3

SHEET NO:
A-05

SHEET ____ OF ____



No.	Description	Date



Jarvis M. Wyanden, Architect
 Architect - Interior Designer - Planner
 Lic. # AB94338
 4708 Pine Road
 Shreveport, Louisiana 71119
 P: (504) 854-4312
 Email: jmwanden@gmail.com

NEW HOPE RENTALS
 1316 N.W. 6th STREET,
 FT. LAUDERDALE, FL 33311

SEAL

PROJECT NO.

DRAWN BY: JMW
 CHECKED BY: JMW
 DATE: 02/16/2022

FILE NAME

PERSPECTIVE

SHEET NO.

A-03

SHEET ____ OF ____



No.	Description	Date



Jervis M. Wyarden, Architect
 Architect - Interior Designer - Planner
 Lic. # AB-84338
 2748 Rose Road
 Shreveport, Louisiana 71119
 P: (504) 854-4312
 Email: jerrywyarden@gmail.com

NEW HOPE RENTALS
 1316 N.W. 6th STREET
 FT. LAUDERDALE, FL 33311


SEAL

PROJECT NO:
 DRAWN BY: JMW
 CHECKED BY: JMW
 DATE: 02/16/2022

FILE NAME:
PERSPECTIVE 2

SHEET NO:
A-04

SHEET ___ OF ___

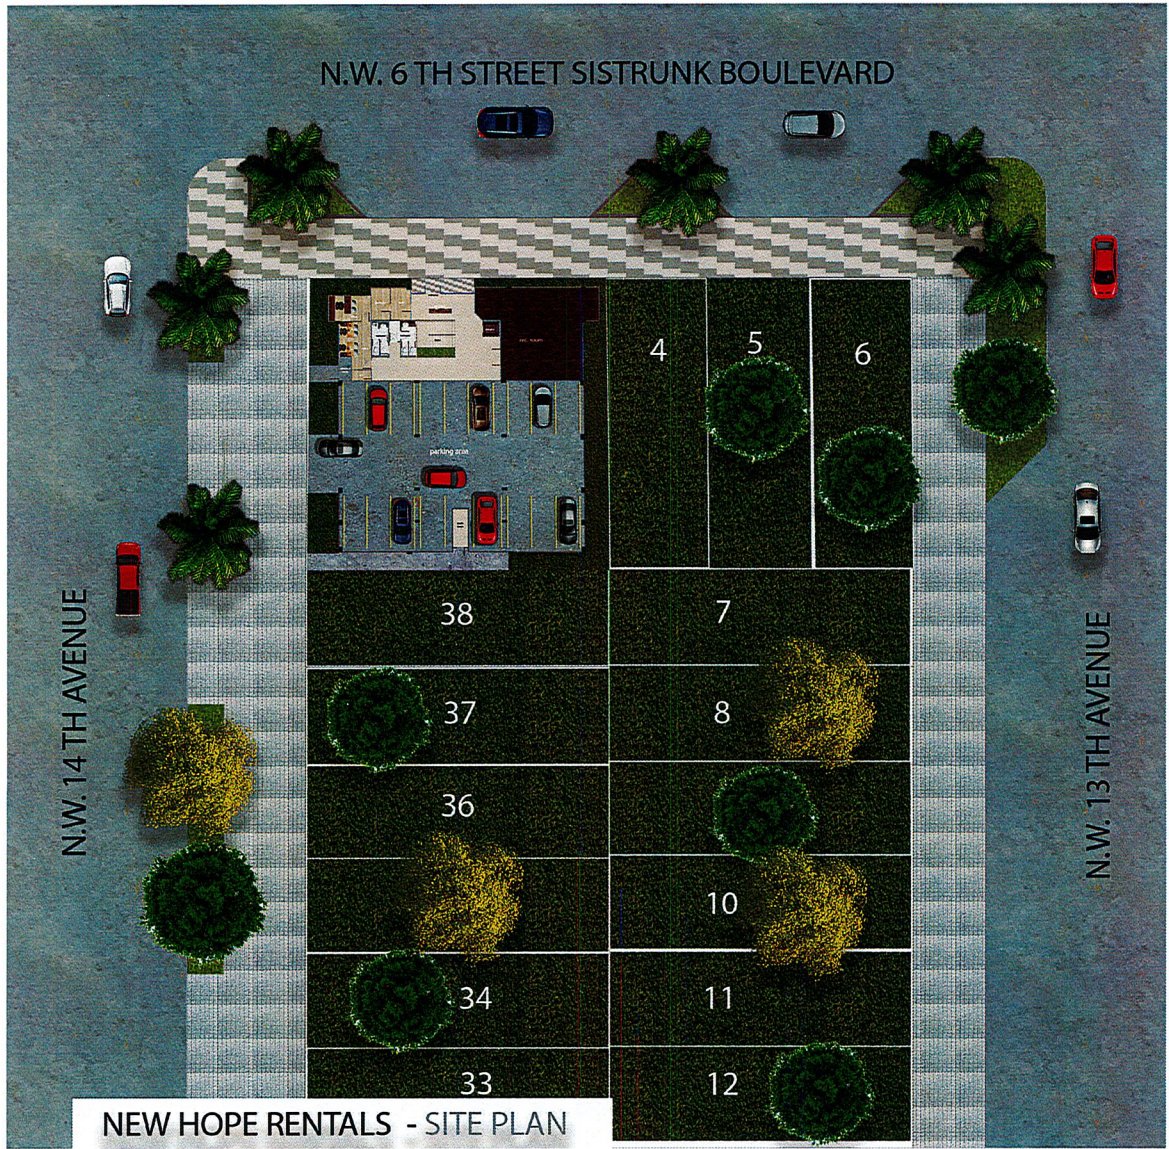

NEW HOPE RENTALS - SITE PLAN

① SITE PLAN
3/8" = 1'-0"

No.	Description	Date



Jarvis M. Wysocki, Architect
 Architect - Interior Designer - Planner
 Lic. # AR94338
 4748 Pace Road
 Shreveport, Louisiana 71119
 P: (504) 854-4312
 Email: jmw@jmwdesign.com

NEW HOPE RENTALS
 1310 N.W. 6th STREET,
 FT. LAUDERDALE, FL 33311

SEAL

PROJECT NO.
 DRAWN BY: JMW
 CHECKED BY: JMW
 DATE: 02/16/2022

SITE PLAN

SHEET NO.
A-01

SHEET ___ OF ___



FIRST FLOOR PLAN
NEW HOPE

1 FLOOR PLANS
1/2" = 1'-0"



SECOND - FOURTH FLOOR PLAN
NEW HOPE

No.	Description	Date



Jarvis M. Wysocki, Architect
Architect - Interior Designer - Planner
Lic. # 48194336
4748 Kase Road
Shreveport, Louisiana 71119
P. (504) 834-0112
Email: jmwysocw@gmail.com

NEW HOPE RENTALS
1316 N.W. 6th STREET,
FT. LAUDERDALE, FL 33311

SEAL

PROJECT NO.
DRAWN BY: JMW
CHECKED BY: JMW
DATE: 02/16/2022

FILE NAME
FLOOR PLANS

SHEET NO.
A-02

SHEET ___ OF ___



SECOND - FOURTH FLOOR PLAN
NEW HOPE