 


EVENT SITE PLAN  
SCALE: 1" = 60'-0"



## SPECIAL EVENT

EVENT NAME:  
WI CARIBBEAN

MAIN EVENT DATES:  
JUNE 11TH, 2016, 9AM TO 10PM

EVENT CAPACITY:  
APPROXIMATELY 10,000 PEOPLE

### KEY NOTES

1. ALL RESTROOMS ARE ADA COMPLAINT. THESE CONSTRUCTION DOCUMENTS ARE COMPLIANT WITH ADA ACCESSIBILITY GUIDELINES (ADAAG) AND UNIFORM FEDERAL ACCESSIBILITY STANDARDS (UFAS), WHERE APPLICABLE. ALL EVENT INCLUDING PATHWAYS TO RESTROOMS, EXHIBITS, FOOD, AND MERCHANDISE VENDORS ARE ON PAVED CONCRETE/ASPHALT\*\*
2. ALL FUEL TANK OPENINGS SHALL BE LOCKED AND SEALED IN AN APPROVED MANNER TO PREVENT THE ESCAPE OF VAPORS; FUEL TANKS SHALL NOT CONTAIN IN EXCESS OF 1/2 THEIR CAPACITY OR CONTENT IN EXCESS OF TEN GALLONS OF FUEL, WHICHEVER IS LESS.
3. AT LEAST ONE OF THE BATTERY CABLE SHALL BE REMOVED FROM THE BATTERY USED TO START THE VEHICLE ENGINE AND THE DISCONNECTED CABLE SHALL BE TAPED.
4. BATTERIES USED TO POWER AUXILIARY EQUIPMENT SHALL BE PERMITTED TO BE KEPT IN SERVICE.
5. FUELING AND DEFUELING OF VEHICLES SHALL NOT BE PERMITTED.
6. VEHICLES SHALL NOT BE MOVED DURING EVENT HOURS.

\*\*ALL EXISTING BUILDINGS ONSITE ARE FULLY SPRINKLERED BUILDING WITH FIRE ALARM\*\*

### NOTES

1. ONE CROWD MANAGER (BANQUET CAPTAIN AND CONVENTION MANAGERS WITH CHECK LIST AND ACTION PLAN IN CASE OF EMERGENCY) FOR EVERY 250 OCCUPANTS.
2. SECURITY WILL MAINTAIN TWO WAY RADIO COMMUNICATION WITH COMMAND CENTER ROOM AND PRODUCTION MANAGER TO SHUT DOWN POWER AND SOUND AT EVENT SITE IN CASE OF EMERGENCY. COPY OF SECURITY PLANS ATTACHED.
3. AVOID ALL TRIPPING HAZARDS FROM LOOSE RUN TRANSMISSION CABLES AND POWER CORD WIRES.
4. COMPLY WITH NFPA 1405 MOTION PICTURE AND TELEVISION PRODUCTION STUDIO SOUND STAGES, APPROVED PRODUCTION FACILITIES, AND PRODUCTION LOCATIONS, AND NFPA 101.
5. COMPLY WITH NEC 2008.
6. ANY CROWD CONTROL DEVICES UTILIZED WILL BE TEMPORARY AND EASILY REMOVABLE IN THE EVENT OF EMERGENCY.
7. THE CROWD MANAGER WILL MAINTAIN THE OCCUPANT LOAD AT OR BELOW THE MAXIMUM ALLOWED.

### FIRE DEPARTMENT


1. OFF DUTY FIRE AND PARAMEDIC SERVICES: MINIMUM OF 2 PARAMEDICS FOR UP TO 5,000 PEOPLE AND A RESCUE UNIT FOR UP TO 10,000 PEOPLE WHICH CONSISTS OF TWO PARAMEDICS AND A TEAM LEADER REQUIRED.
2. ONE FIRE WATCH HIRED THROUGH THE SPECIAL EVENTS BUREAU (186-331-4438) WILL BE REQUIRED FOR THIS EVENT IN ACCORDANCE WITH NFPA 101 (2009).
3. ILLUMINATION OF MEANS OF EGRESS TO COMPLY WITH NFPA 101 SECTION 18.

### TENTS WITH COOKING OPERATION NOTES


- COOKING OPERATIONS THAT OCCUR UNDER A TENT CANOPY SHALL BE PERMITTED WITHOUT THE NEED TO PROVIDE THE REQUIRED EXHAUST AND FIRE SUPPRESSION AS REQUIRED BY NFPA 96 UNDER THE FOLLOWING CONDITIONS:
1. NO PORTION OF THE TENT/CANOPY MAY BE ACCESSIBLE TO THE GENERAL PUBLIC.
  2. THE TENT/CANOPY SHALL BE OUTFITTED WITH NO MORE THAN ONE SIDEWALL.
  3. EGRESS FROM THE TENT/CANOPY SHALL BE UNOBSTRUCTED AND IMMEDIATELY AVAILABLE ON AT LEAST (2) SIDES OF THE STRUCTURE.
  4. TRAVEL DISTANCE TO REACH OUTSIDE OF THE TENT/CANOPY SHALL NOT EXCEED 30'-0".
  5. AT THE TIME OF INSPECTION AND DURING COOKING OPERATIONS THERE SHALL BE AT LEAST (1) CLASS K FIRE EXTINGUISHER AND AT LEAST (1) CLASS ABC EXTINGUISHER (ADDITIONAL EXTINGUISHERS MAY BE REQUIRED DEPENDING ON APPLIANCES UTILIZED).
  6. THERE SHALL HAVE AT LEAST 10'-0" OF SEPARATION FROM OTHER STRUCTURES INCLUDING OTHER TENTS/CANOPIES.
  7. TENTS, EACH NOT EXCEEDING 1000 FT<sup>2</sup> IN GROUND AREA OR SIMILAR OPEN SPACES, SHALL NOT BE REQUIRED TO BE SEPARATED FROM EACH OTHER, PROVIDED THAT SAFETY PRECAUTIONS MEET THE APPROVAL OF THE AHA (NFPA 1011.3.4).
  8. ONLY ELECTRIC AND GAS REELED APPLIANCES SHALL BE PERMITTED. SOLID FUEL APPLIANCES OR DEVICES UTILIZING BRICKS/TILES, CHARCOAL, OR CHARCOAL SHALL NOT BE PERMITTED UNDER A TENT OR CANOPY UNDER ANY CIRCUMSTANCE.
  9. FUEL SUPPLIES AND THEIR RELATED HOUSING AND/OR ELECTRIC CORDS SHALL BE INSTALLED AND MAINTAINED IN ACCORDANCE WITH THEIR APPLICABLE NFPA STANDARDS.

### PLAN SYMBOL LEGEND

- DESIGNATED TENT/SHOW MOBILE/STAGE AREAS
- DENOTES EXISTING BUILDINGS
- DENOTES PAVED CONCRETE/ASPHALT AREAS
- DENOTES GRASS AREAS
- DENOTES EXISTING RESTROOM BUILDINGS
- DENOTES EYE IN THE SKY (SECURITY TOWER)
- DENOTES PARKING AREA
- DENOTES PORTA POTTIES AREA WOMENS, MEN, AND HANDICAP. (ALL PORTA POTTIES TO BE LOCATED ON SIDEWALK.
- DENOTES BARRICADE/FENCING

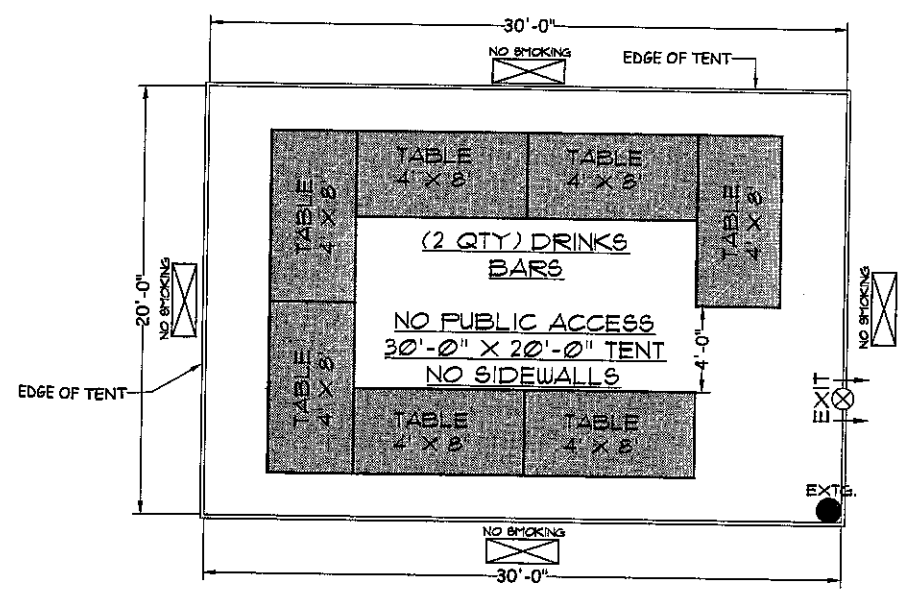

30'-0" X 20'-0" TENT FLOOR PLAN  
SCALE: 1/4" = 1'-0"

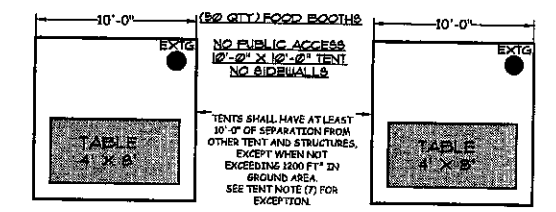

- TENT NOTES
1. NO PORTION OF THE TENT/CANOPY MAY BE ACCESSIBLE TO THE GENERAL PUBLIC.
  2. THE TENT/CANOPY SHALL BE OUTFITTED WITH NO MORE THAN ONE SIDEWALL.
  3. EGRESS FROM THE TENT/CANOPY SHALL BE UNOBSTRUCTED AND IMMEDIATELY AVAILABLE ON AT LEAST (2) SIDES OF THE STRUCTURE.
  4. TRAVEL DISTANCE TO REACH OUTSIDE OF THE TENT/CANOPY SHALL NOT EXCEED 30'-0".
  5. AT THE TIME OF INSPECTION AND DURING COOKING OPERATIONS THERE SHALL BE AT LEAST (1) CLASS K FIRE EXTINGUISHER AND AT LEAST (1) CLASS ABC EXTINGUISHER (ADDITIONAL EXTINGUISHERS MAY BE REQUIRED DEPENDING ON APPLIANCES UTILIZED).
  6. THERE SHALL HAVE AT LEAST 10'-0" OF SEPARATION FROM OTHER STRUCTURES INCLUDING OTHER TENTS/CANOPIES.
  7. TENTS, EACH NOT EXCEEDING 1000 FT<sup>2</sup> IN GROUND AREA OR SIMILAR OPEN SPACES, SHALL NOT BE REQUIRED TO BE SEPARATED FROM EACH OTHER, PROVIDED THAT SAFETY PRECAUTIONS MEET THE APPROVAL OF THE AHA (NFPA 1011.3.4).
  8. ONLY ELECTRIC AND GAS REELED APPLIANCES SHALL BE PERMITTED. SOLID FUEL APPLIANCES OR DEVICES UTILIZING BRICKS/TILES, CHARCOAL, OR CHARCOAL SHALL NOT BE PERMITTED UNDER A TENT OR CANOPY UNDER ANY CIRCUMSTANCE.
  9. FUEL SUPPLIES AND THEIR RELATED HOUSING AND/OR ELECTRIC CORDS SHALL BE INSTALLED AND MAINTAINED IN ACCORDANCE WITH THEIR APPLICABLE NFPA STANDARDS.

### SYMBOL LEGEND

- NO SMOKING SIGN
- EXIT SIGN
- FIRE EXTINGUISHER
- TABLE (4' X 8')



DATE	BY	REV	REVISIONS
2-29-16	BAR	A	SUBMIT FOR PERMIT

PROJECT LOCATION  
**WAYNE HUIZENGA PARK**  
WI CARIBBEAN  
32 E. LAS OLAS BLVD.  
FORT LAUDERDALE, FLORIDA 33301

OWNER INFORMATION  
**DOWNTOWN DEVELOPMENT AUTHORITY**  
32 E. LAS OLAS BLVD.  
FORT LAUDERDALE, FLORIDA 33301

DRAWING TITLE  
EVENT PLAN

DRAWN  
A. RAGOONAN  
DATE  
2-29-2016  
SCALE  
1" = 60'-0"  
FILE NUMBER

SHEET  
16-0368  
OF 1 Exhibit 2a  
Page 1 of 1