


TOPOGRAPHIC SURVEY

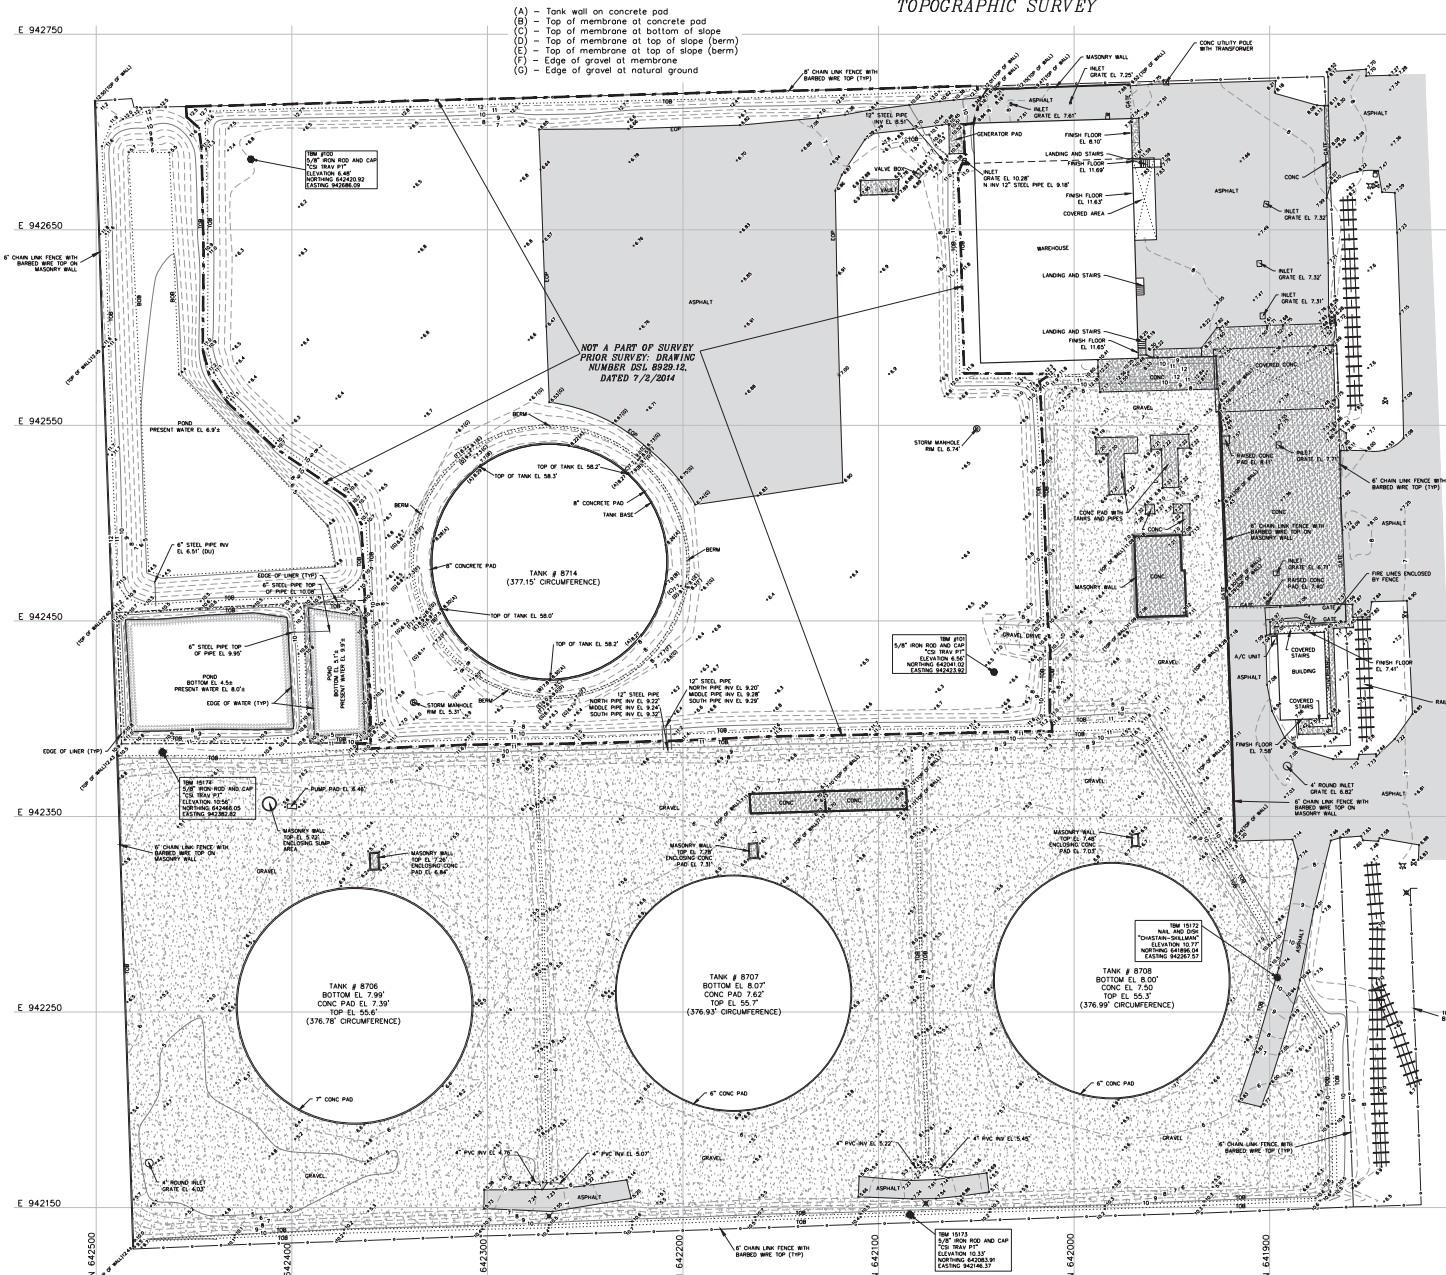

LEGEND:

A/C	As Constructed Unit	P.C.C.	Point of Commencement
B.M.	Bench Mark	P.M.	Point of Intersection
B.O.	Bottom of Bank	P.P.	Property Line
B.S.	Bottom of Slope	P.P.C.	Proposed Concrete Pipe
C	Center	P.P.C.	Proposed Concrete Pipe
C.C.	Center of Circle	P.P.C.	Proposed Concrete Pipe
C.D.	Center of Ditch	P.P.C.	Proposed Concrete Pipe
C.P.	Center of Pipe	P.P.C.	Proposed Concrete Pipe
C.P.	Center of Pipe	P.P.C.	Proposed Concrete Pipe
C.P.			


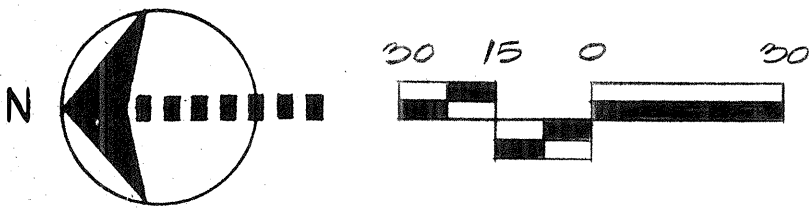


Figure 1
Buckeye Terminals, LLC
Fort Lauderdale Terminal



Figure 2
Buckeye Terminals, LLC
Fort Lauderdale Terminal

Site Plan 1: The Original Hess Terminal Site Plan (8 Tanks)

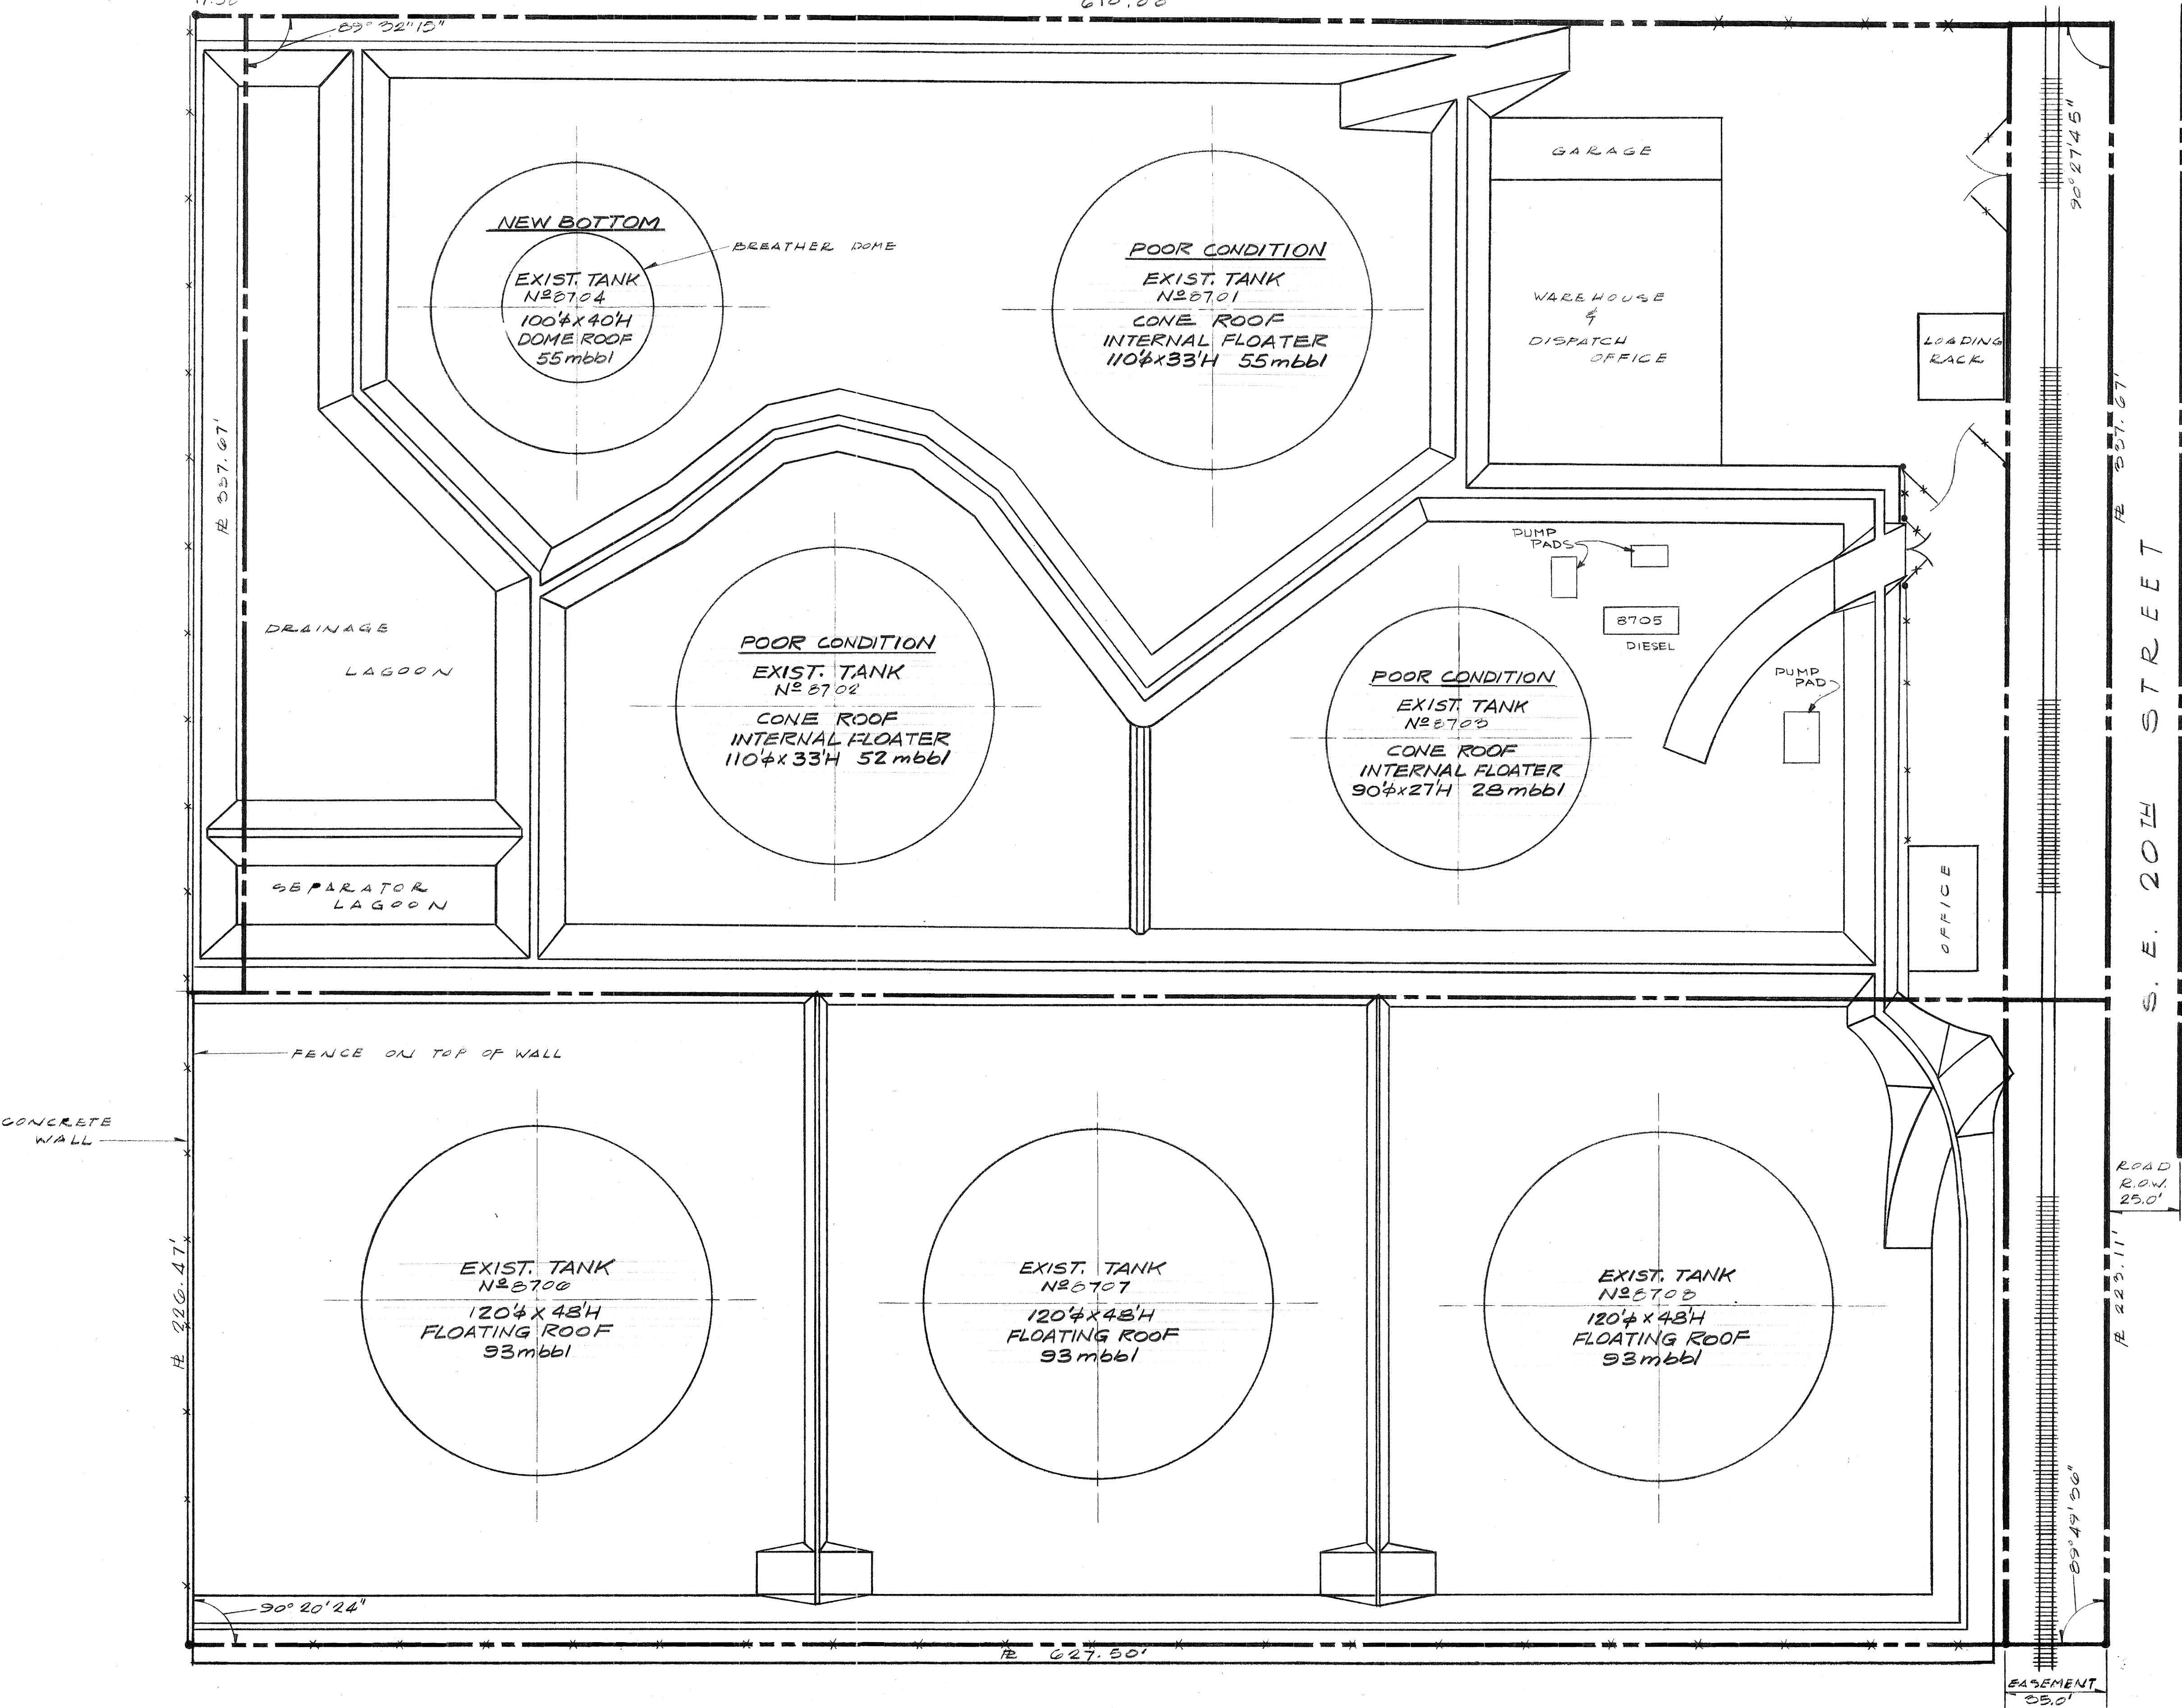


REV.	DATE	BY	DESCRIPTION				CHECK	APP'D.
APPROVALS AND CHECKS	DRAFTING CHECK	DESIGN APPROVAL	PROJECT ENG. APPROVAL					FINAL APPROVAL
AMERADA HESS CORPORATION								
1 HESS PLAZA, WOODBRIDGE, N.J.								
EXISTING TANKS LAYOUT								
FT. LAUDERDALE, FLA. 4/22/80 GSE/J.K.								

TR14SYM/FORMAT_NEW (04/15/99)



SP000

 
SCALE: 1" = 40'



-  = PROPERTY LINE
-  = NEW ETHANOL TANK
(FIXED CONE ROOF WITH
CABLE SUSPENDED IFR)
-  = NEW LINES

CAM #16-0490
Exhibit 1
Page 5 of 6

\\R145W\FORMAL-NEW (04/15/09)

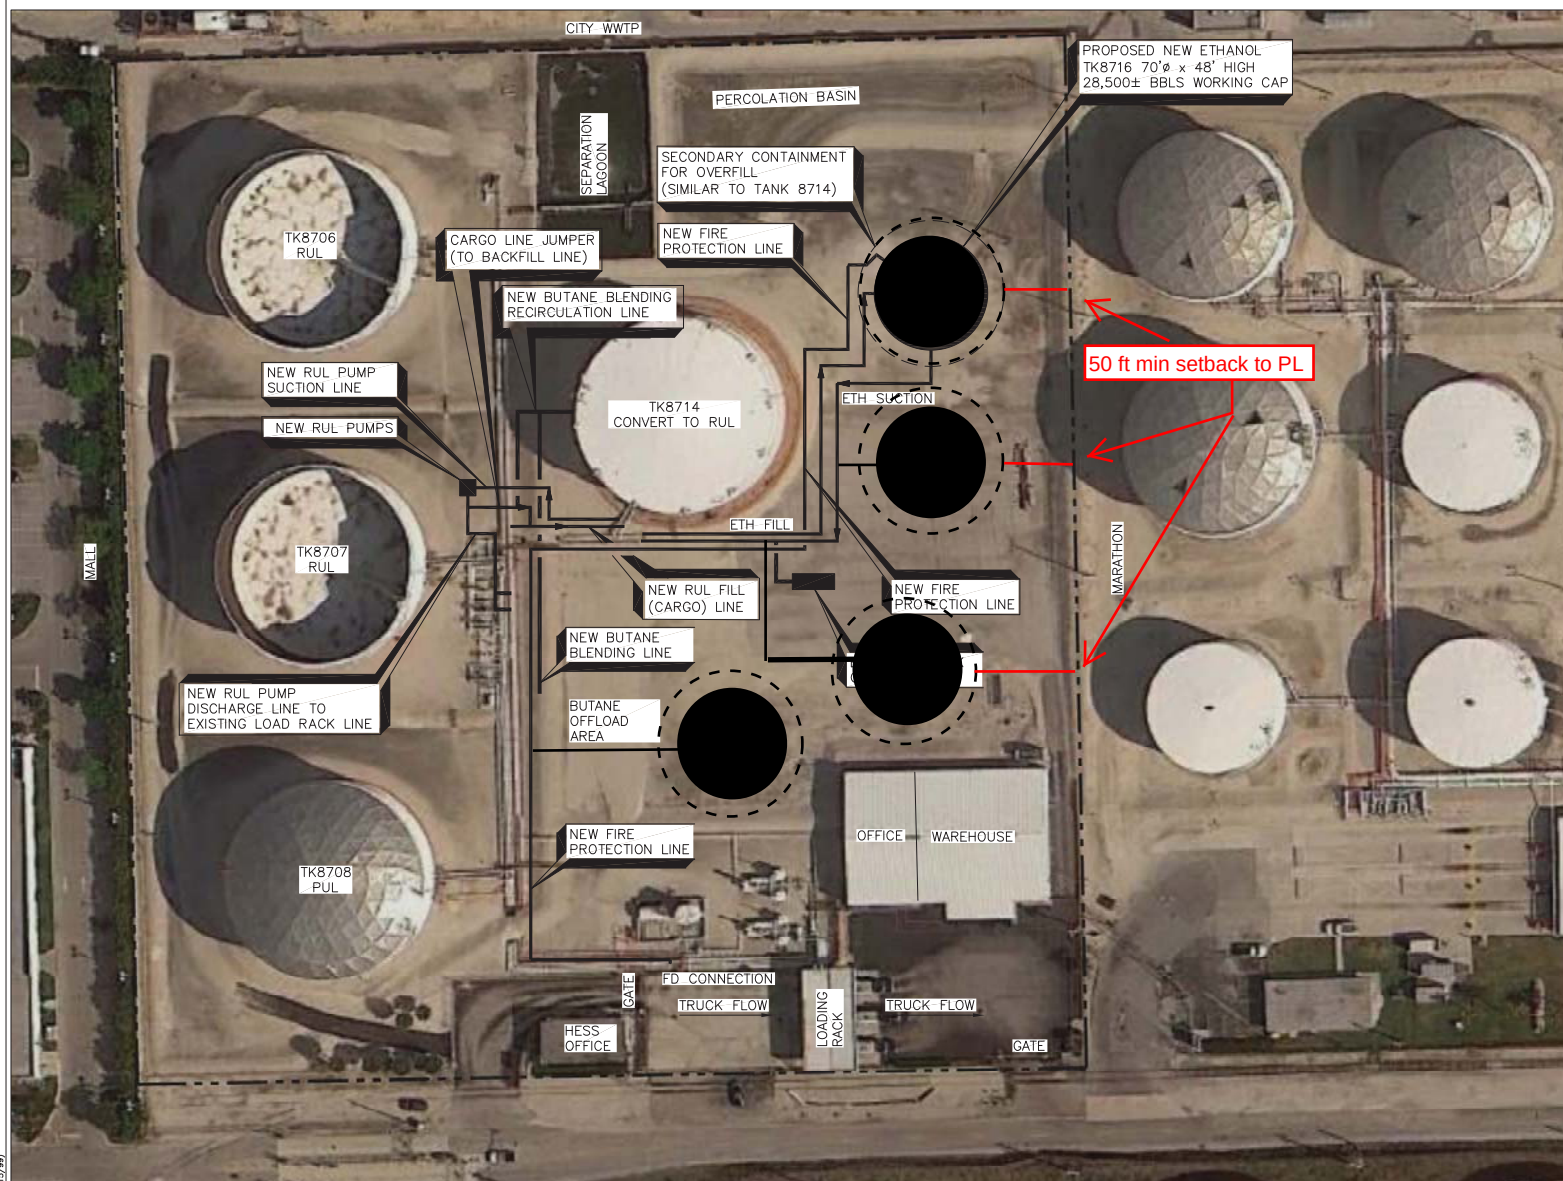

LEGEND

- — — — — = PROPERTY LINE
- = NEW ETHANOL TANK (FIXED CONE ROOF WITH CABLE SUSPENDED IFR)
- — — — — = NEW LINES



SP0001

SITE PLAN NEW ETHANOL TANK PROJECT

SCALE: 1" = 40'



REV #	DESCRIPTION	DATE
2	ISSUED FOR BID	12-18-15
1	ISSUED FOR REVIEW	11-18-15
1	SPEC	JOB #14-104

ISO
PAGE

5				
4				
3				
2				
1				
NO LOC		DESCRIPTION OF REVISION	BY DATE	APPR DATE
WORK ORDER NO.				
BUCKEYE TERMINALS, LP				
MECHANICAL SITE PLAN - 60,000 GALLON TANKS NEW TANK PROJECT FORT LAUDERDALE, FL				
DRAWN:	NONE	DATE:		
APPROVED:	XXX	CHECKED:	YY	NO. BET00SP0001
				REV -