


D


C

B

A

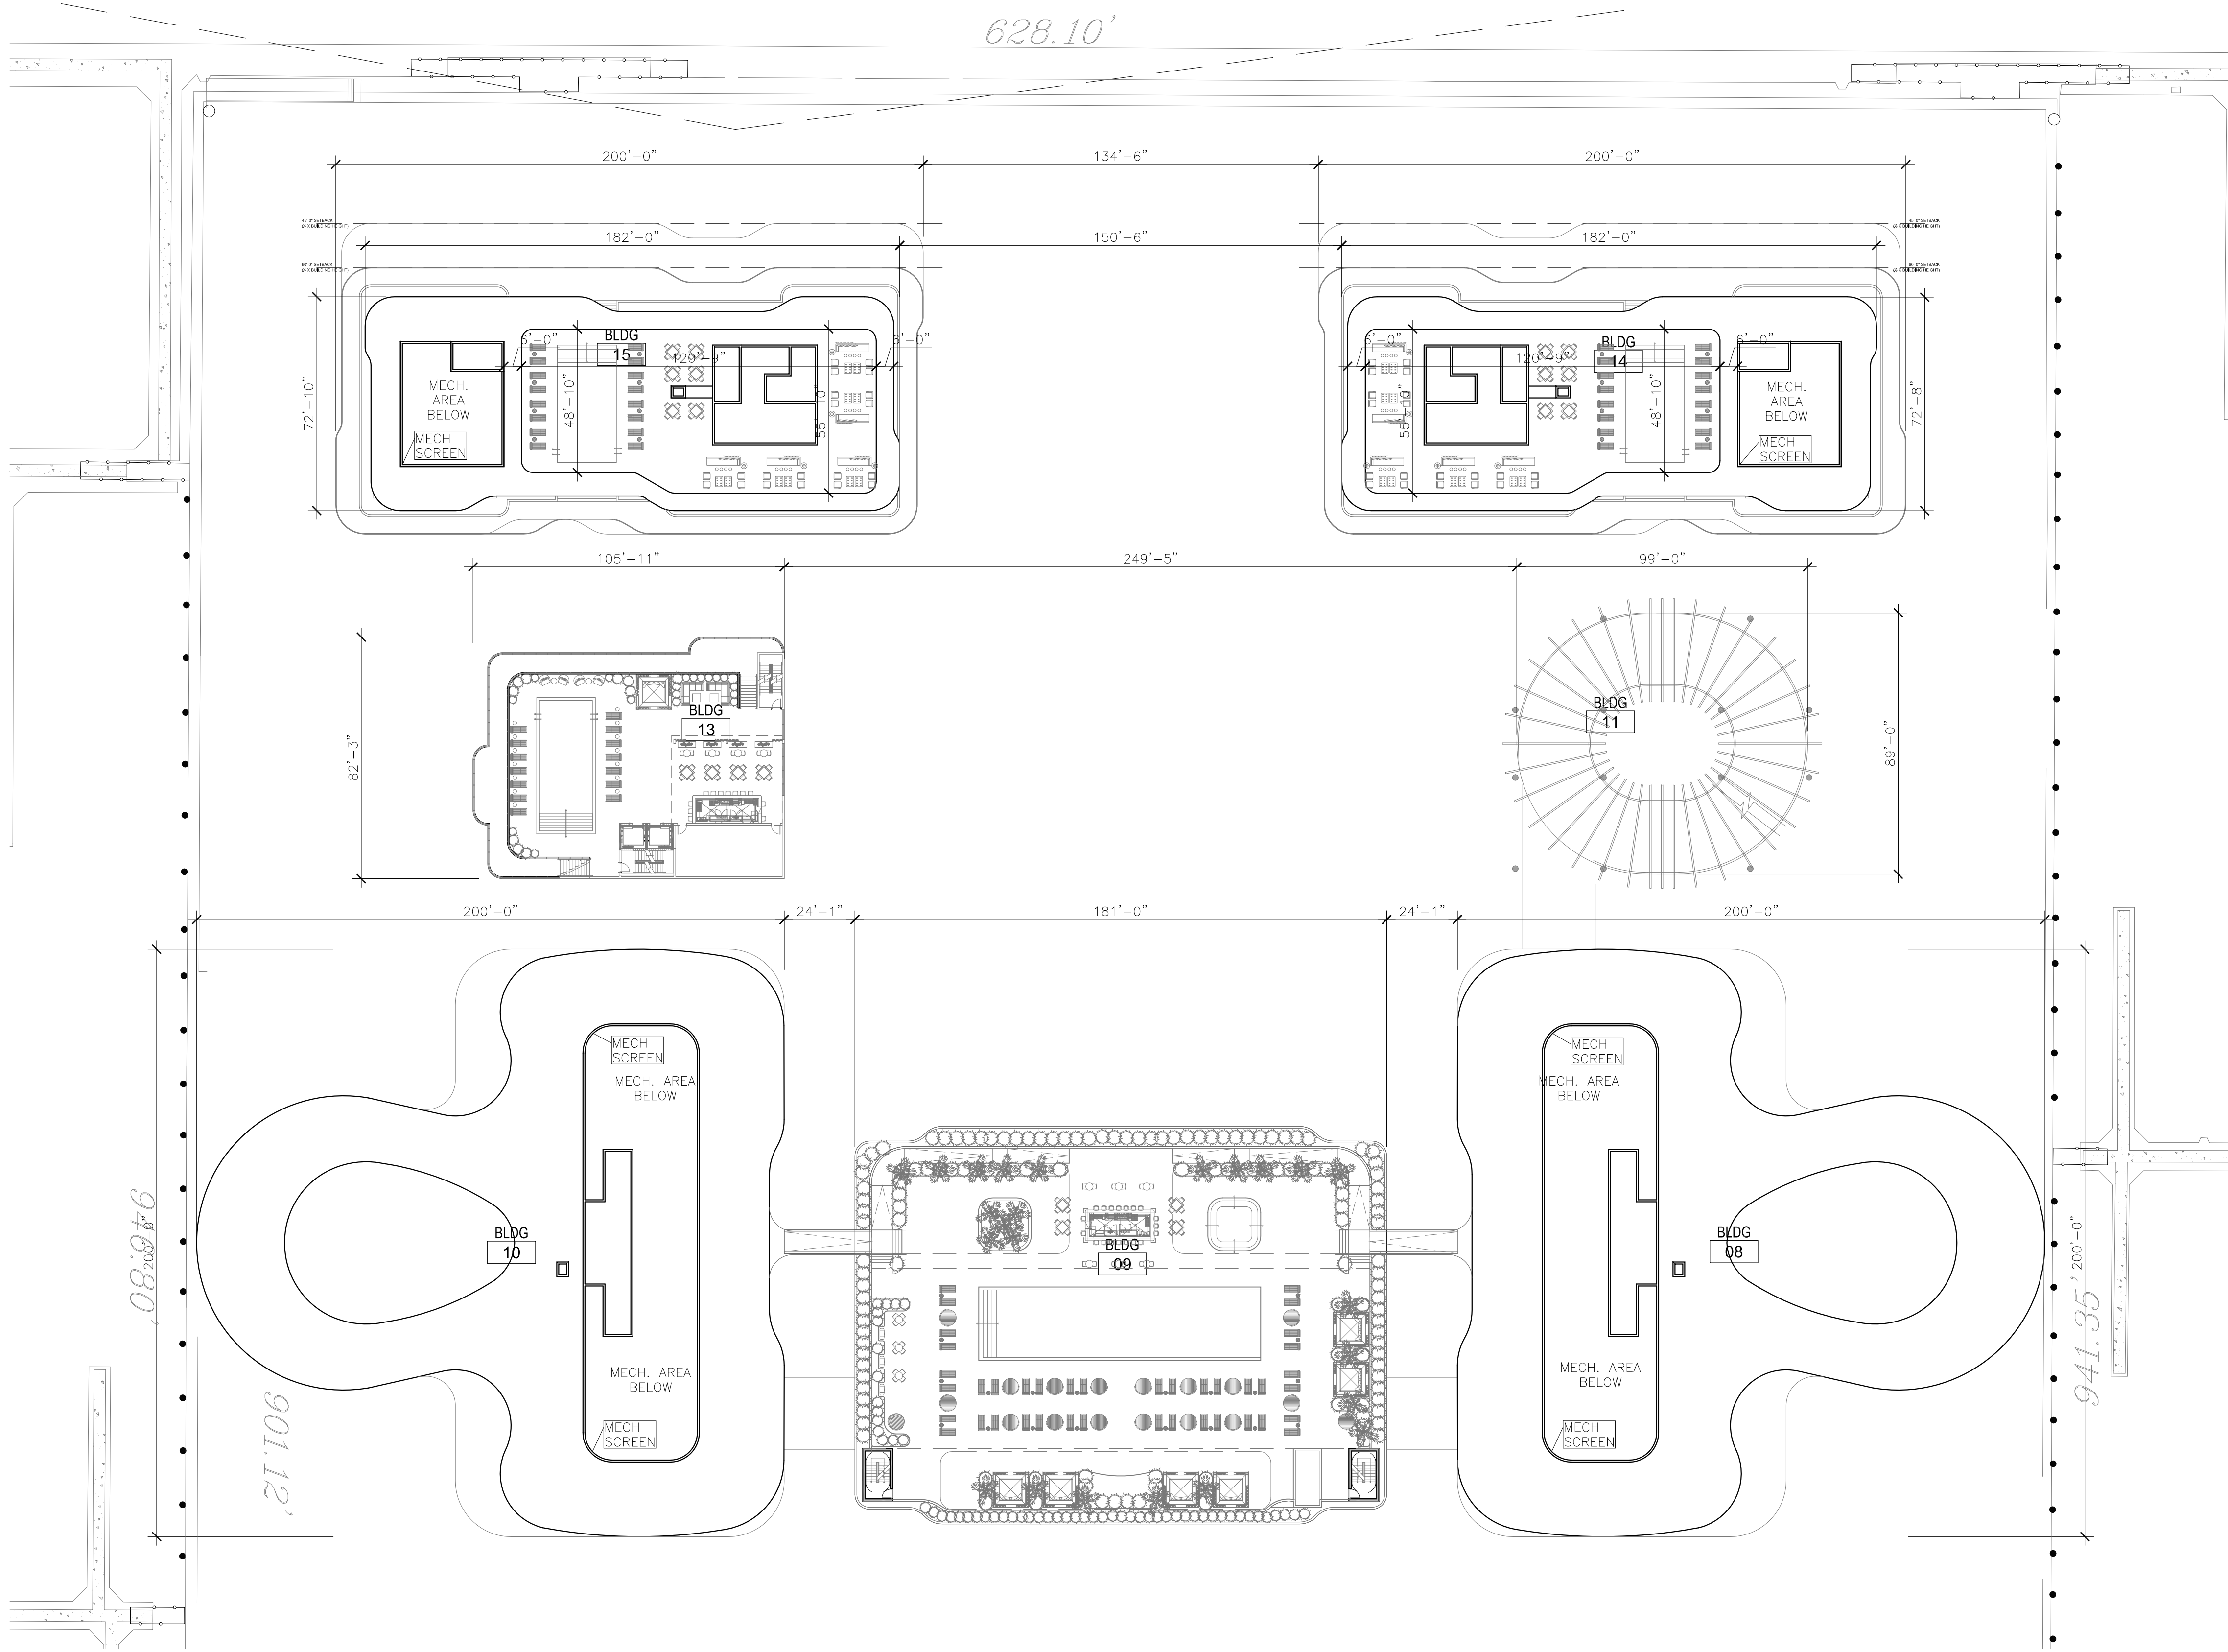

1 ENLARGED MECHANICAL ROOF PLAN WEST
Scale: 1/32" = 1'-0"

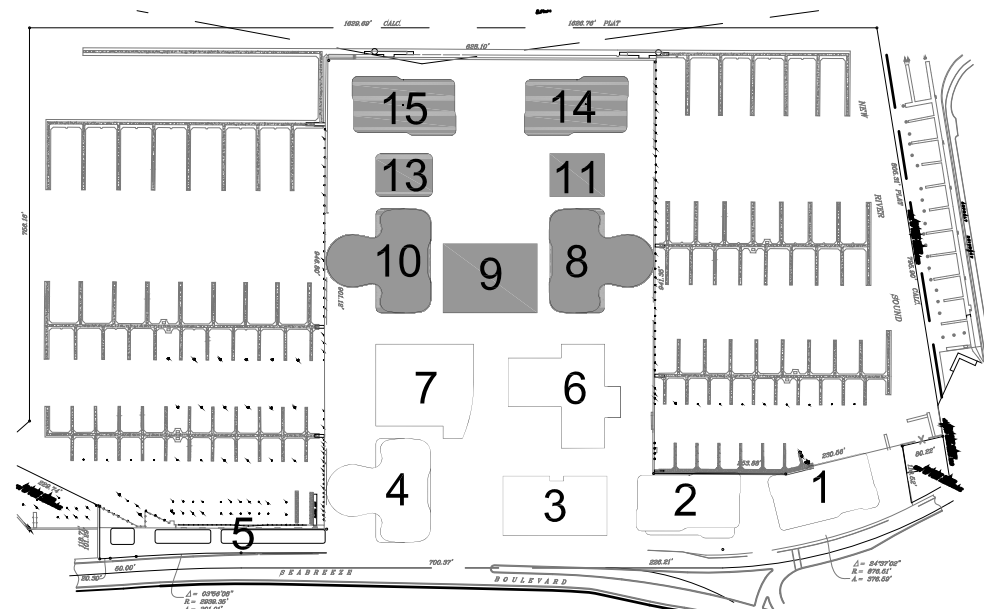


REVISIONS / SUBMISSIONS

1657


ALL DRAWINGS AND WRITTEN MATERIAL APPEARING HEREIN CONSTITUTE THE ORIGINAL AND UNPUBLISHED WORK OF KOBIKARP, INC. AND MAY NOT BE DUPLICATED, USED, OR REPRODUCED WITHOUT THE EXPRESS WRITTEN CONSENT OF KOBIKARP ARCHITECTURE & INTERIOR DESIGN, INC. (A.I.) © 2017

BAHIA MAR
801 SEABREEZE BLVD.
FORT LAUDERDALE, FL 33316

LANDSCAPE ARCHITECT
EDSA, Inc.
1512 E Broward Blvd. #110
Fort Lauderdale, Florida 33301
Tel: 954.524.3330

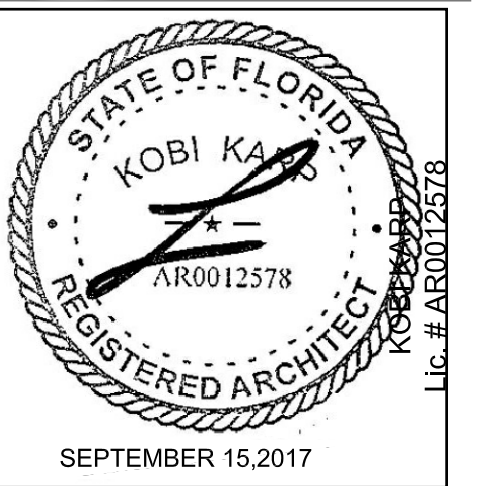

ARCHITECTURE INTERIOR DESIGN PLANNING
AIA ASID NCARB
2915 Biscayne Boulevard
Miami, Florida 33137
O: 305.573.1818
F: 305.573.3766
WWW.KOBIKARP.COM
Lic. # AR0012578

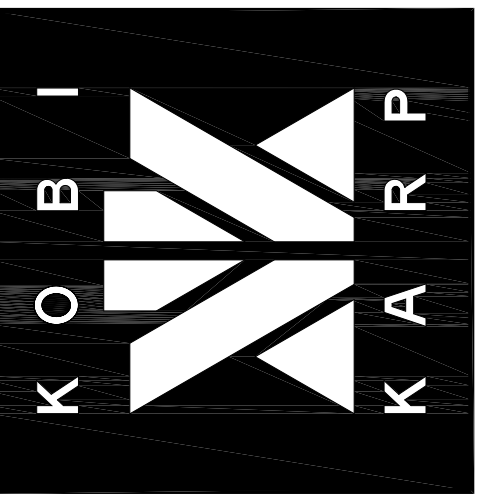

DRAWN BY: MC / AR / JPR / AM
CHECKED BY: AR
DATE: 09/15/2017

ENLARGED MECHANICAL ROOF PLAN WEST

A3.12


1657

ALL DRAWINGS AND WRITTEN MATERIAL APPEARING HEREIN
CONSTITUTE THE ORIGINAL AND UNPUBLISHED WORK OF KOB
KARP AND MAY NOT BE REPRODUCED, COPIED, OR REPRODUCED
WITHOUT THE EXPRESS WRITTEN CONSENT OF KOB KARP
ARCHITECTURE & INTERIOR DESIGN, INC. (AIA) © 2017


BAHIA MAR
801 SEABREEZE BLVD.
FORT LAUDERDALE, FL 33316

LANDSCAPE
ARCHITECT

EDSA, Inc.
1512 E Broward Blvd. #110
Fort Lauderdale, Florida 33301
Tel: 954.524.3330

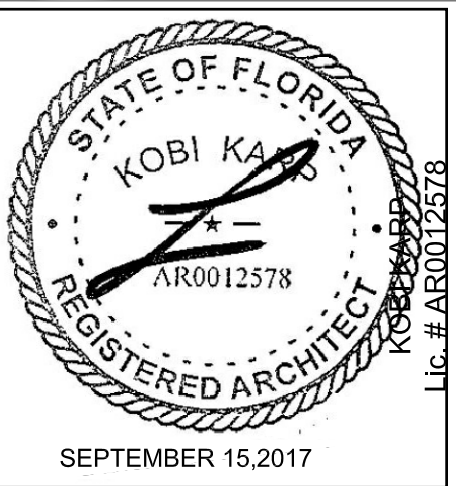


ARCHITECTURE
INTERIOR DESIGN
PLANNING
AIA ASID NCARB
2915 Biscayne Boulevard
Miami, Florida 33137
O: 305.573.1818
F: 305.573.3766
WWW.KOBKARP.COM
Lic. # AR0012578

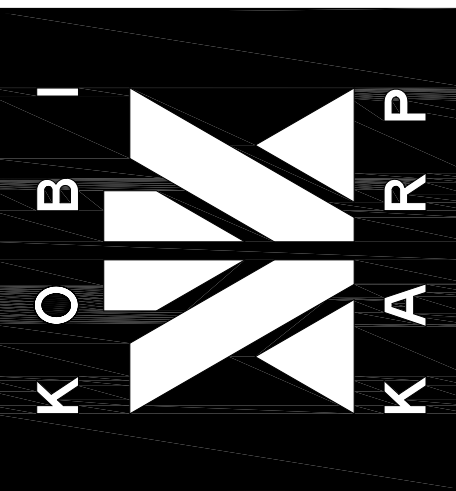


DRAWN BY: MC / AR / JPR / AM
CHECKED BY: AR
DATE: 09/15/2017

ENLARGED
LEVEL 00
FLOOR PLAN
EAST

A3.20.01

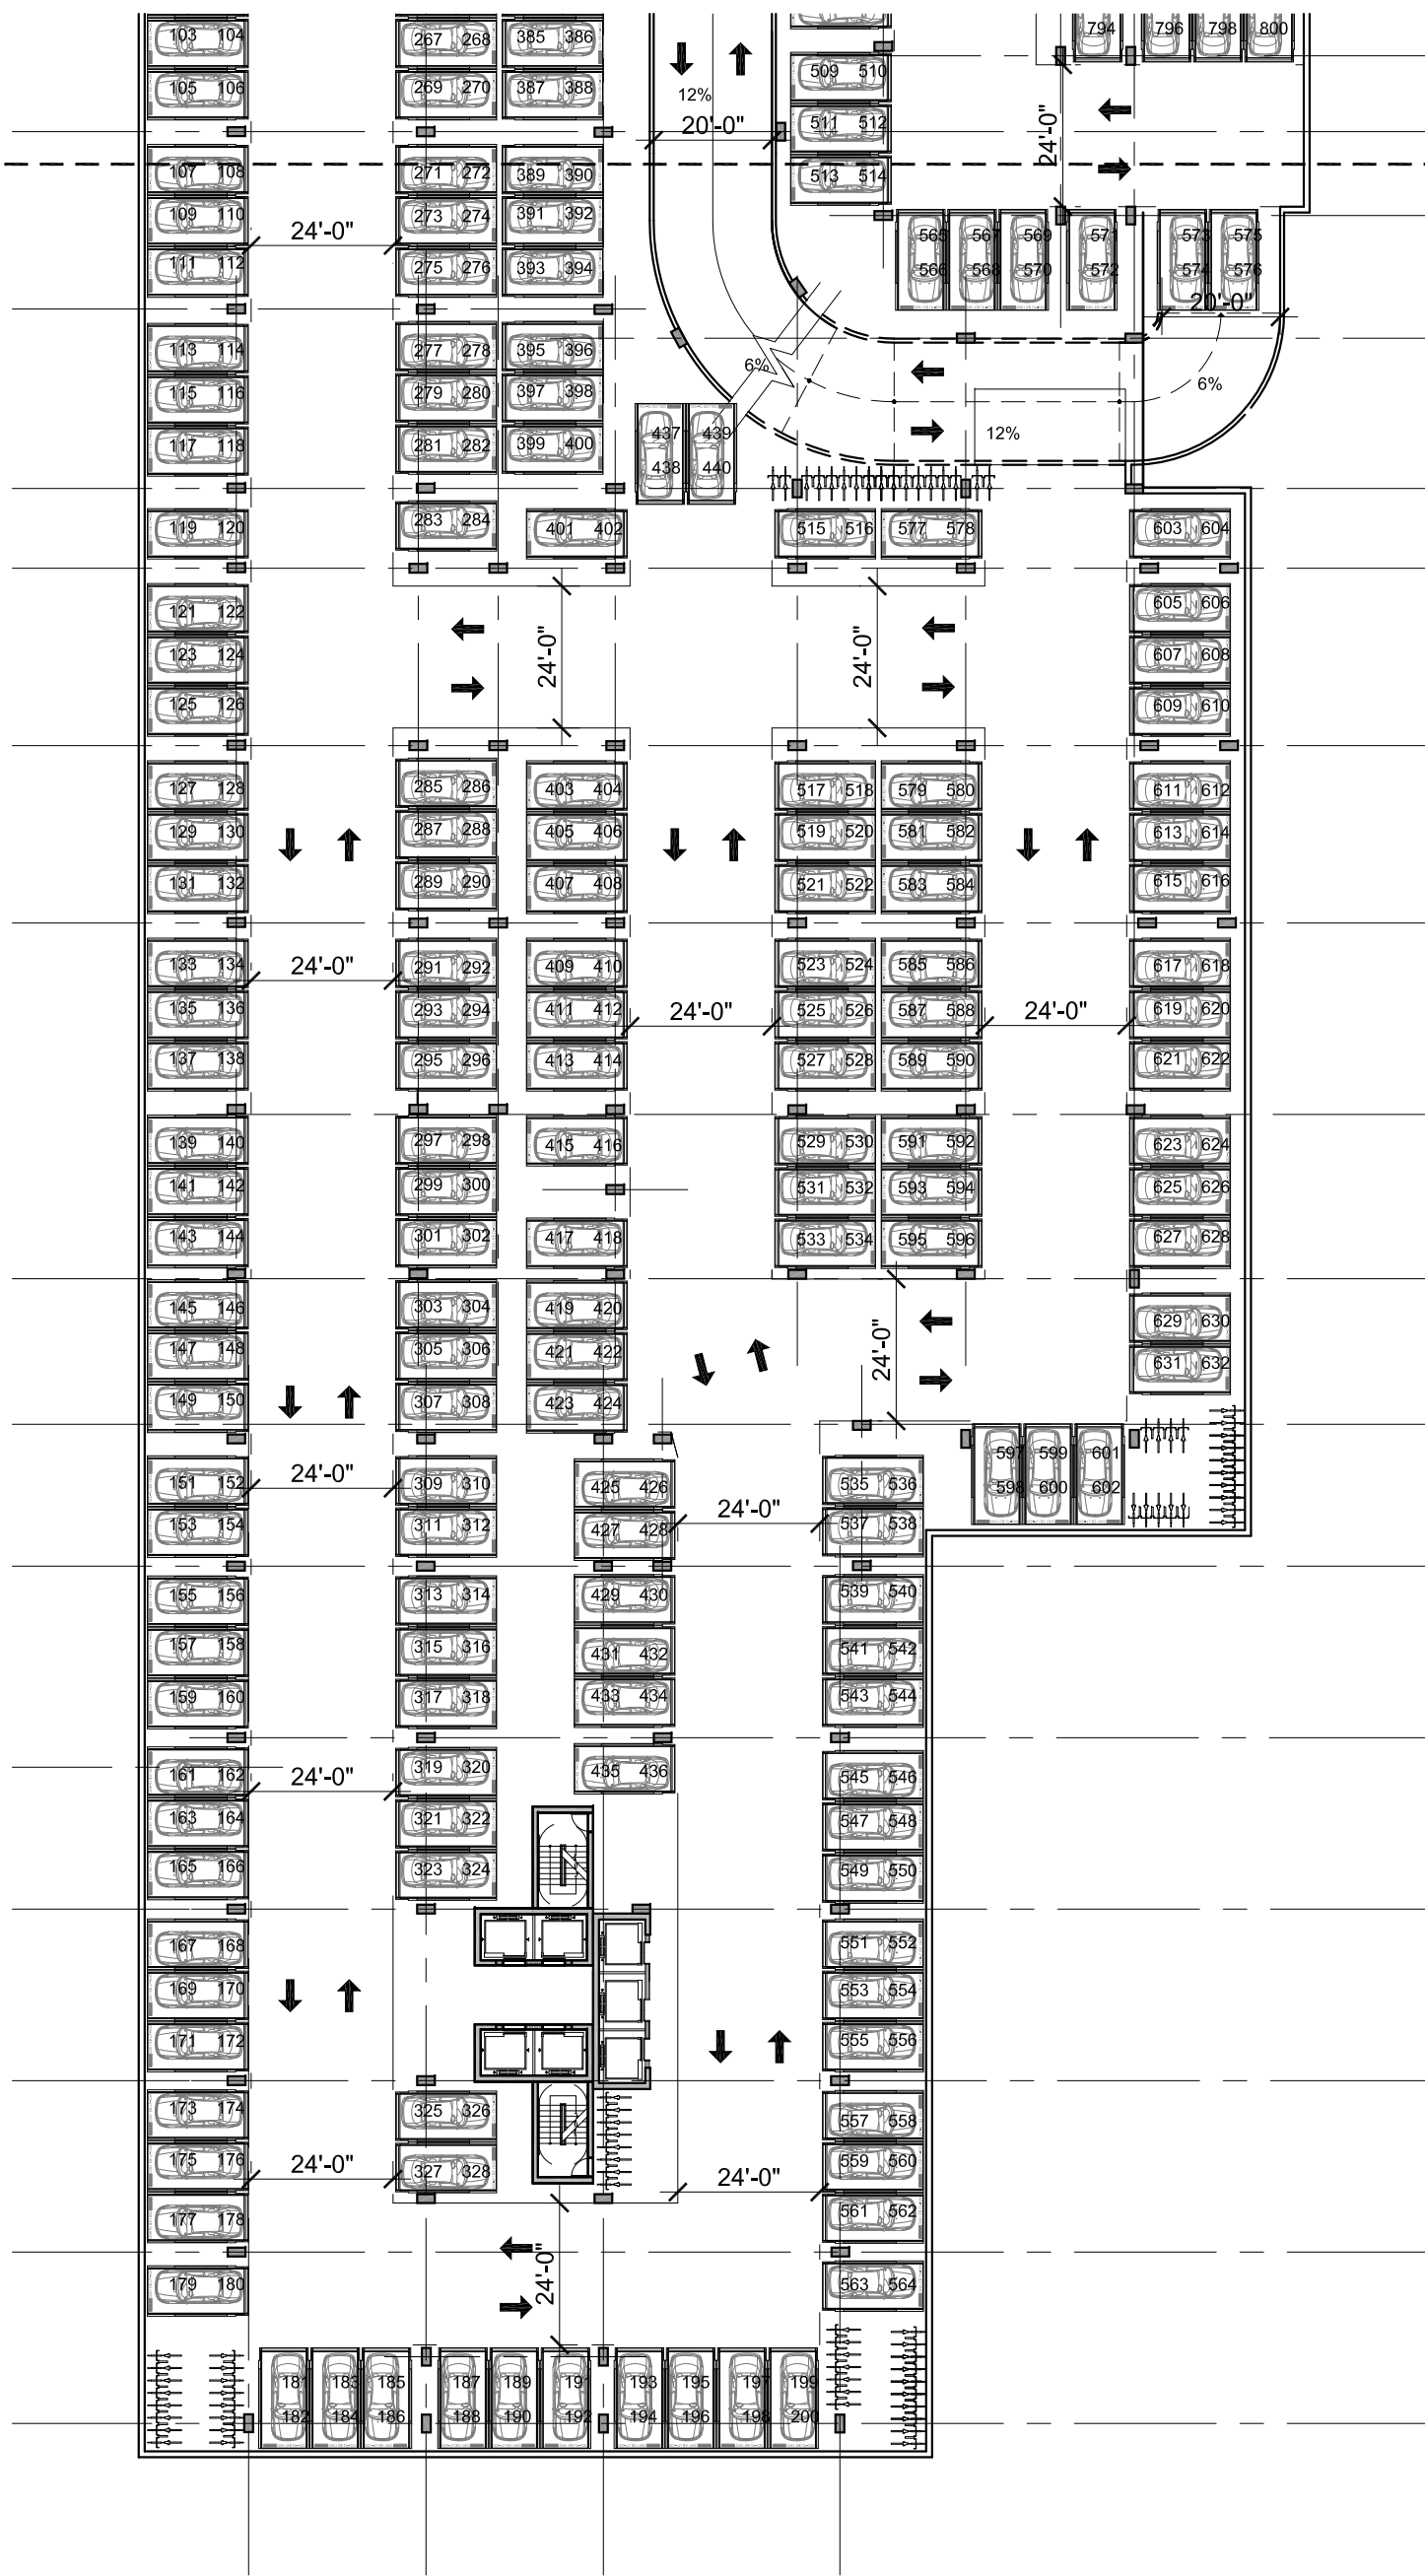

1 ENLARGED LEVEL 00 FLOOR PLAN EAST
Scale: 1/32" = 1'-0"

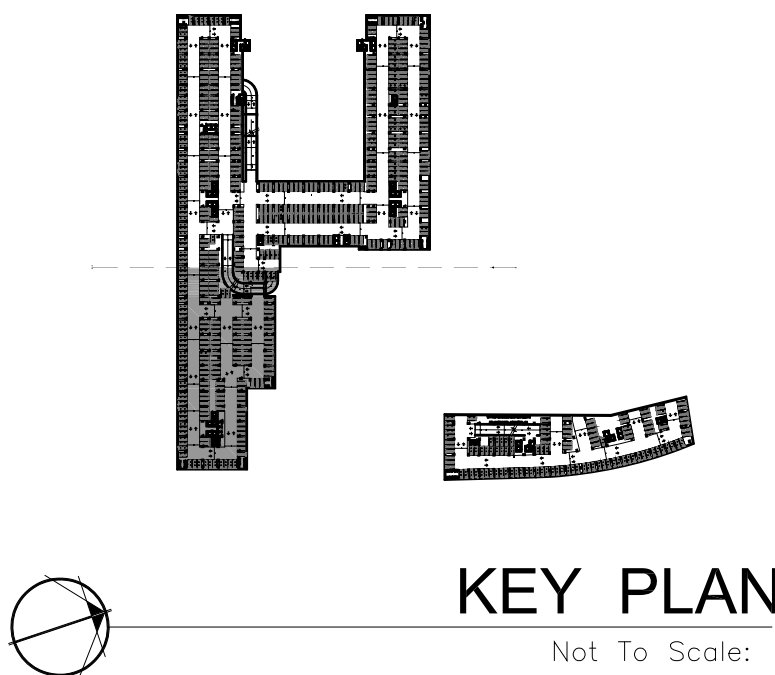

KEY PLAN
Not To Scale:


1657

ALL DRAWINGS AND WRITTEN MATERIAL APPEARING HEREIN CONSTITUTE THE ORIGINAL AND UNPUBLISHED WORK OF KOB KARP AND MAY NOT BE REPRODUCED, COPIED, OR INCLOSED WITHOUT THE EXPRESS WRITTEN CONSENT OF KOB KARP ARCHITECTURE & INTERIOR DESIGN, INC. (KID), 2017

BAHIA MAR
801 SEABREEZE BLVD.
FORT LAUDERDALE, FL 33316


LANDSCAPE
ARCHITECT

EDSA, Inc.
1512 E Broward Blvd. #110
Fort Lauderdale, Florida 33301
Tel: 954.524.3330

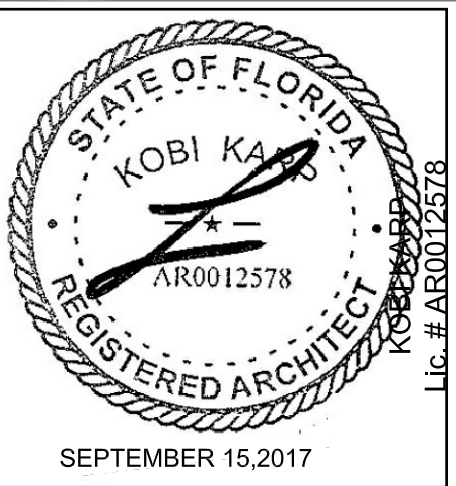

ARCHITECTURE
INTERIOR DESIGN
PLANNING


AIA ASID NCARB
2915 Biscayne Boulevard
Miami, Florida 33137
O: 305.573.1818
F: 305.573.3766
WWW.KOBKARP.COM
Lic. # AR0012578

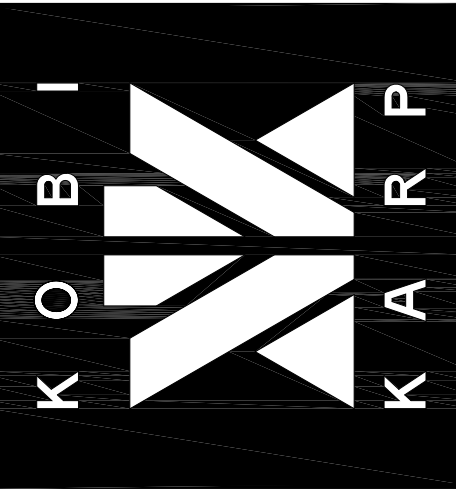


DRAWN BY: MC / AR / JPR / AM
CHECKED BY: AR
DATE: 09/15/2017


ENLARGED
LEVEL 0
FLOOR PLAN
EAST

A3.21

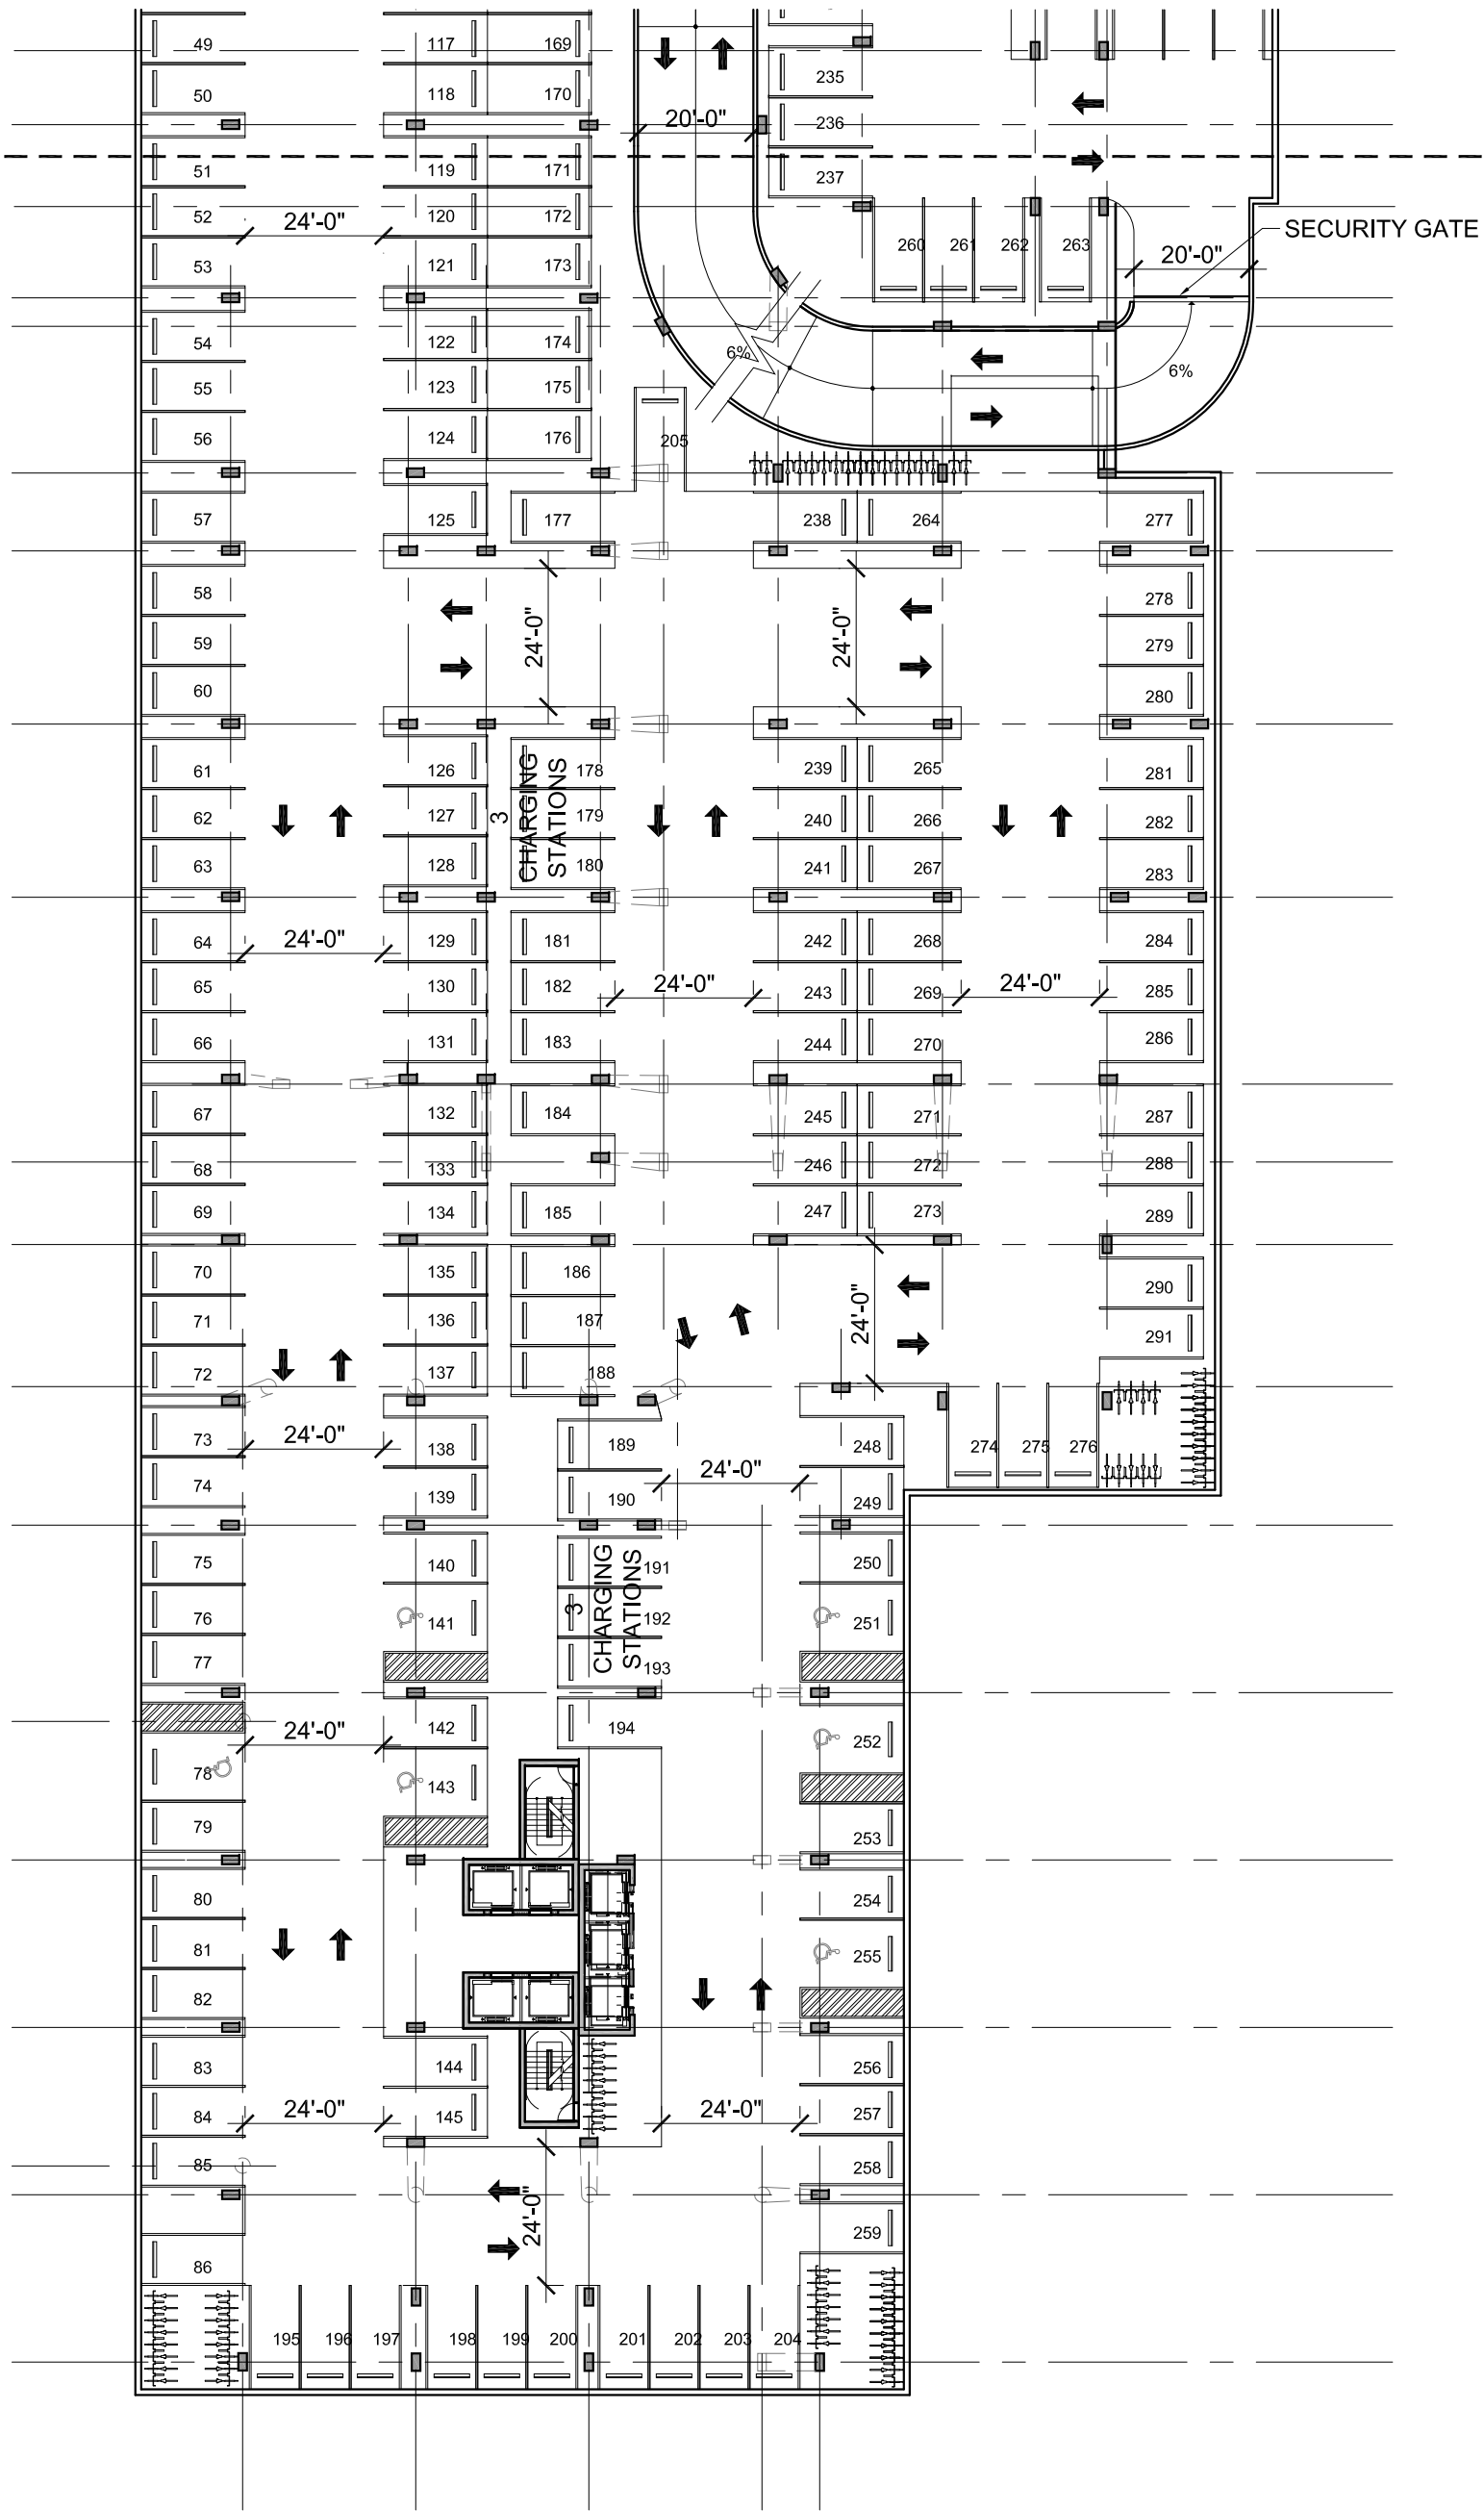


1 ENLARGED LEVEL 0 FLOOR PLAN EAST
Scale: 1/32" = 1'-0"

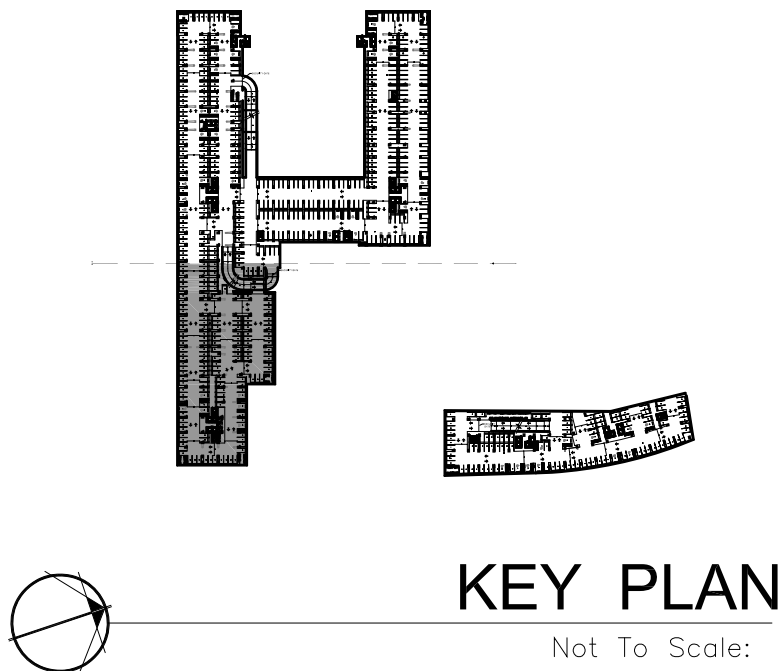

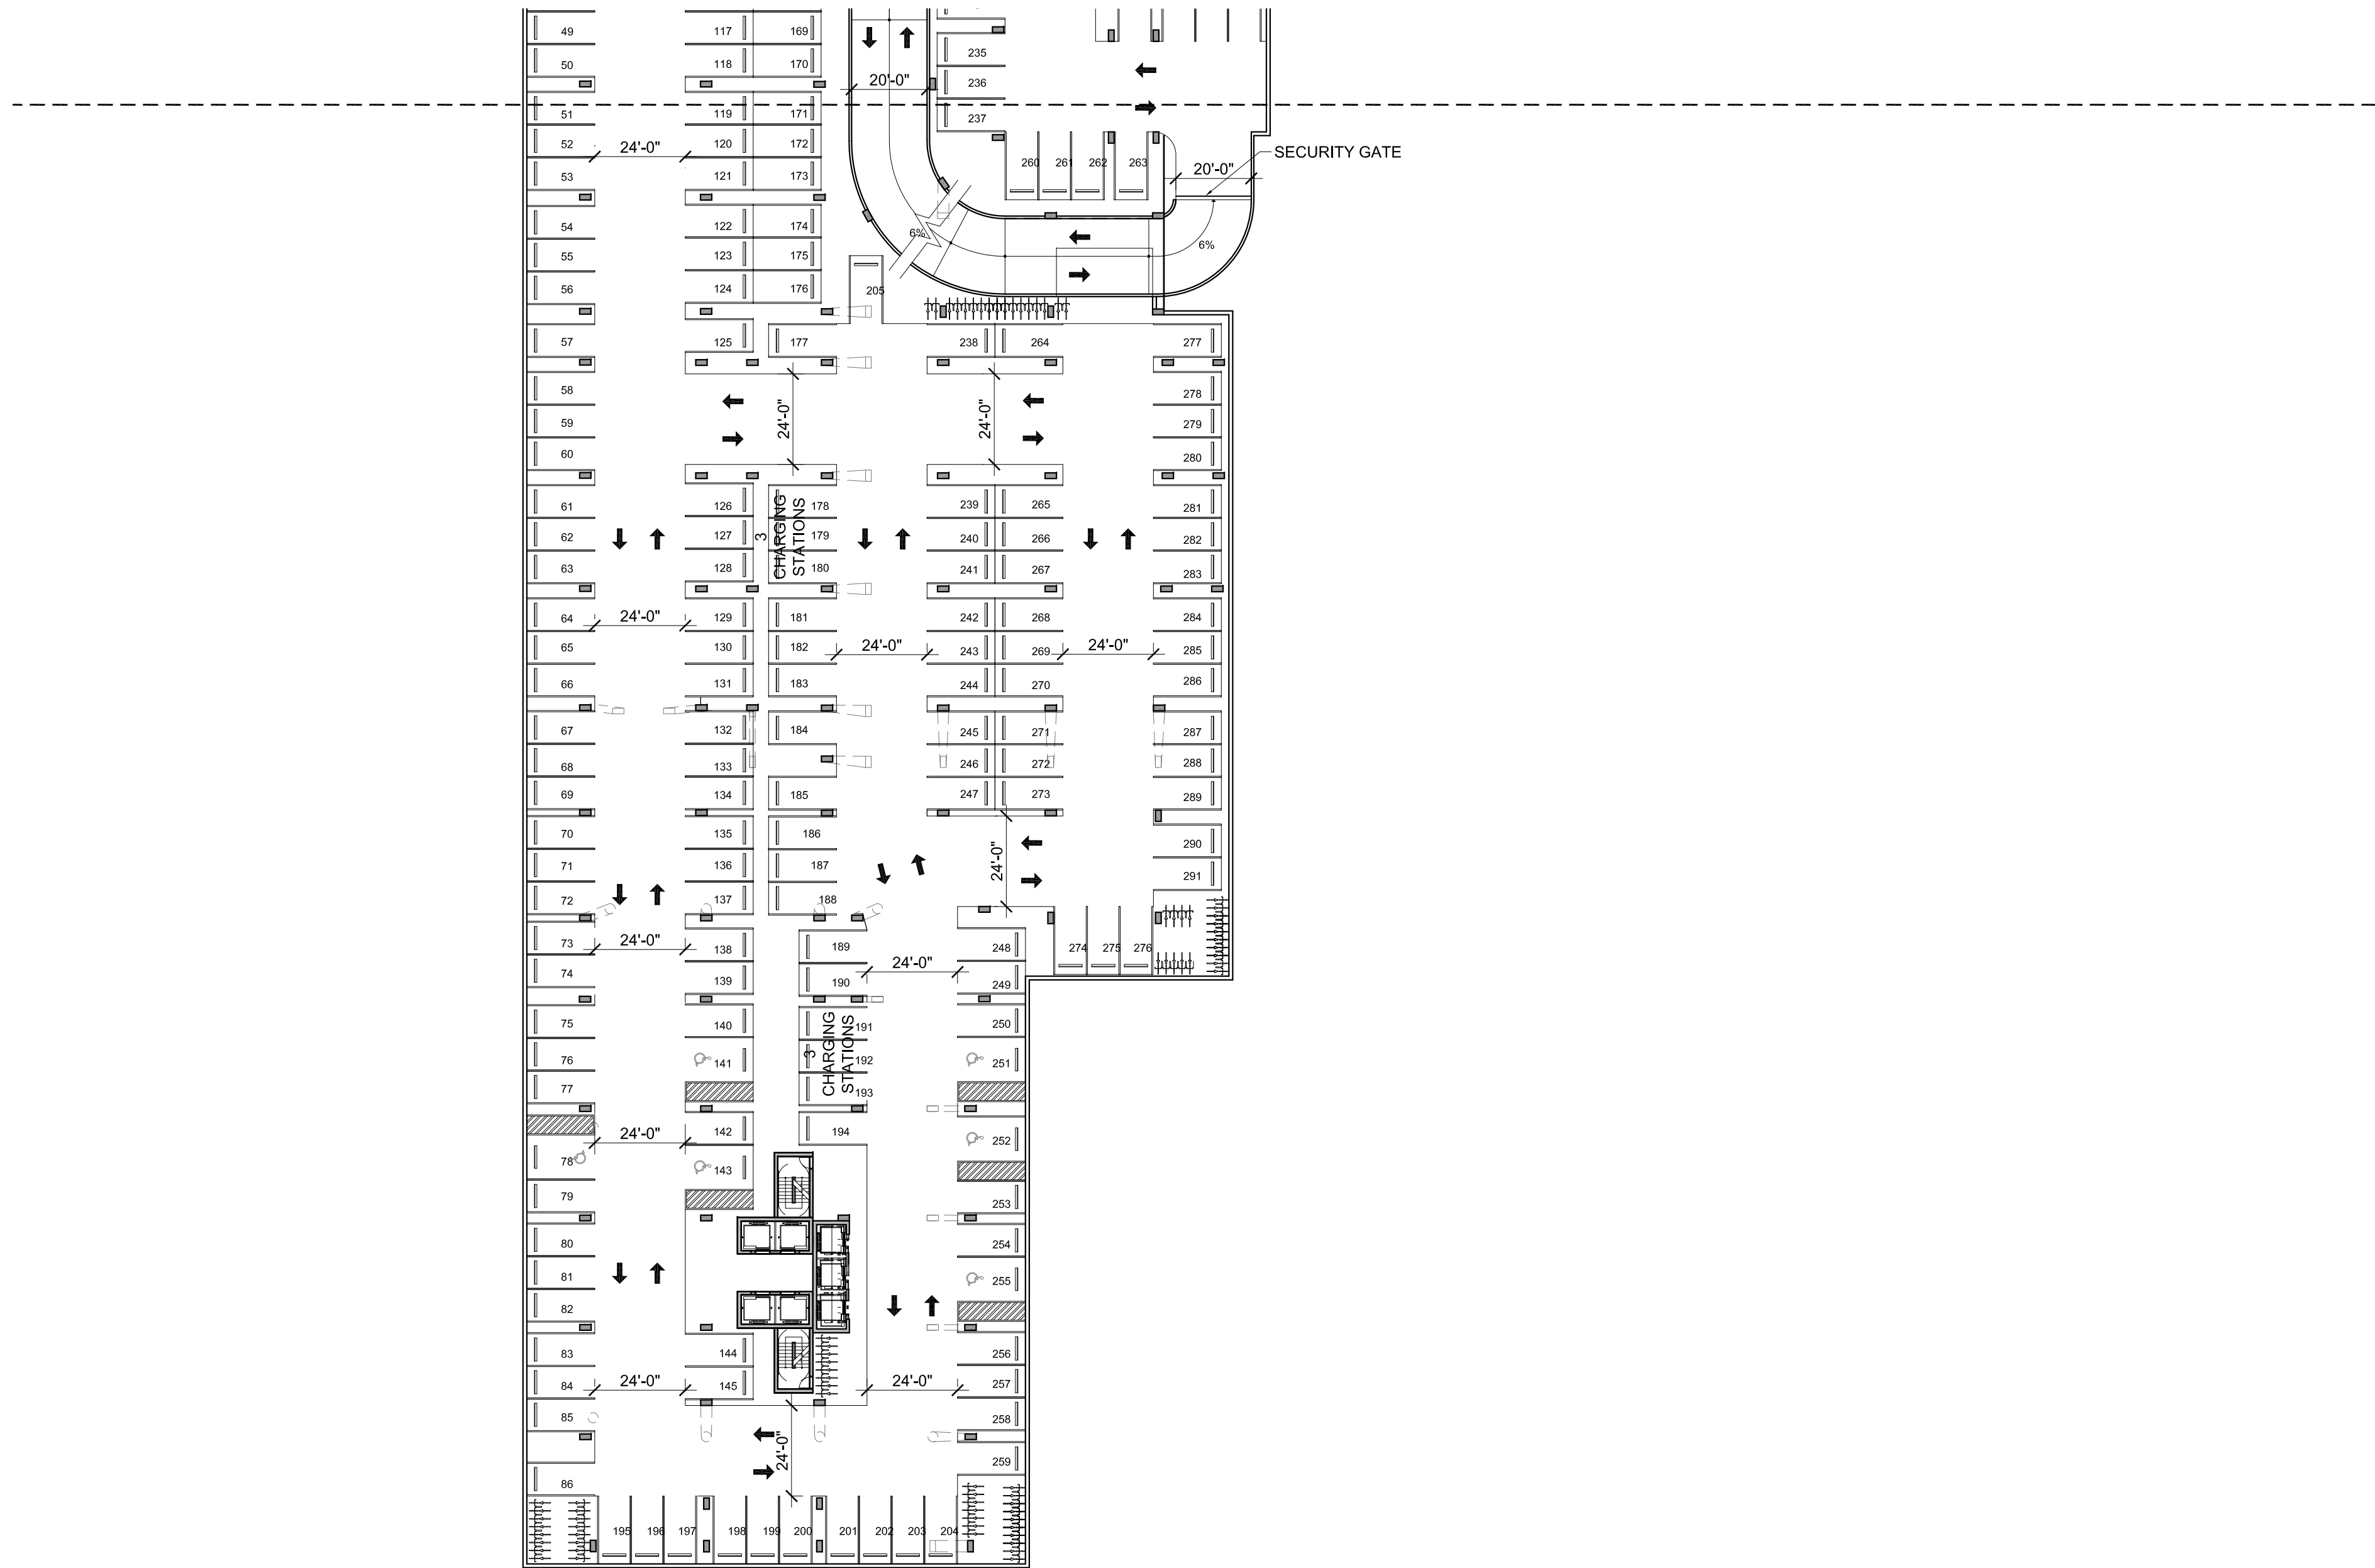

1 ENLARGED LEVEL 0 FLOOR PLAN EAST
Scale: 1/32" = 1'-0"

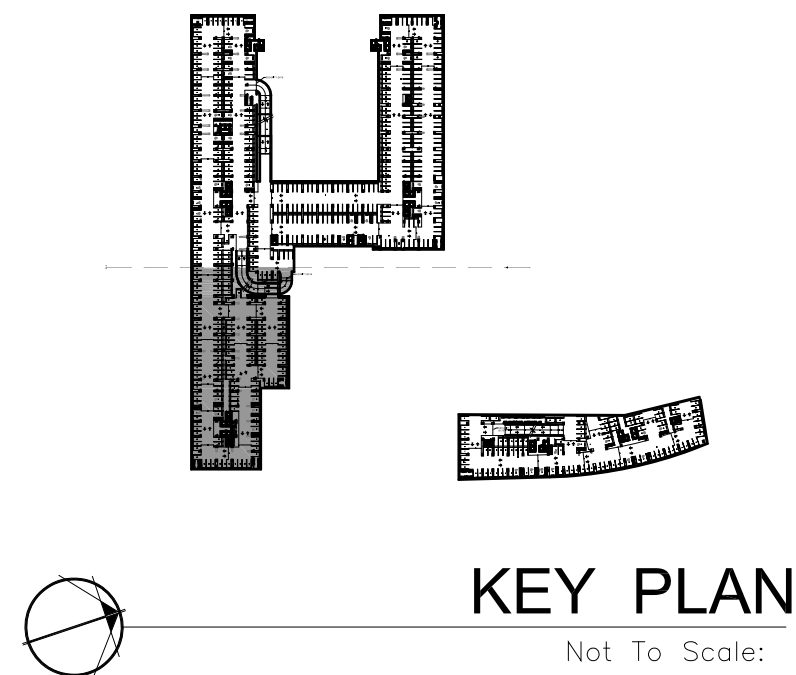

REVISIONS / SUBMISSIONS


1657

ALL DRAWINGS AND WRITTEN MATERIAL APPEARING HEREIN CONSTITUTE THE ORIGINAL AND UNPUBLISHED WORK OF KOBIKARP AIA, AND MAY NOT BE REPRODUCED, COPIED, OR ENCLOSED WITHOUT THE EXPRESS WRITTEN CONSENT OF KOBIKARP ARCHITECTURE & INTERIOR DESIGN, INC. (AIA) © 2017

BAHIA MAR
801 SEABREEZE BLVD.
FORT LAUDERDALE, FL 33316


LANDSCAPE
ARCHITECT

EDSA, Inc.
1512 E Broward Blvd. #110
Fort Lauderdale, Florida 33301
Tel: 954.524.3330

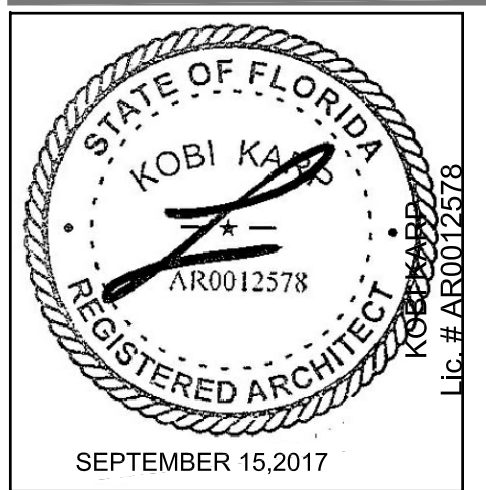

ARCHITECTURE
INTERIOR DESIGN
PLANNING




AIA ASID NCARB
2915 Biscayne Boulevard
Miami, Florida 33137
O: 305.573.1818
F: 305.573.3766
WWW.KOBIKARP.COM
Lic. # AR0012578

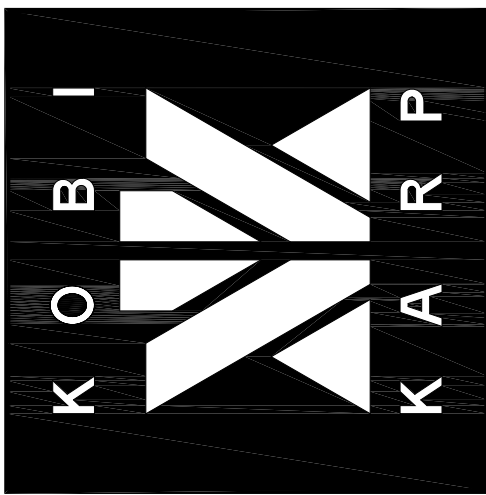


DRAWN BY: MC / AR / JPR / AM
CHECKED BY: AR
DATE: 09/15/2017


ENLARGED
LEVEL 0
FLOOR PLAN
EAST

A3.21

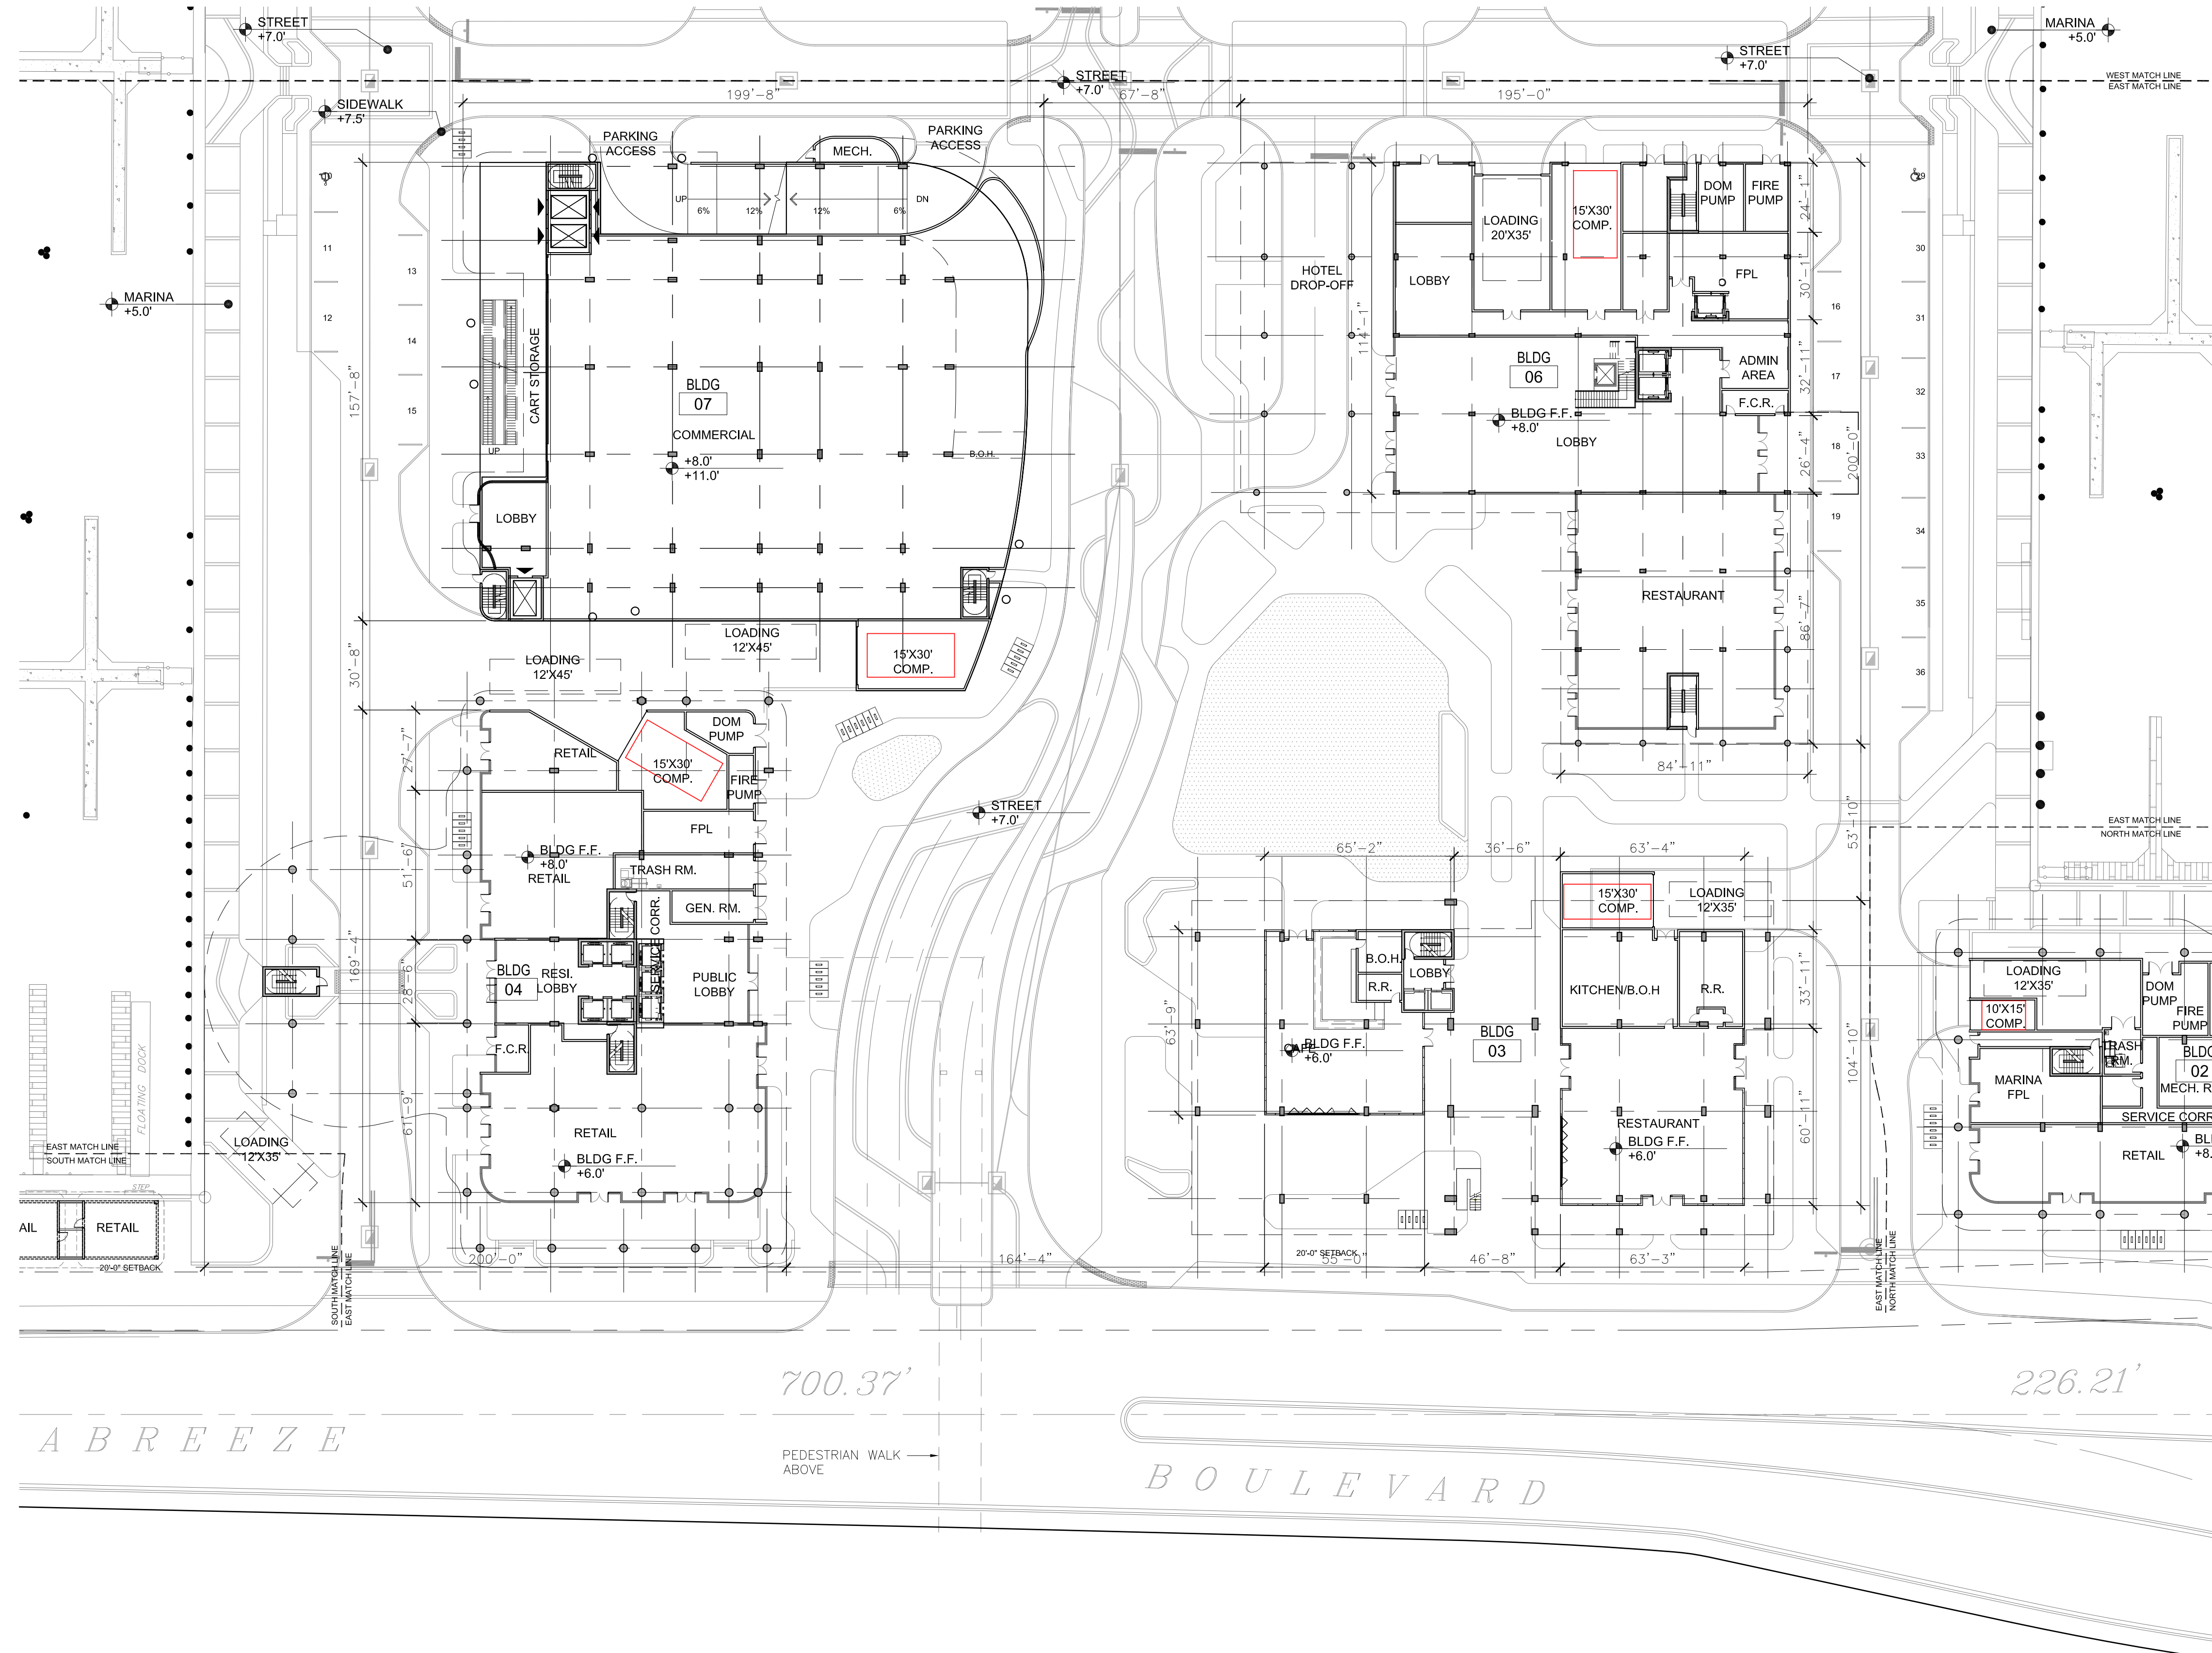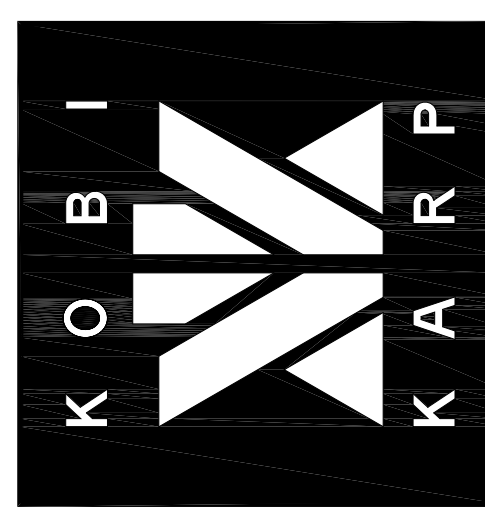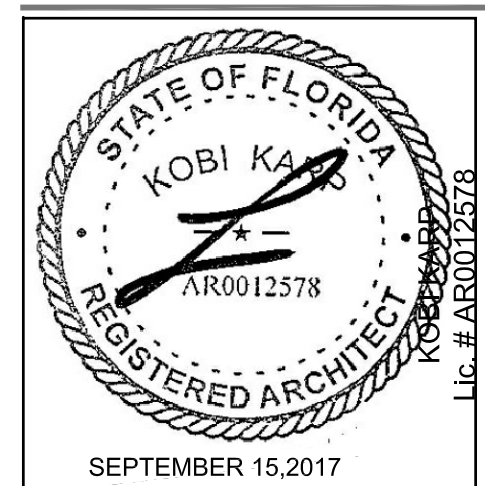


1 ENLARGED LEVEL 1 FLOOR PLAN EAST
Scale: 1/32" = 1'-0"

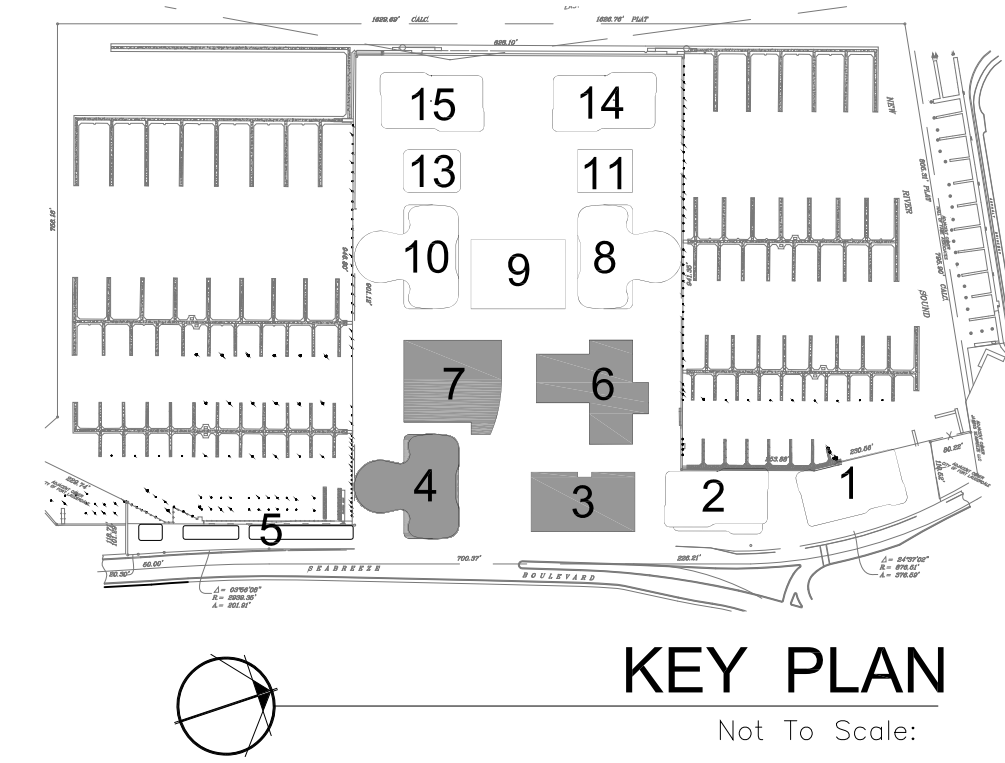

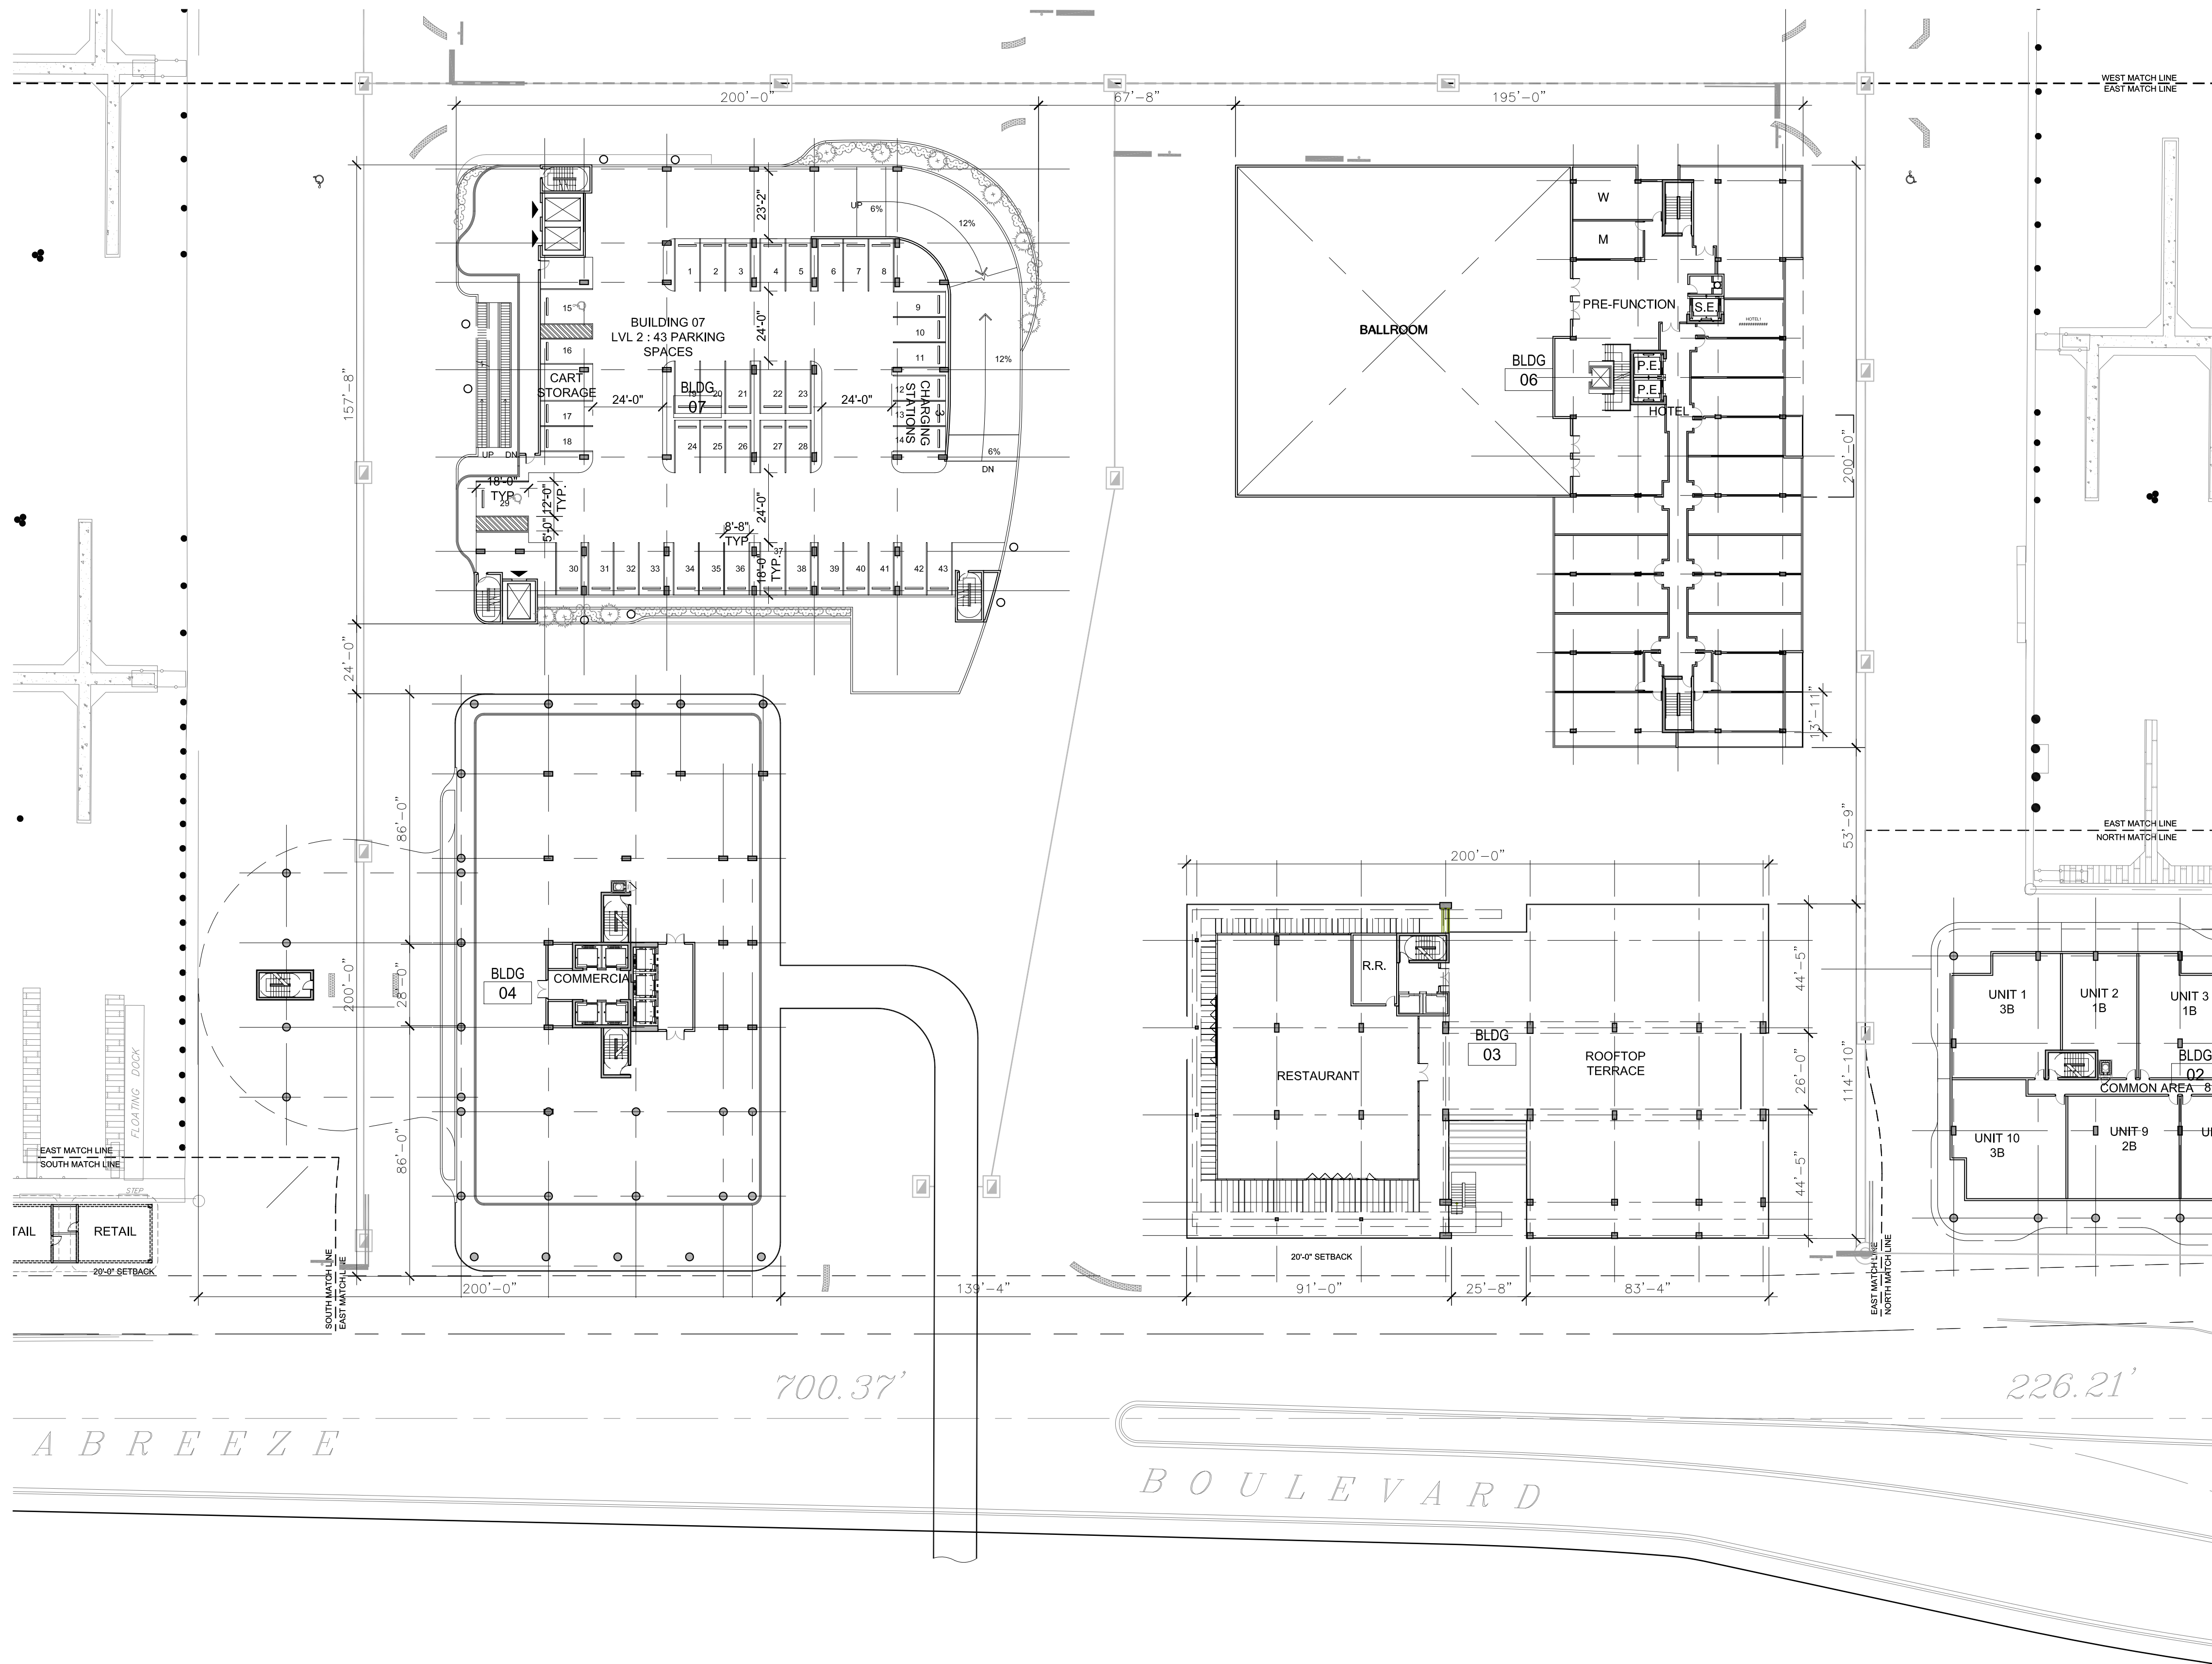

1 ENLARGED LEVEL 2 FLOOR PLAN EAST
Scale: 1/32" = 1'-0"

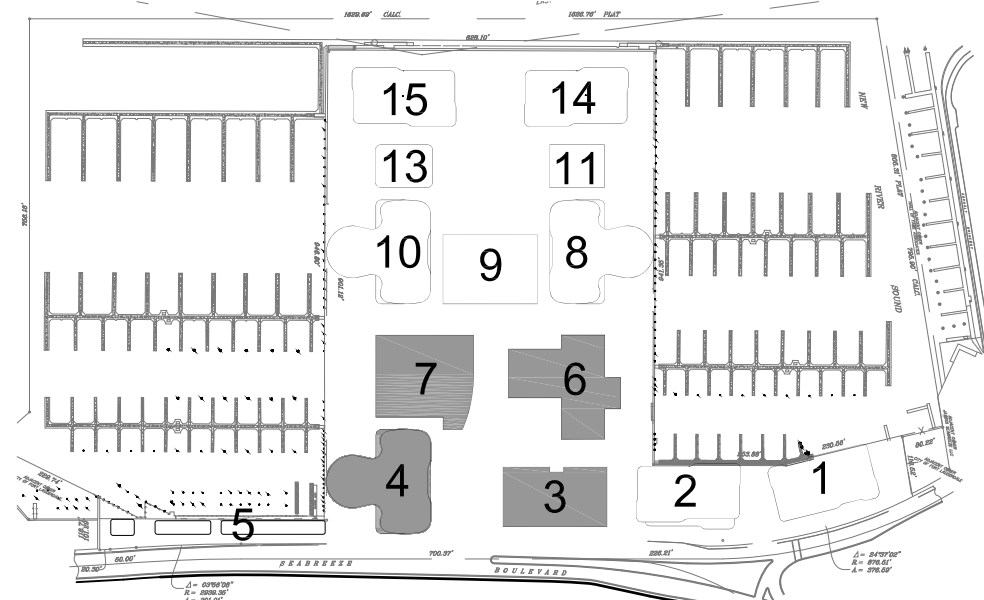

KEY PLAN
Not To Scale:

REVISIONS / SUBMISSIONS


1657

ALL DRAWINGS AND WRITTEN MATERIAL APPEARING HEREIN
CONSTITUTE THE ORIGINAL AND UNPUBLISHED WORK OF KOB
KARP, INC. AND MAY NOT BE REPRODUCED, COPIED, OR
WITHOUT THE EXPRESS WRITTEN CONSENT OF KOB KARP
ARCHITECTURE & INTERIOR DESIGN, INC. (KOB KARP)

BAHIA MAR
801 SEABREEZE BLVD.
FORT LAUDERDALE, FL 33316

LANDSCAPE
ARCHITECT


EDSA, Inc.
1512 E Broward Blvd., #10
Fort Lauderdale, Florida 33301
Tel: 954.824.3330

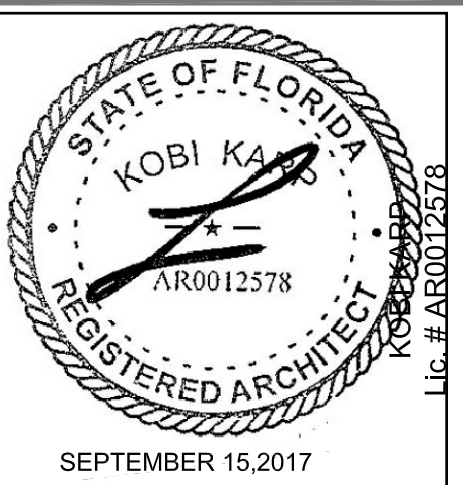

ARCHITECTURE
INTERIOR DESIGN
PLANNING

AIA ASID NCARB
2915 Biscayne Boulevard
Miami, Florida 33137
O: 305.573.1818
F: 305.573.3766

WWW.KOBKARP.COM
Lic. # AR0012578

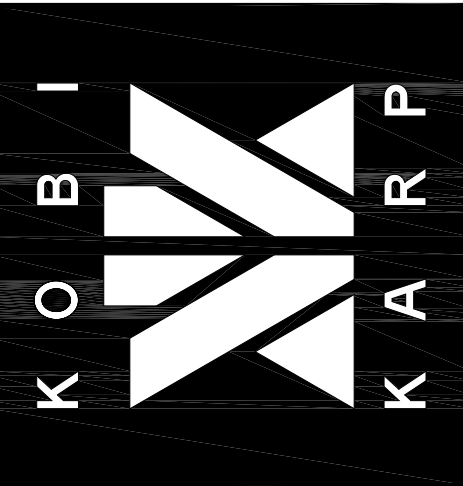


DRAWN BY: MC / AR / JPR / AM
CHECKED BY: AR
DATE: 09/15/2017

ENLARGED
LEVEL 2
FLOOR PLAN
EAST


A3.23

1512 E Broward Blvd. #110
Fort Lauderdale, Florida 33301
Tel: 954.524.3330

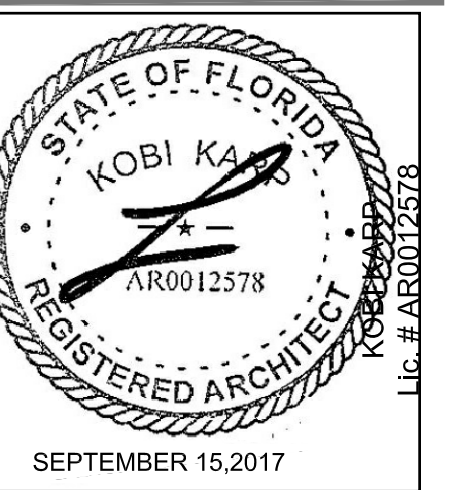


AIA ASID NCARB
2915 Biscayne Boulevard
Suite 200

Miami, Florida 33137
O: 305.573.1818
F: 305.573.3766
WWW.KOBIKARP.COM

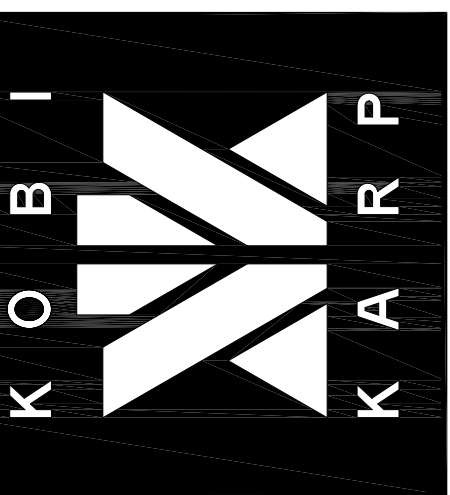


DATE: 09/15/2017

A3.24

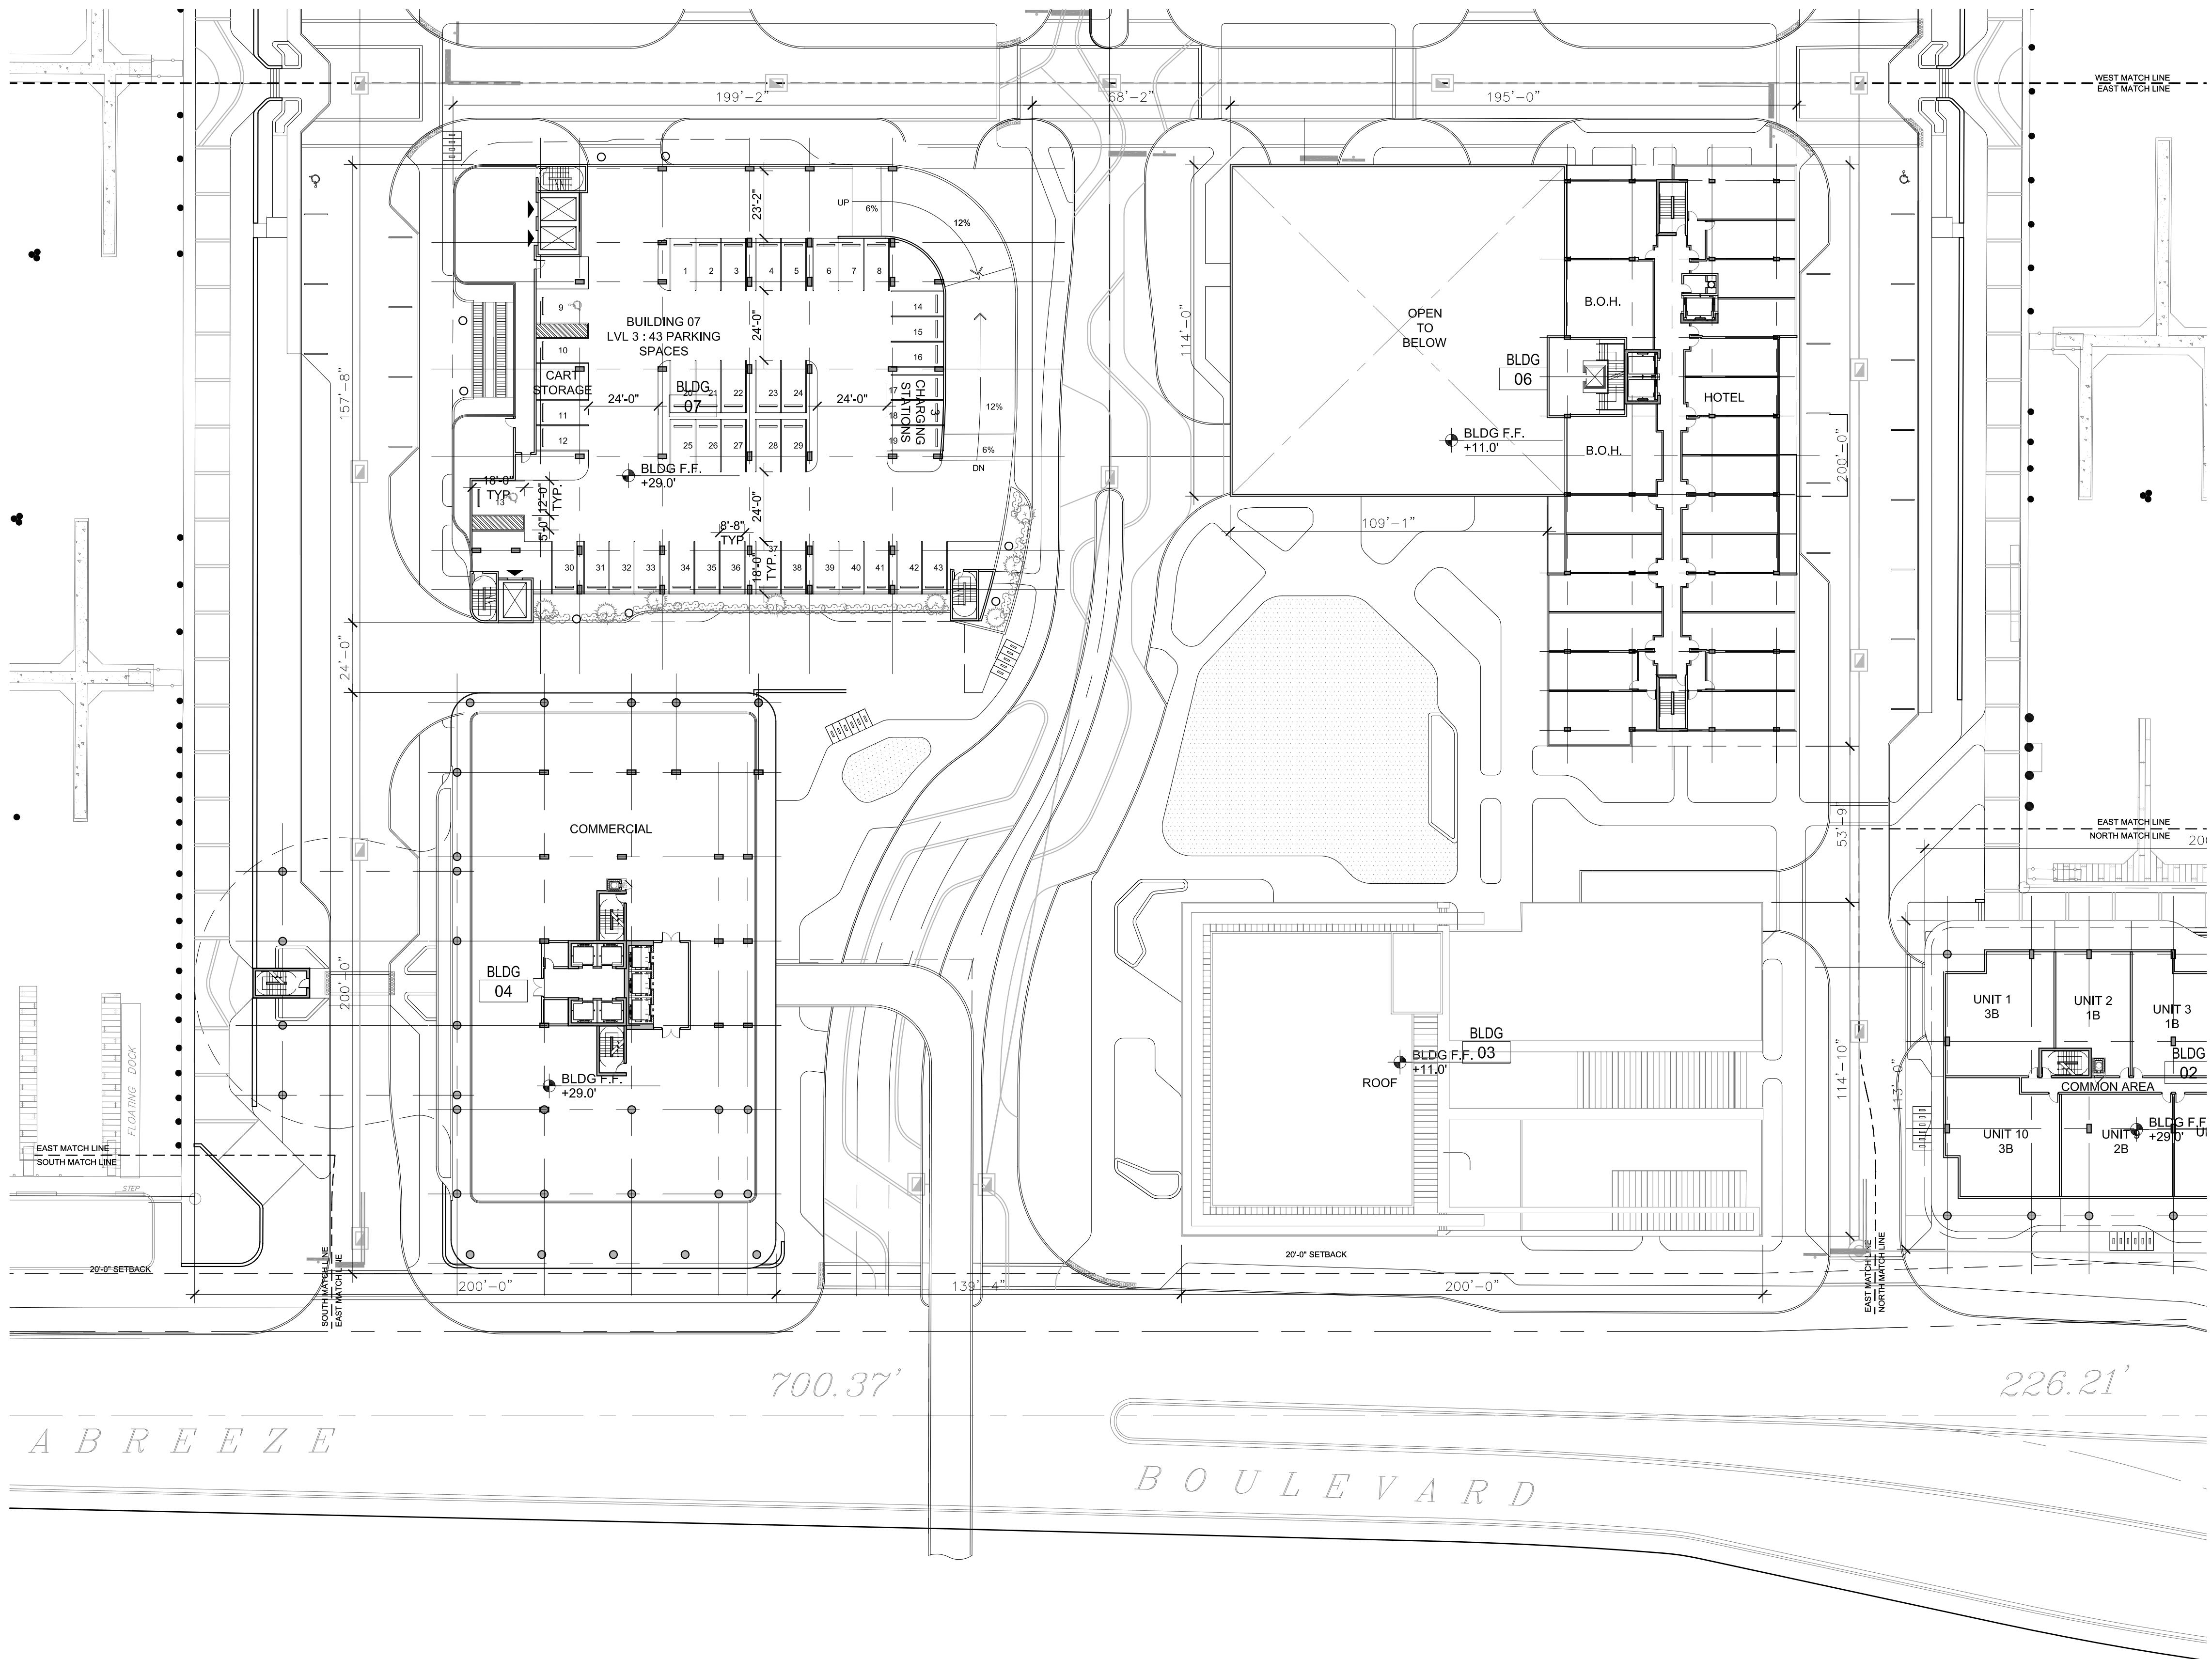

1 ENLARGED LEVEL 3 FLOOR PLAN EAST
Scale: 1/32" = 1'-0"

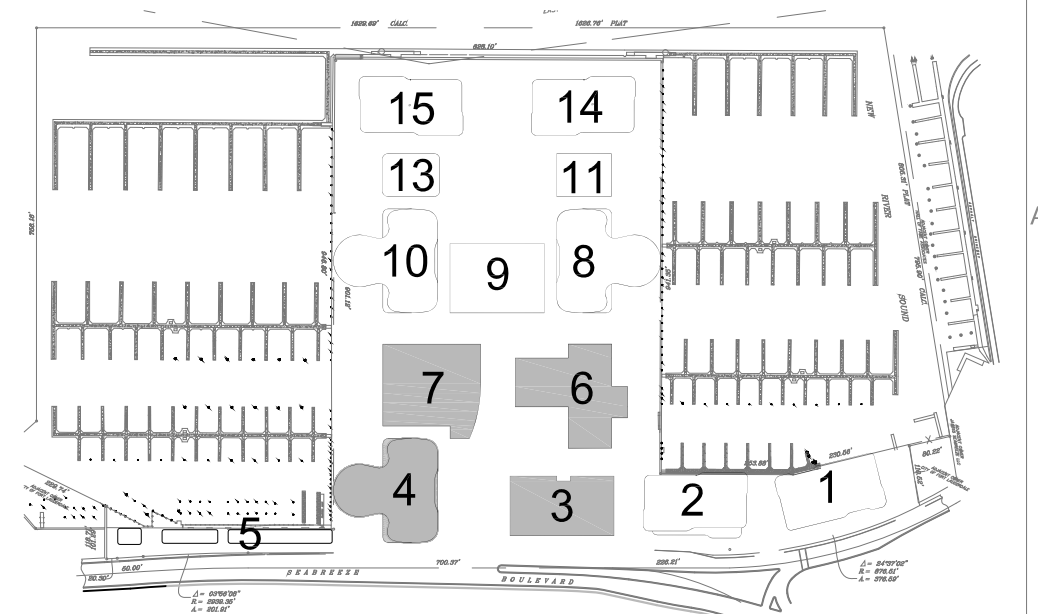

KEY PLAN



Not To Scale:

801 SEABREEZE BLVD.
FORT LAUDERDALE, FL 33316

ARCHITECT

F Broward Blvd
LDOA, III

Tel: 954.524.3330

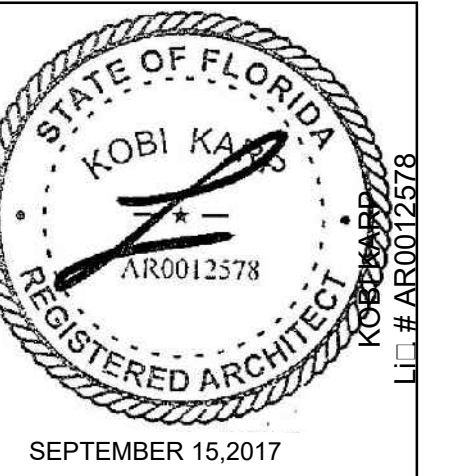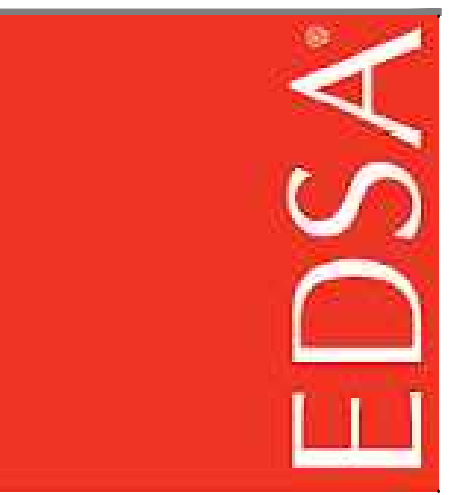


INTERIOR DESIGN PLANNING

AIA ASID NCARB
2915 Bi□ayne Boulevard

Suite 200
Miami, Florida 33137
O: 305.573.1818

Li# AR0012578

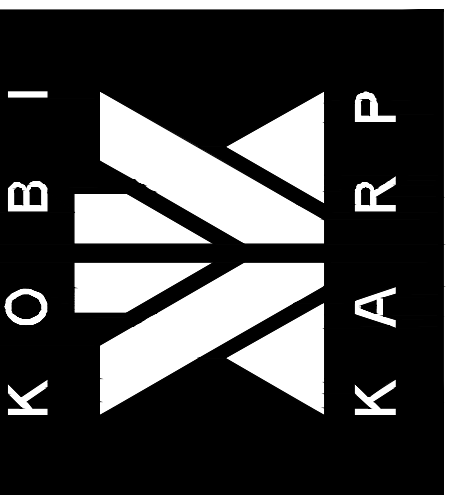


DRAWN BY: MC / AR / JPR / AM
 CHECKED BY: AR
 DATE: 09/15/2017

ENLARGED
LEVEL 4
FLOOR PLAN
EAST

A3.25

Exhibit 1d
8 of 20

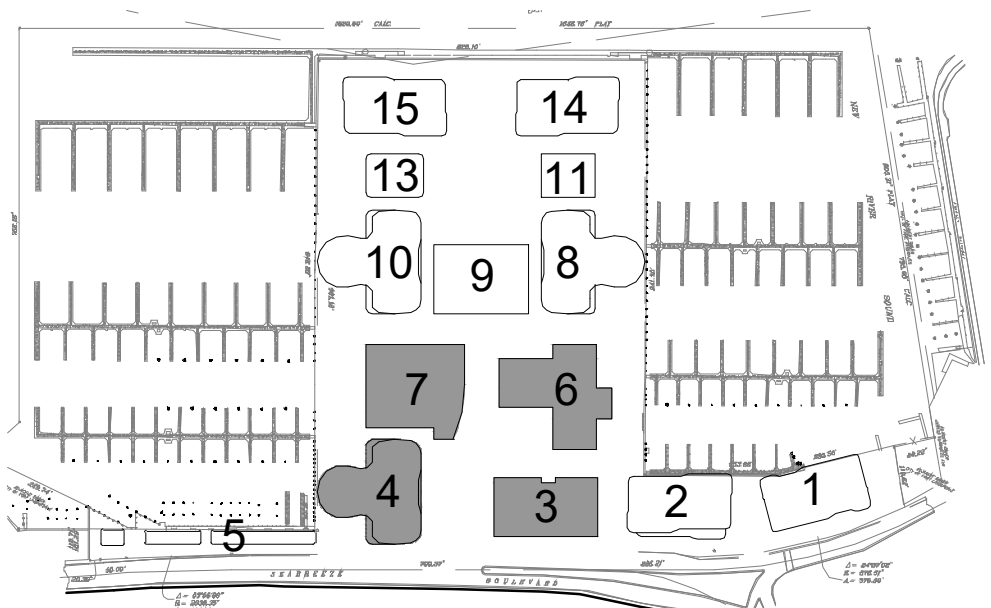


KEY PLAN

Not To Scale:

1 ENLARGED LEVEL 4 FLOOR PLAN EAST
Scale: 1/32" = 1'-0"

Scale: $1/32" = 1'-0"$

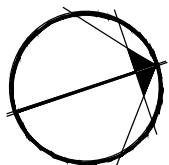


1657

ALL DRAWINGS AND WRITTEN MATERIAL APPEARING HEREIN
CONSTITUTE THE ORIGINAL AND UNPUBLISHED WORK OF KOB
KARP AIA, AND MAY NOT BE REPRODUCED, COPIED, OR OTHERWISE
TRANSMITTED IN ANY FORM OR BY ANY MEANS, WITHOUT THE EXPRESS WRITTEN CONSENT OF KOB KARP
ARCHITECTURE & INTERIOR DESIGN, INC. AIA (3/2017)

BAHIA MAR
801 SEABREEZE BLVD.
FORT LAUDERDALE, FL 33316


LANDSCAPE
ARCHITECT

EDSA, Inc.
1512 E Broward Blvd. #110
Fort Lauderdale, Florida 33301
Tel: 954-524-3330

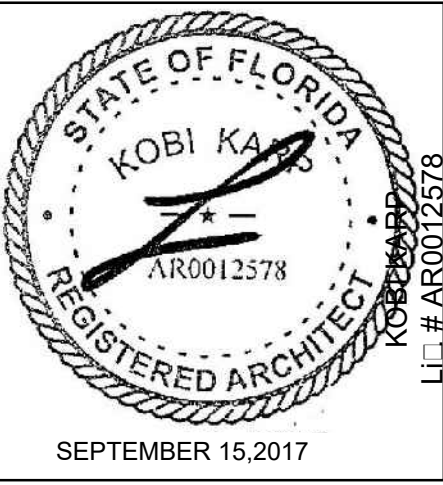

ARCHITECTURE
INTERIOR DESIGN
PLANNING


AIA ASID NCARB
2915 Blythe Boulevard
Suite 200
Miami, Florida 33137
P: 305.573.1818
F: 305.573.3766
WWW.KOBIKARP.COM
L # AR0012578

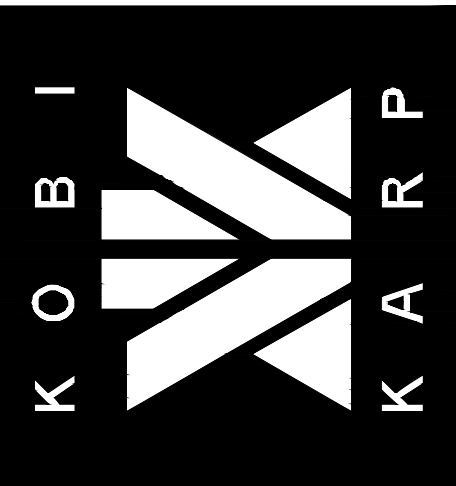


DRAWN BY: MC / AR / JPR / AM
CHECKED BY: AR
DATE: 09/15/2017

ENLARGED
LEVEL 5
FLOOR PLAN
EAST


A3.26

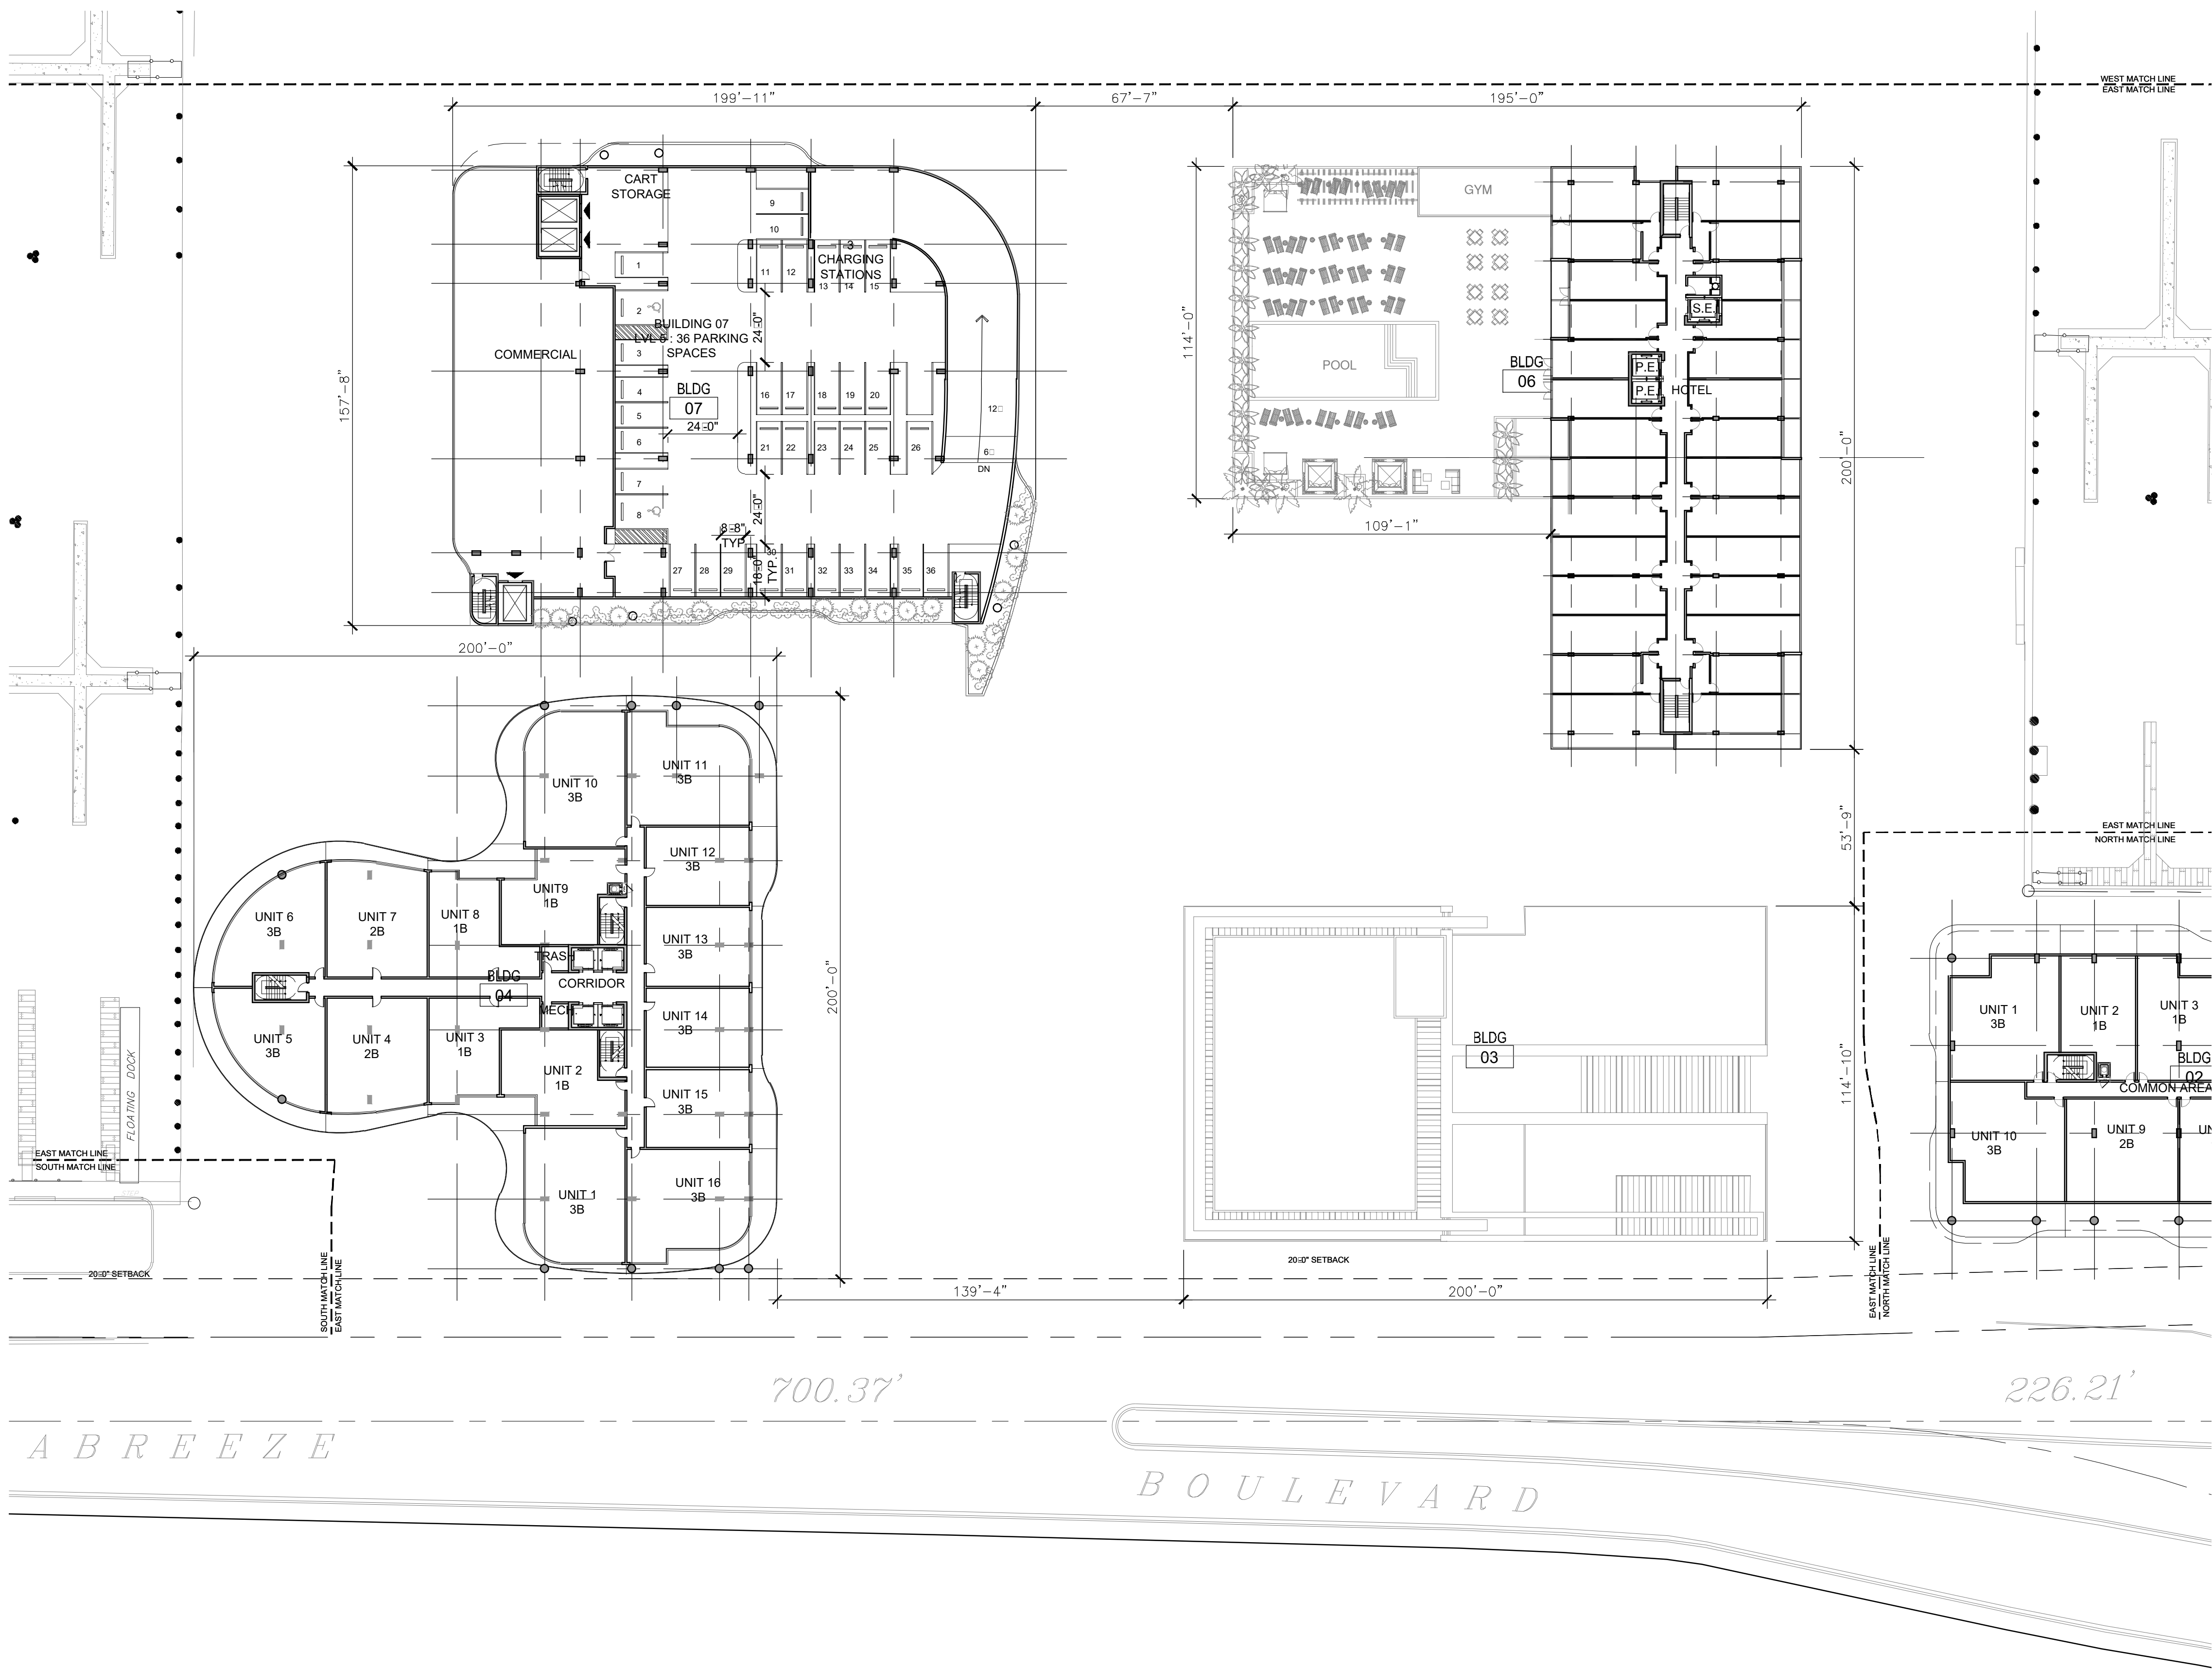


1 ENLARGED LEVEL 5 FLOOR PLAN EAST
Scale: 1/32" = 1'-0"

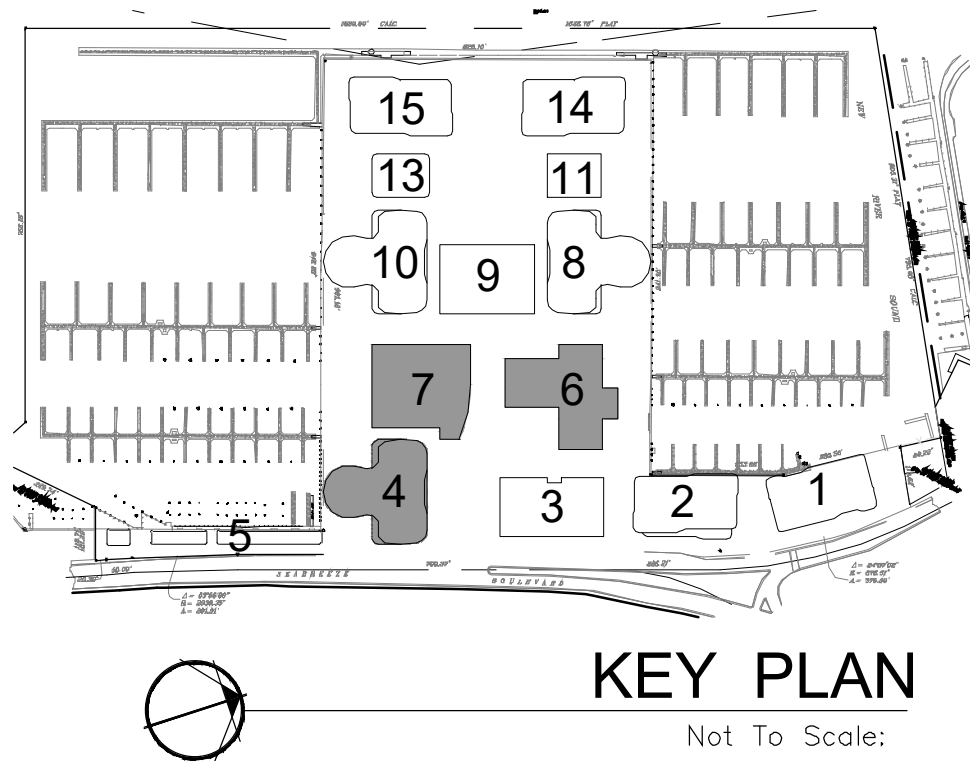

KEY PLAN
Not To Scale:

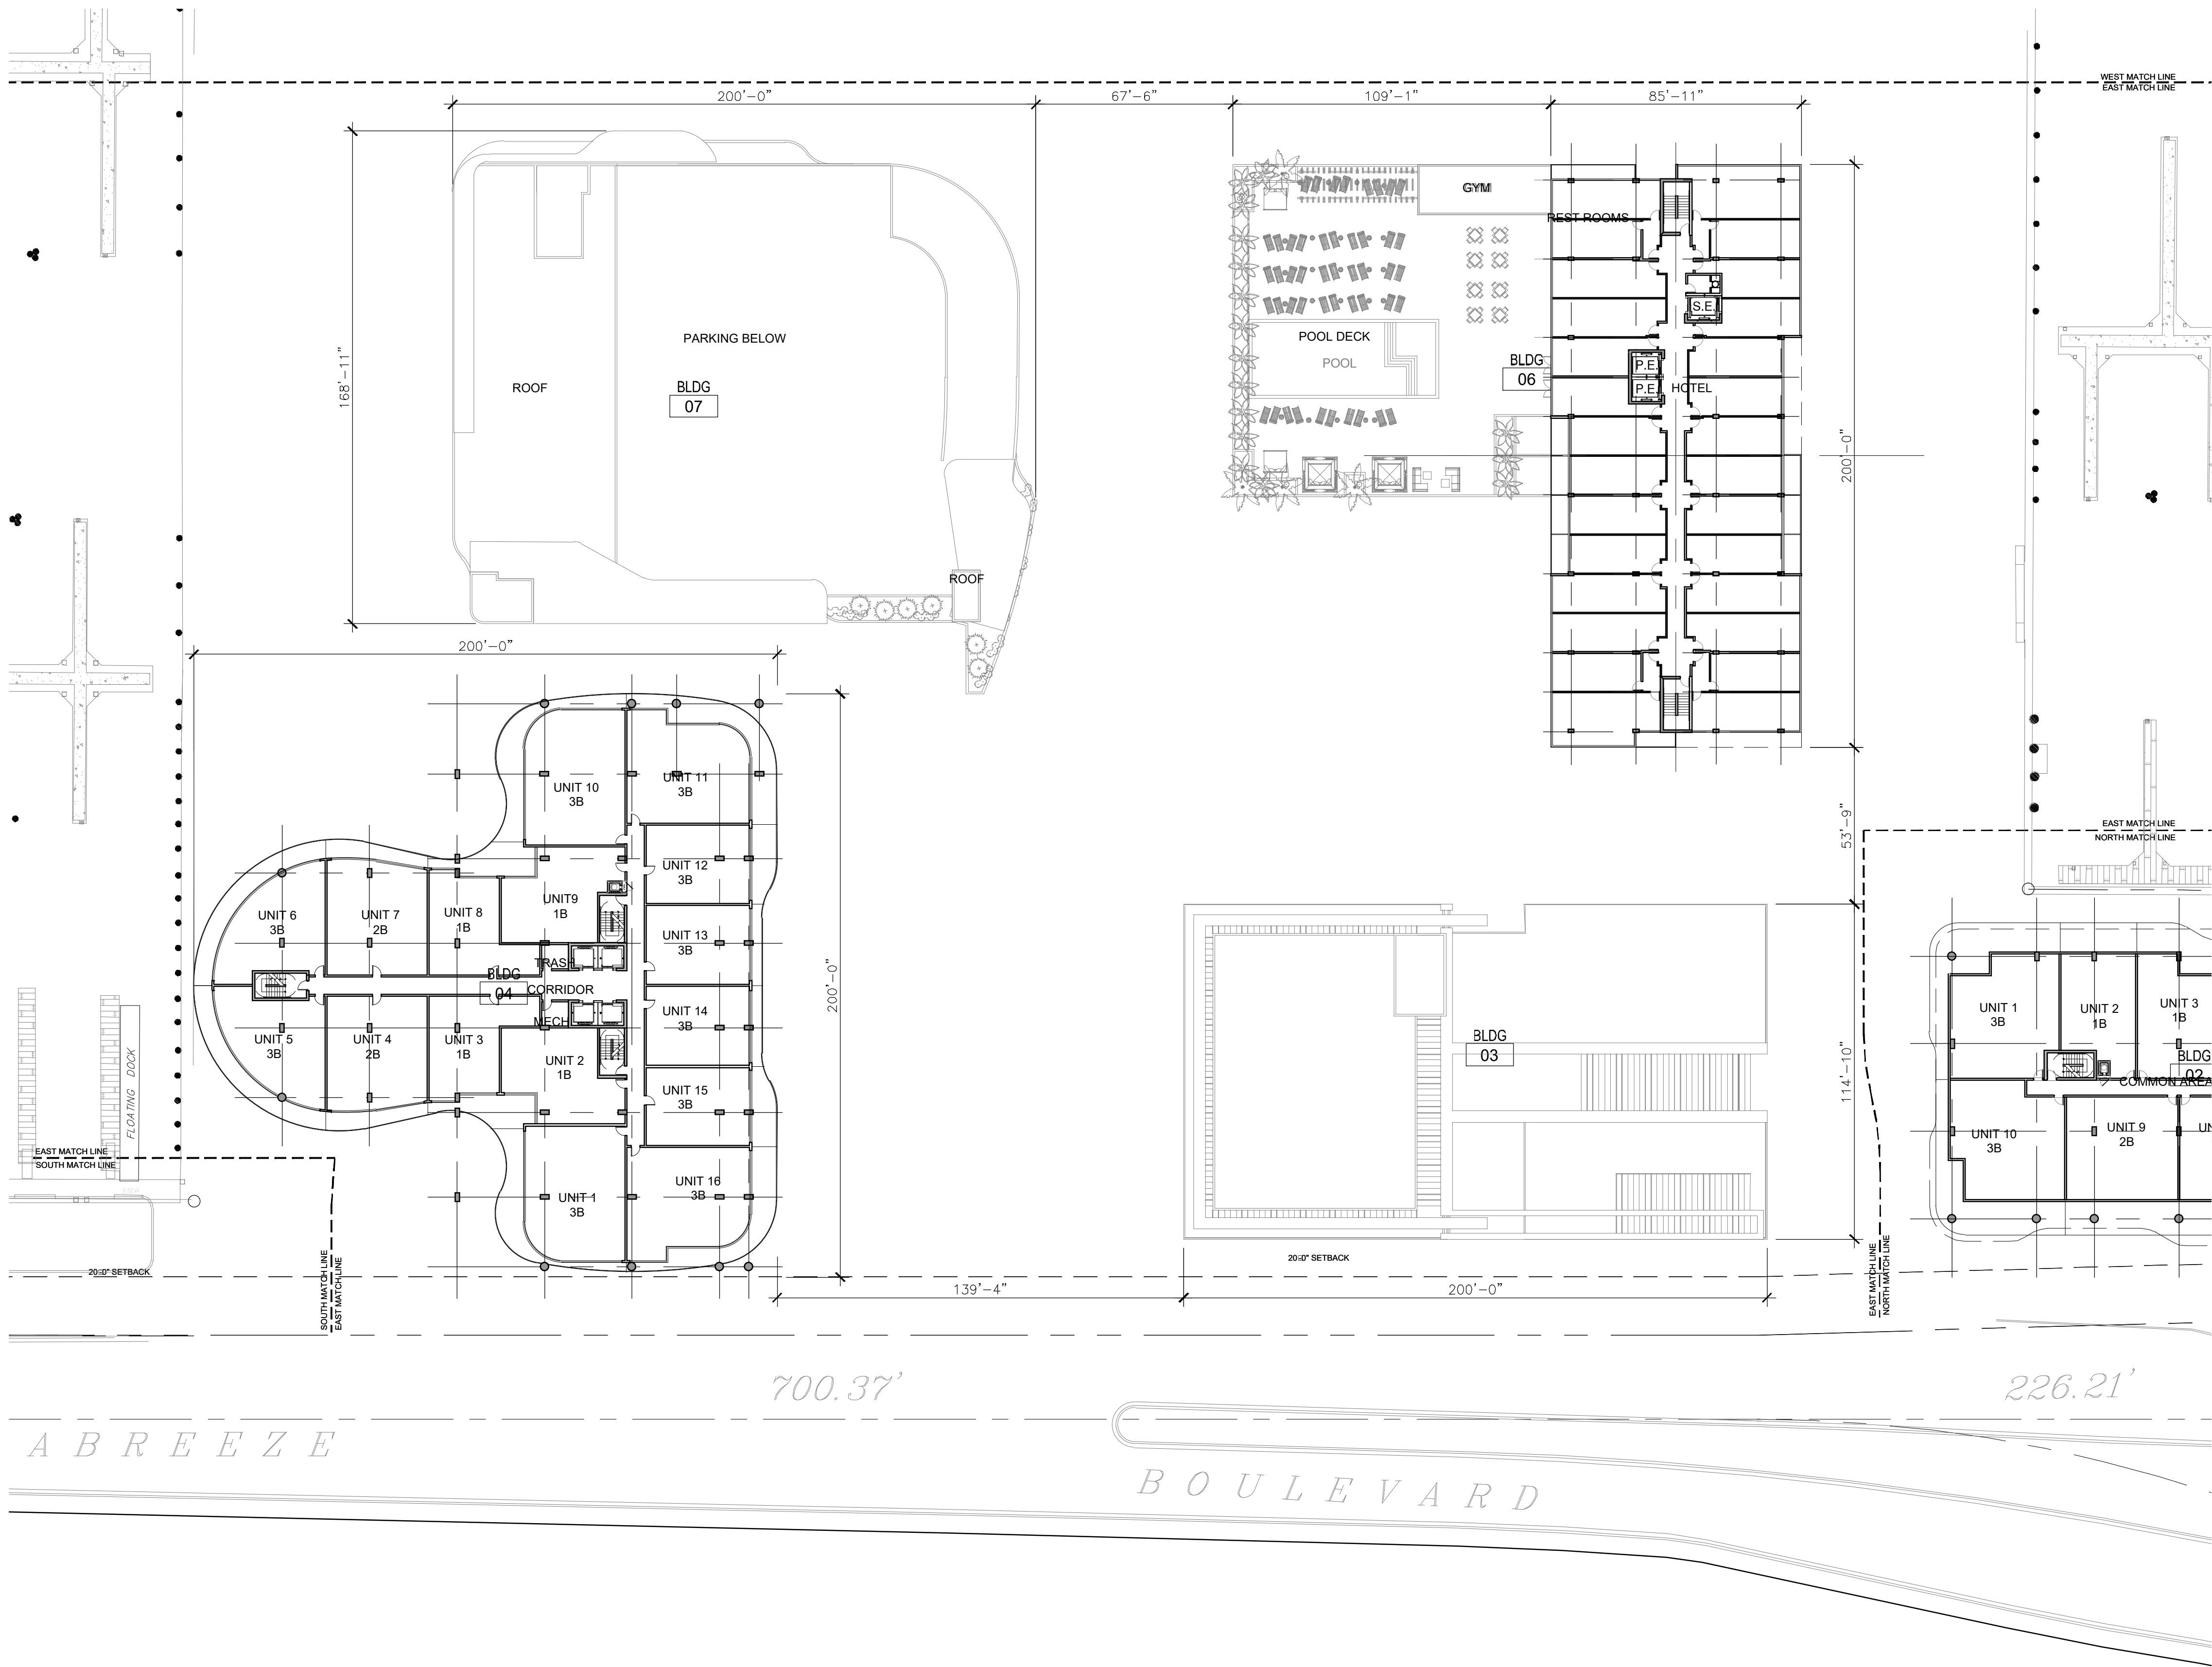

1 ENLARGED LEVEL 6-7 FLOOR PLAN EAST
Scale: 1/32" = 1'-0"

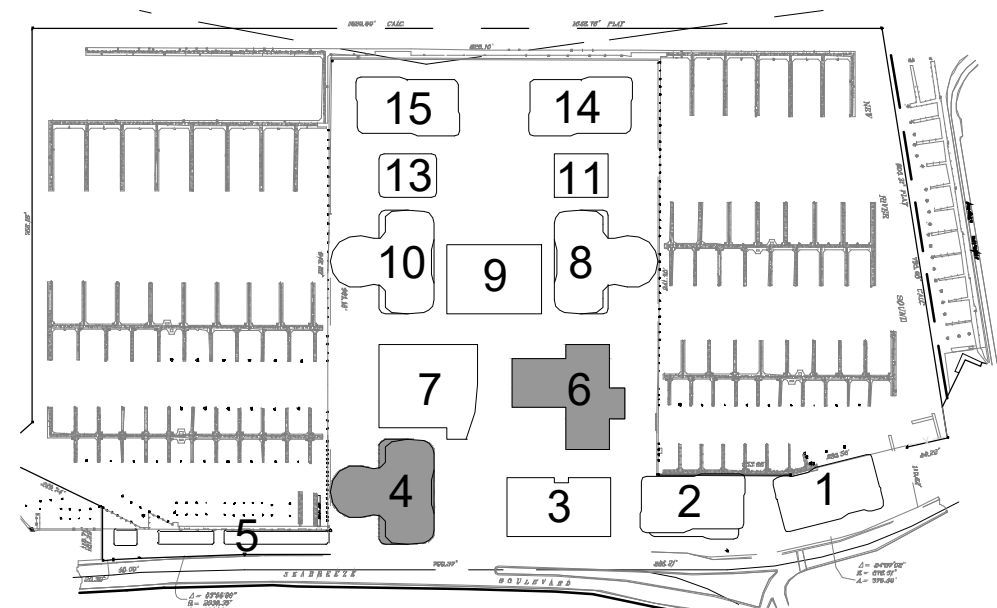

KEY PLAN
Not To Scale:

REVISIONS / SUBMISSIONS

1657

ALL DRAWINGS AND WRITTEN MATERIAL APPEARING HEREIN
CONSTITUTE THE ORIGINAL AND UNPUBLISHED WORK OF KOB
KARP AND MAY NOT BE REPRODUCED, COPIED, OR OTHERWISE
TRANSMITTED IN ANY FORM OR BY ANY MEANS, WITHOUT THE EXPRESS WRITTEN CONSENT OF KOB KARP
ARCHITECTURE & INTERIOR DESIGN, INC. AIA (3/2017)

BAHIA MAR
801 SEABREEZE BLVD.
FORT LAUDERDALE, FL 33316

LANDSCAPE
ARCHITECT

EDSA, Inc.

1512 E Broward Blvd. #110
Fort Lauderdale, Florida 33301
Tel: 954.524.3330




ARCHITECTURE
INTERIOR DESIGN
PLANNING

AIA ASID NCARB

2915 Blythe Boulevard
Suite 200
Miami, Florida 33137
P: 305.573.1818
F: 305.573.3766

WWW.KOBKARP.COM


LI # AR0012578

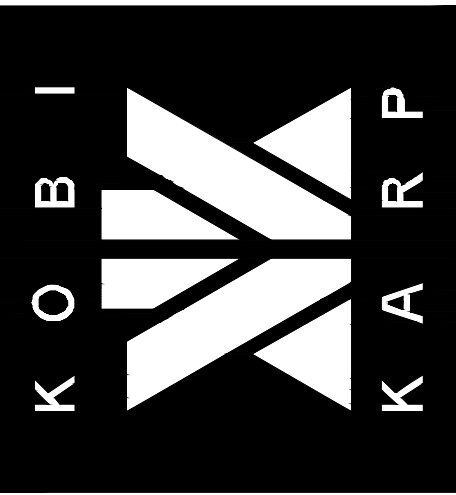


DRAWN BY: MC / AR / JPR / AM
CHECKED BY: AR
DATE: 09/15/2017

ENLARGED
LEVEL 6-7
FLOOR PLAN
EAST

A3.27

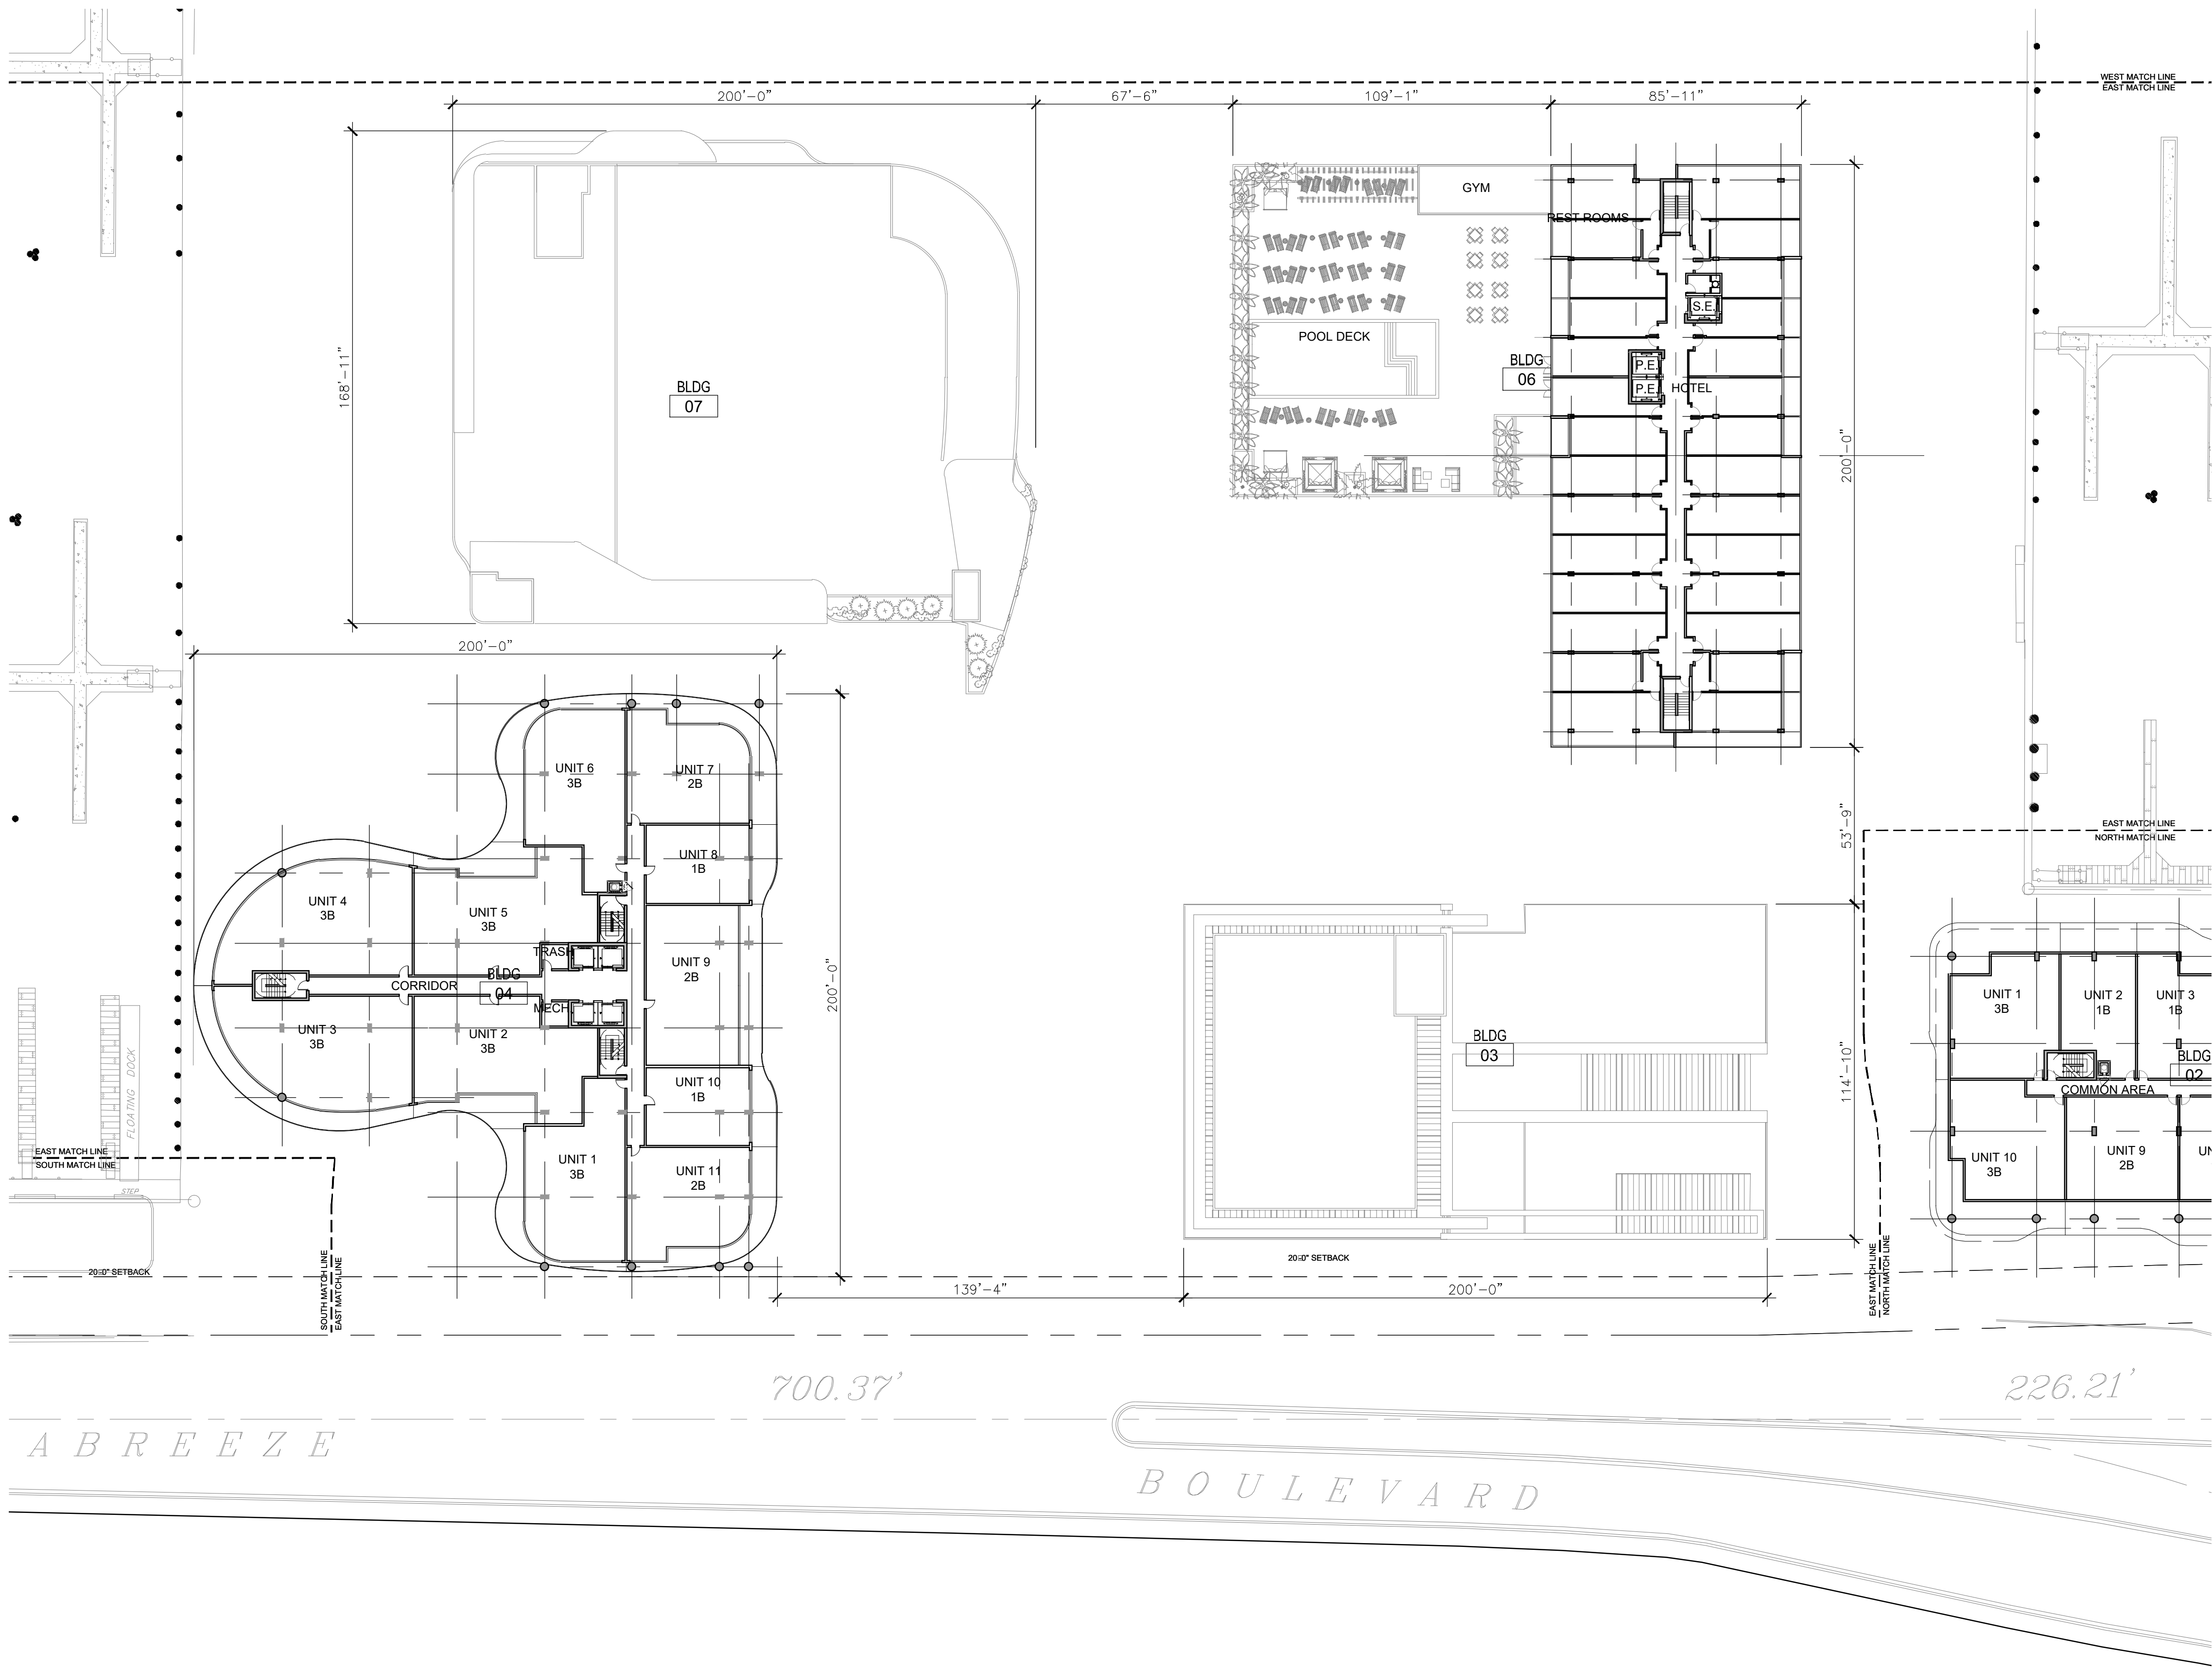

1 ENLARGED LEVEL 8 FLOOR PLAN EAST
Scale: 1/32" = 1'-0"

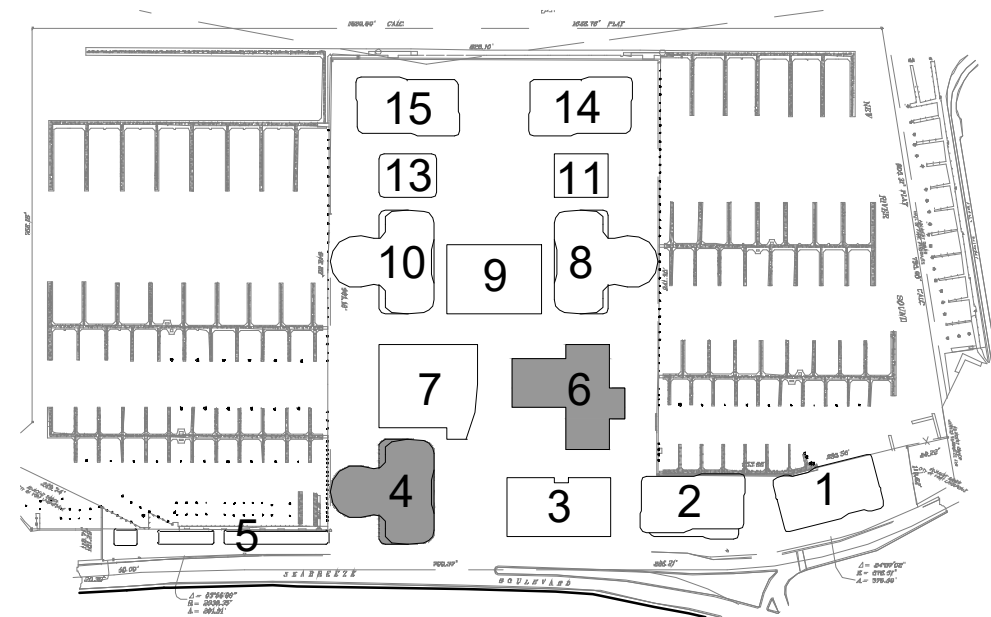

KEY PLAN
Not To Scale:

REVISIONS / SUBMISSIONS


1657

ALL DRAWINGS AND WRITTEN MATERIAL APPEARING HEREIN
CONSTITUTE THE ORIGINAL AND UNPUBLISHED WORK OF KOB
KARP AIA, AND MAY NOT BE REPRODUCED, COPIED, OR DISSEMIN
WITHOUT THE EXPRESS WRITTEN CONSENT OF KOB KARP
ARCHITECTURE & INTERIOR DESIGN, INC. AIA (3/2017)

BAHIA MAR
801 SEABREEZE BLVD.
FORT LAUDERDALE, FL 33316


LANDSCAPE
ARCHITECT

EDSA, Inc.
1512 E Broward Blvd. #110
Fort Lauderdale, Florida 33301
Tel: 954.524.3330

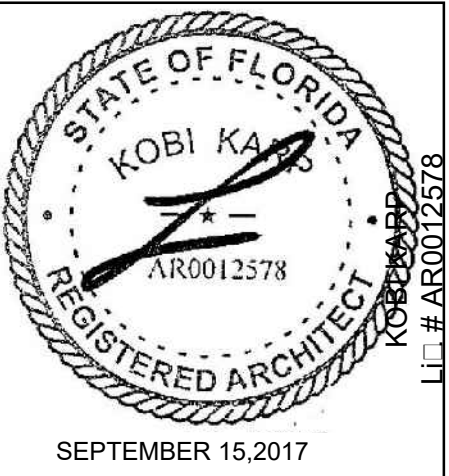

ARCHITECTURE
INTERIOR DESIGN
PLANNING


AIA ASID NCARB
2915 Biscayne Boulevard
Suite 200
Miami, Florida 33137
P: 305.573.1818
F: 305.573.3766
WWW.KOBKARP.COM
L: # AR0012578

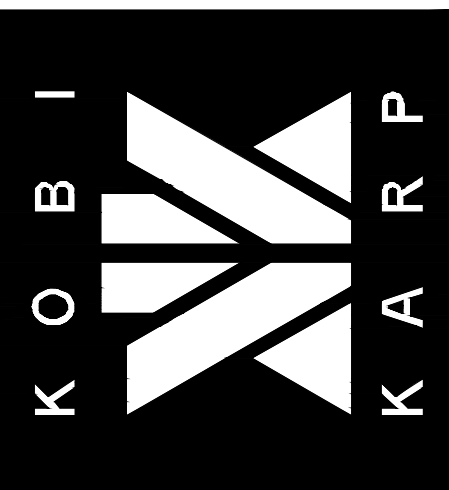


DRAWN BY: MC / AR / JPR / AM
CHECKED BY: AR
DATE: 09/15/2017

ENLARGED
LEVEL 8
FLOOR PLAN
EAST

A3.28

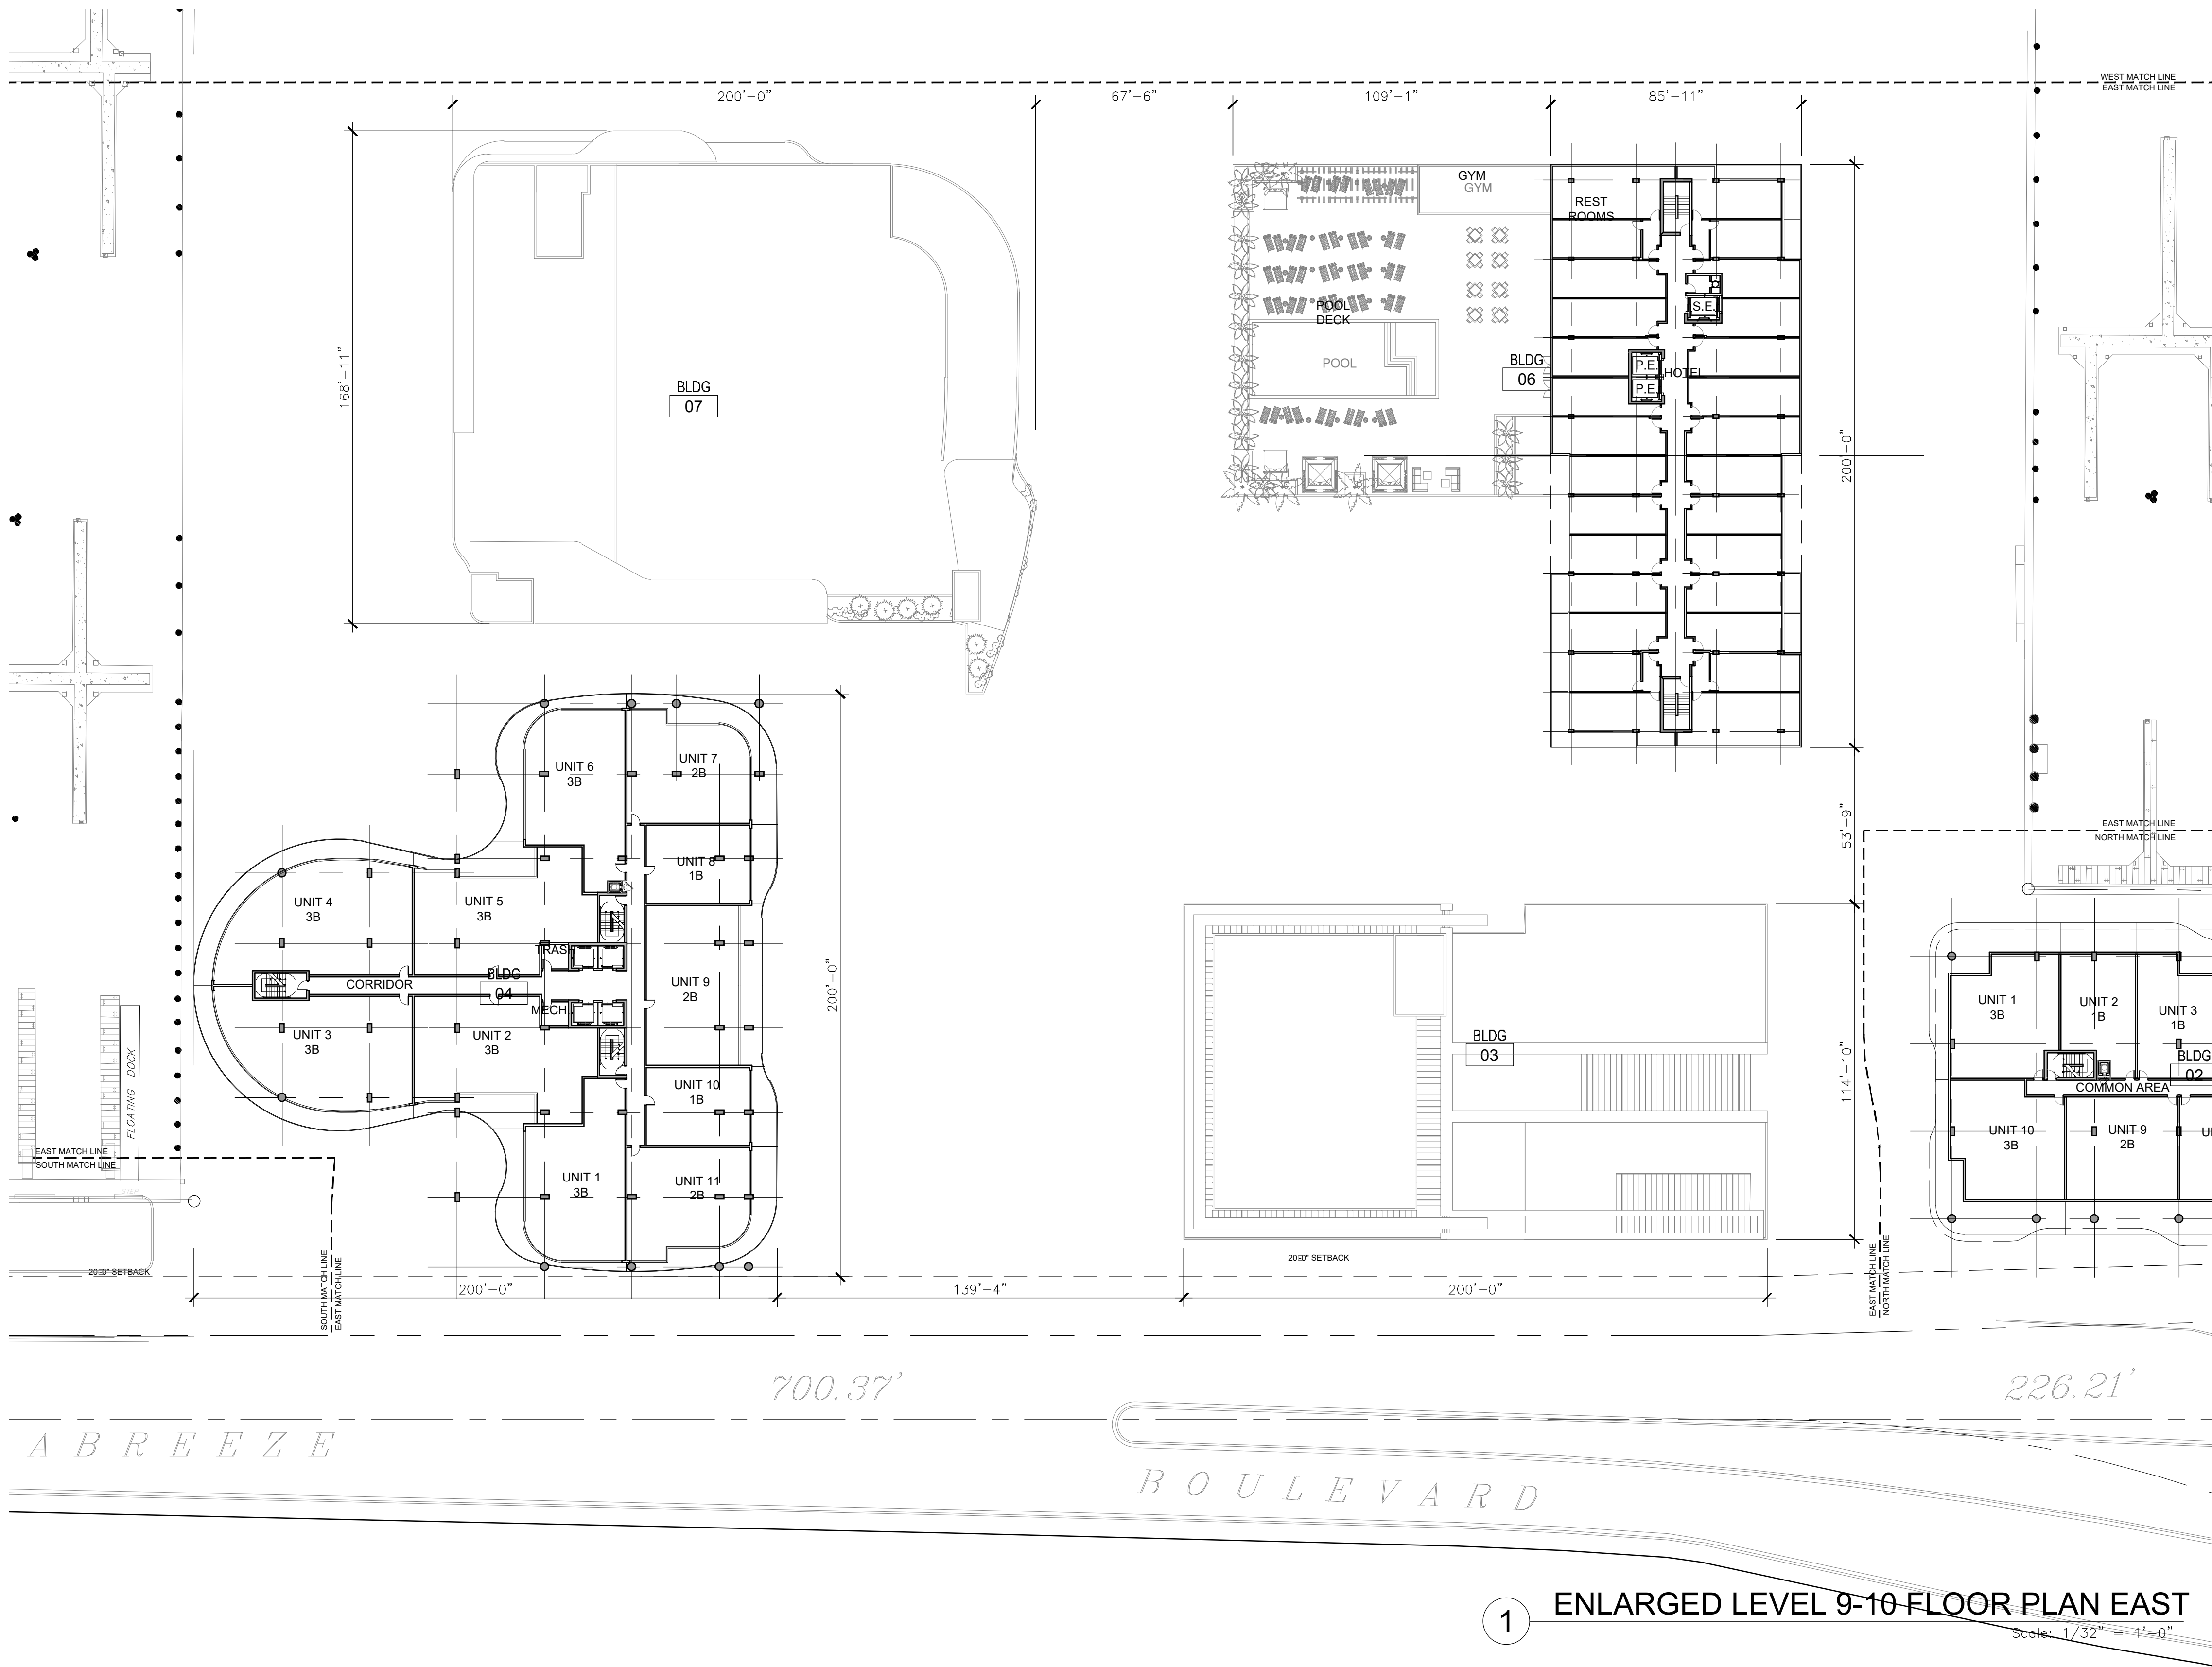

1 ENLARGED LEVEL 9-10 FLOOR PLAN EAST
Scale: 1/32" = 1'-0"

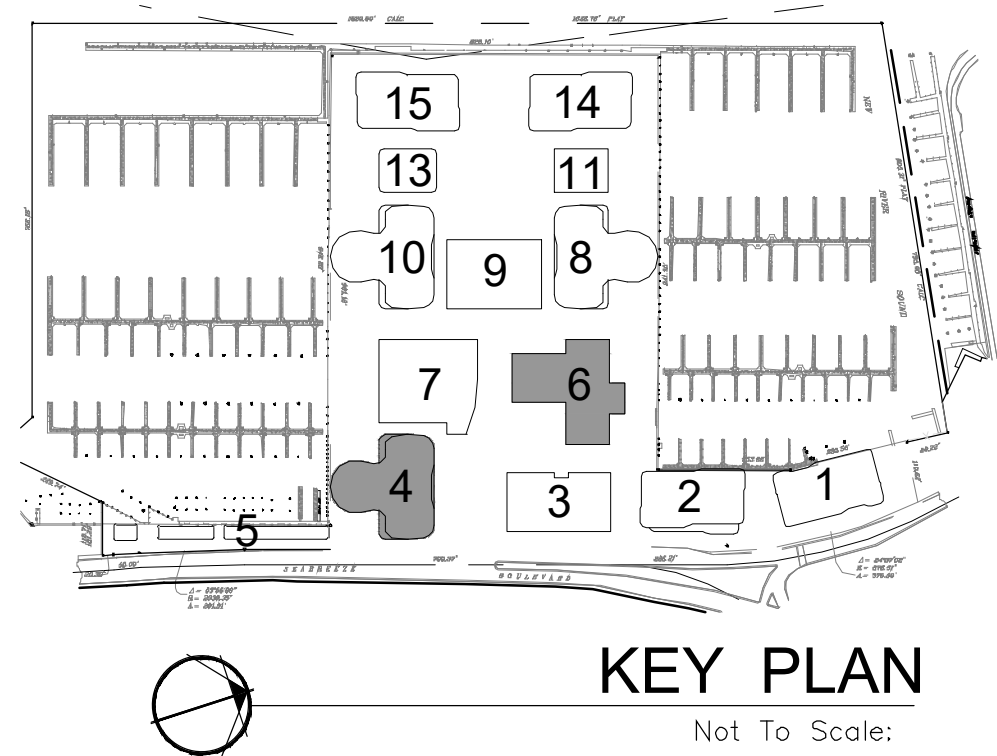

REVISIONS / SUBMISSIONS


1657

ALL DRAWINGS AND WRITTEN MATERIAL APPEARING HEREIN
CONSTITUTE THE ORIGINAL AND UNPUBLISHED WORK OF KOB
KARP, INC. AND MAY NOT BE REPRODUCED, COPIED, OR DISSEMINATED
WITHOUT THE EXPRESS WRITTEN CONSENT OF KOB KARP
ARCHITECTURE & INTERIOR DESIGN, INC. AIA (3/1/2017)

BAHIA MAR
801 SEABREEZE BLVD.
FORT LAUDERDALE, FL 33316


LANDSCAPE
ARCHITECT

EDSA, Inc.
1512 E Broward Blvd., #110
Fort Lauderdale, Florida 33301
Tel: 954.524.3330

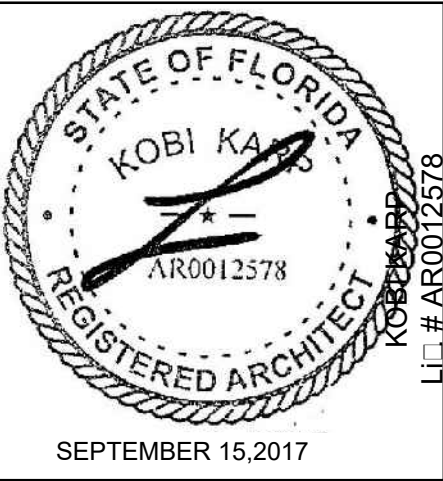

ARCHITECTURE
INTERIOR DESIGN
PLANNING


AIA ASID NCARB
2915 Biscayne Boulevard
Suite 200
Miami, Florida 33137
P: 305.573.1818
F: 305.573.3766
WWW.KOBKARP.COM
L: # AR0012578

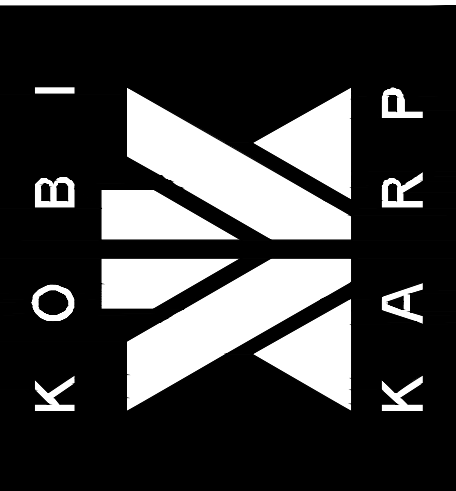


DRAWN BY: MC / AR / JPR / AM
CHECKED BY: AR
DATE: 09/15/2017

ENLARGED
LEVEL 9-10
FLOOR PLAN
EAST

A3.29

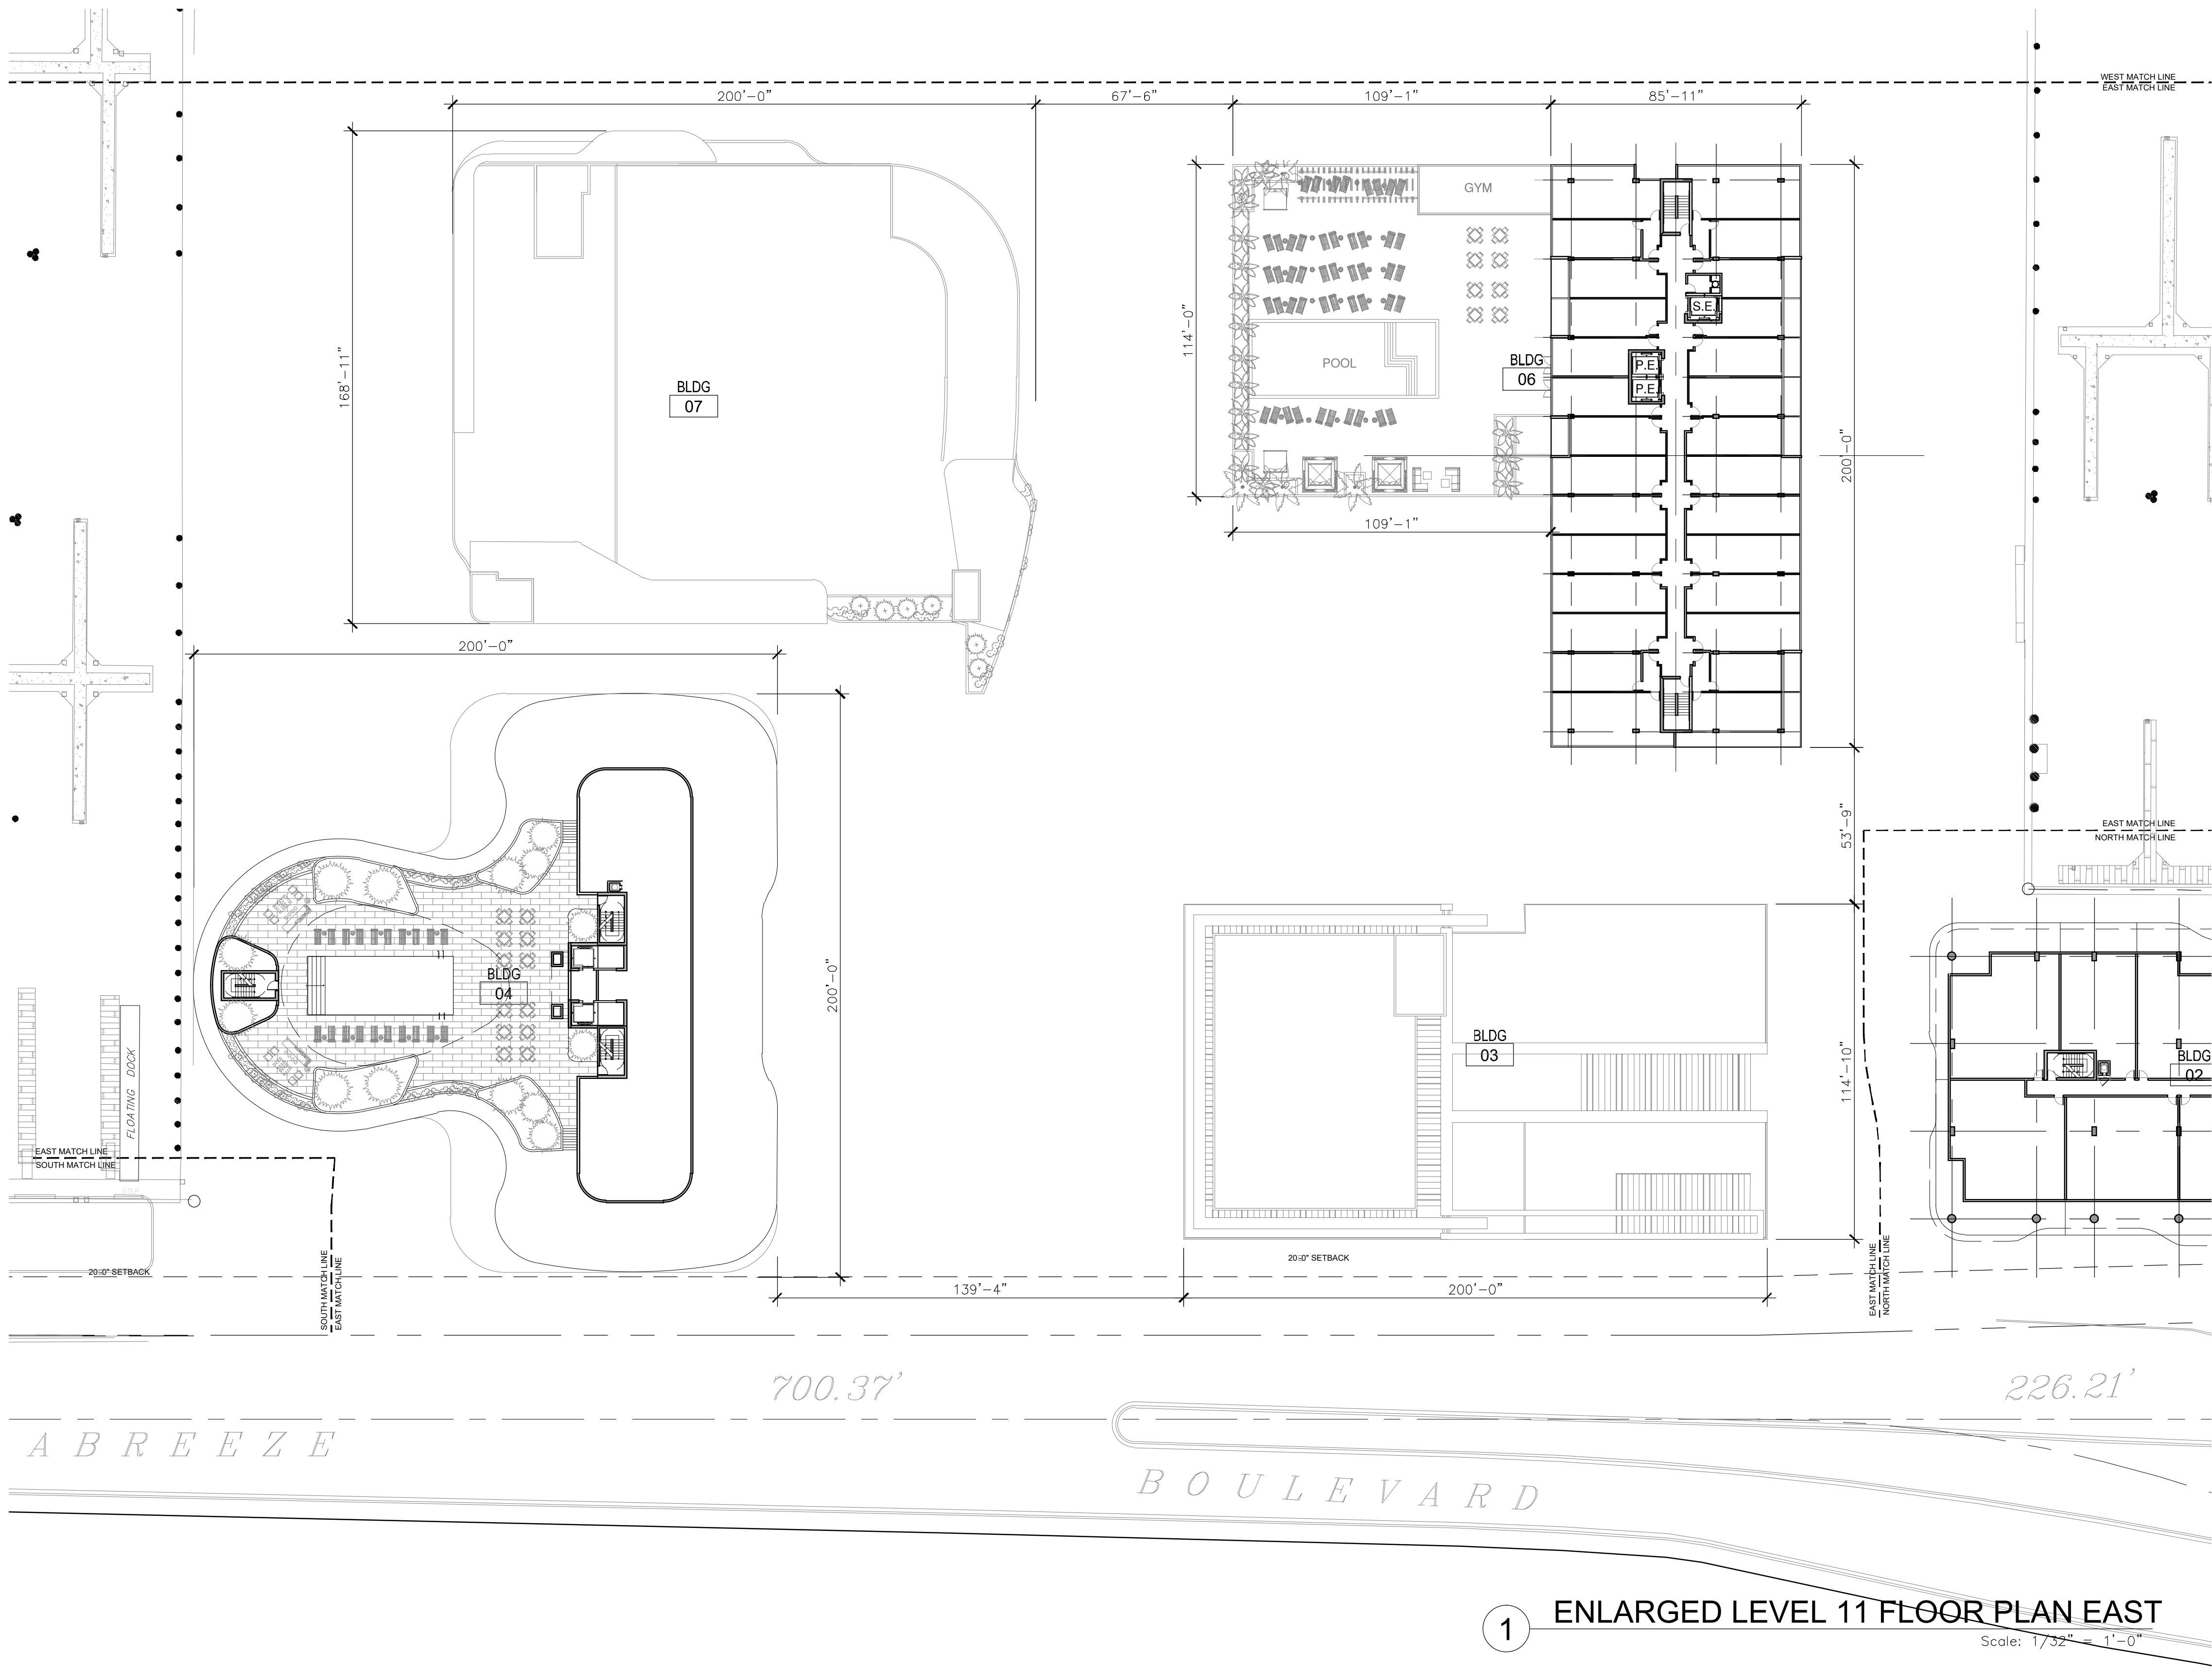

1 ENLARGED LEVEL 11 FLOOR PLAN EAST
Scale: 1/32" = 1'-0"

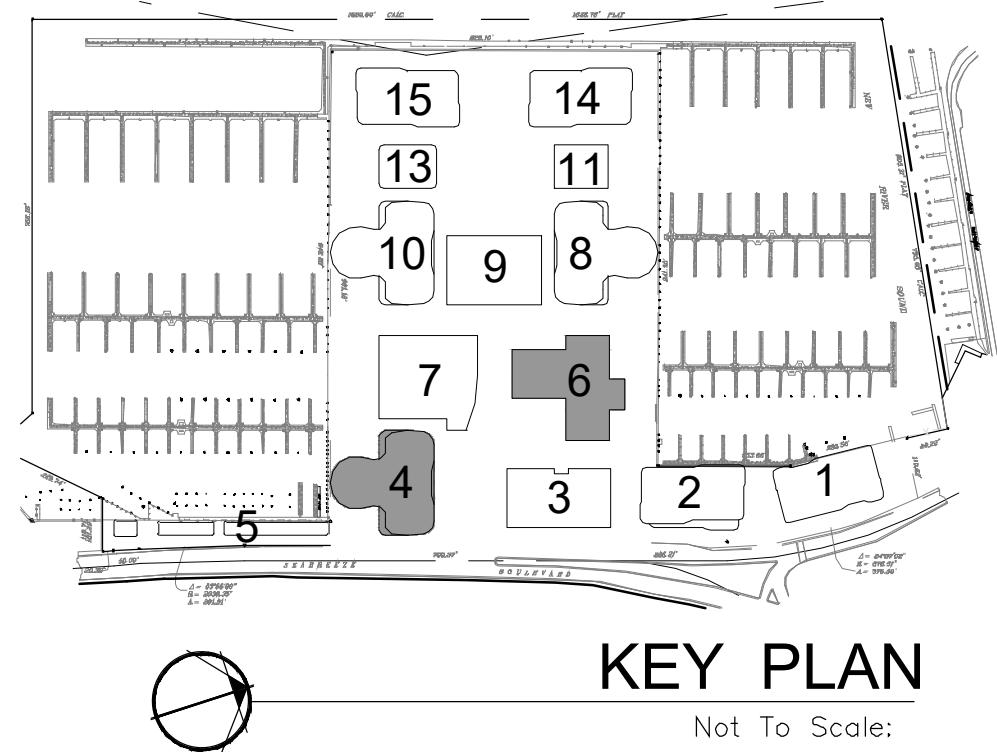

KEY PLAN
Not To Scale:

REVISIONS / SUBMISSIONS


1657

ALL DRAWINGS AND WRITTEN MATERIAL APPEARING HEREIN
CONSTITUTE THE ORIGINAL AND UNPUBLISHED WORK OF KOB
KARP AIA, AND MAY NOT BE REPRODUCED, COPIED, OR OTHERWISE
TRANSMITTED IN ANY FORM OR BY ANY MEANS, WITHOUT THE EXPRESS WRITTEN CONSENT OF KOB KARP
ARCHITECTURE & INTERIOR DESIGN, INC. AIA (3/2017)...

BAHIA MAR
801 SEABREEZE BLVD.
FORT LAUDERDALE, FL 33316


LANDSCAPE
ARCHITECT

EDSA, Inc.
1512 E Broward Blvd. #110
Fort Lauderdale, Florida 33301
Tel: 954.524.3330

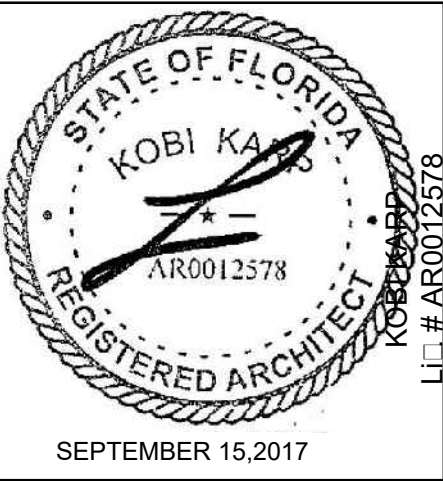

ARCHITECTURE
INTERIOR DESIGN
PLANNING

AIA ASID NCARB
2915 Biltmore Boulevard
Suite 200
Miami, Florida 33137
P: 305.573.1818
F: 305.573.3766
WWW.KOBKARP.COM
L: # AR0012578

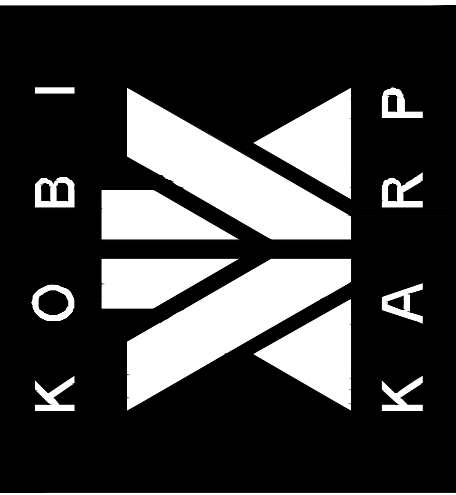

DRAWN BY: MC / AR / JPR / AM
CHECKED BY: AR
DATE: 09/15/2017

ENLARGED
LEVEL 11
FLOOR PLAN
EAST

A3.30


1657

ALL DRAWINGS AND WRITTEN MATERIAL APPEARING HEREIN
CONSTITUTE THE ORIGINAL AND UNPUBLISHED WORK OF KOB
KARP, INC. AND MAY NOT BE REPRODUCED, COPIED, OR ENCLOSED
WITHOUT THE EXPRESS WRITTEN CONSENT OF KOB KARP
ARCHITECTURE & INTERIOR DESIGN, INC. (AIA, AIA 01/2017)


BAHIA MAR
801 SEABREEZE BLVD.
FORT LAUDERDALE, FL 33316

LANDSCAPE
ARCHITECT

EDSA, Inc.
1512 E Broward Blvd., #10
Fort Lauderdale, Florida 33301
Tel: 954.824.3330

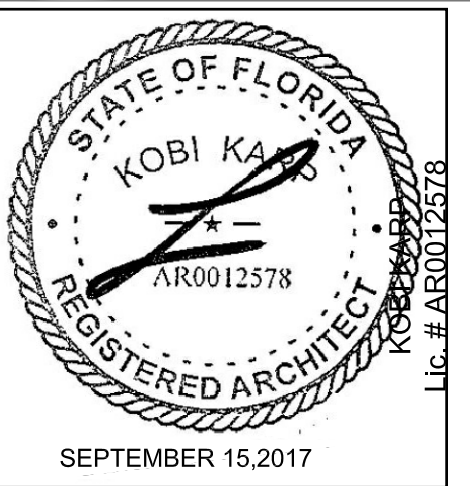


ARCHITECTURE
INTERIOR DESIGN
PLANNING
AIA ASID NCARB
2915 Biscayne Boulevard
Miami, Florida 33137
O: 305.573.1818
F: 305.573.3766
WWW.KOBKARP.COM
Lic. # AR0012578

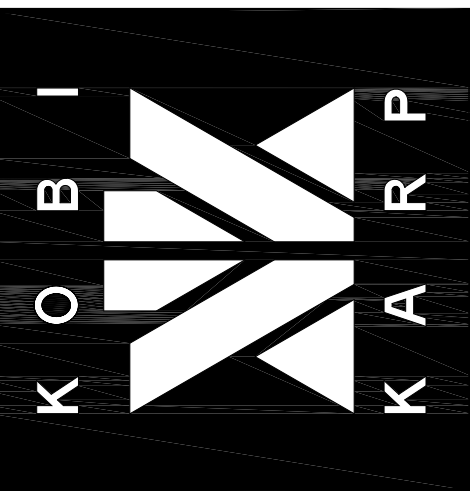


DRAWN BY: MC / AR / JPR / AM
CHECKED BY: AR
DATE: 09/15/2017

ENLARGED LEVEL
1, & 2 FLOOR PLAN
NORTH


A3.41

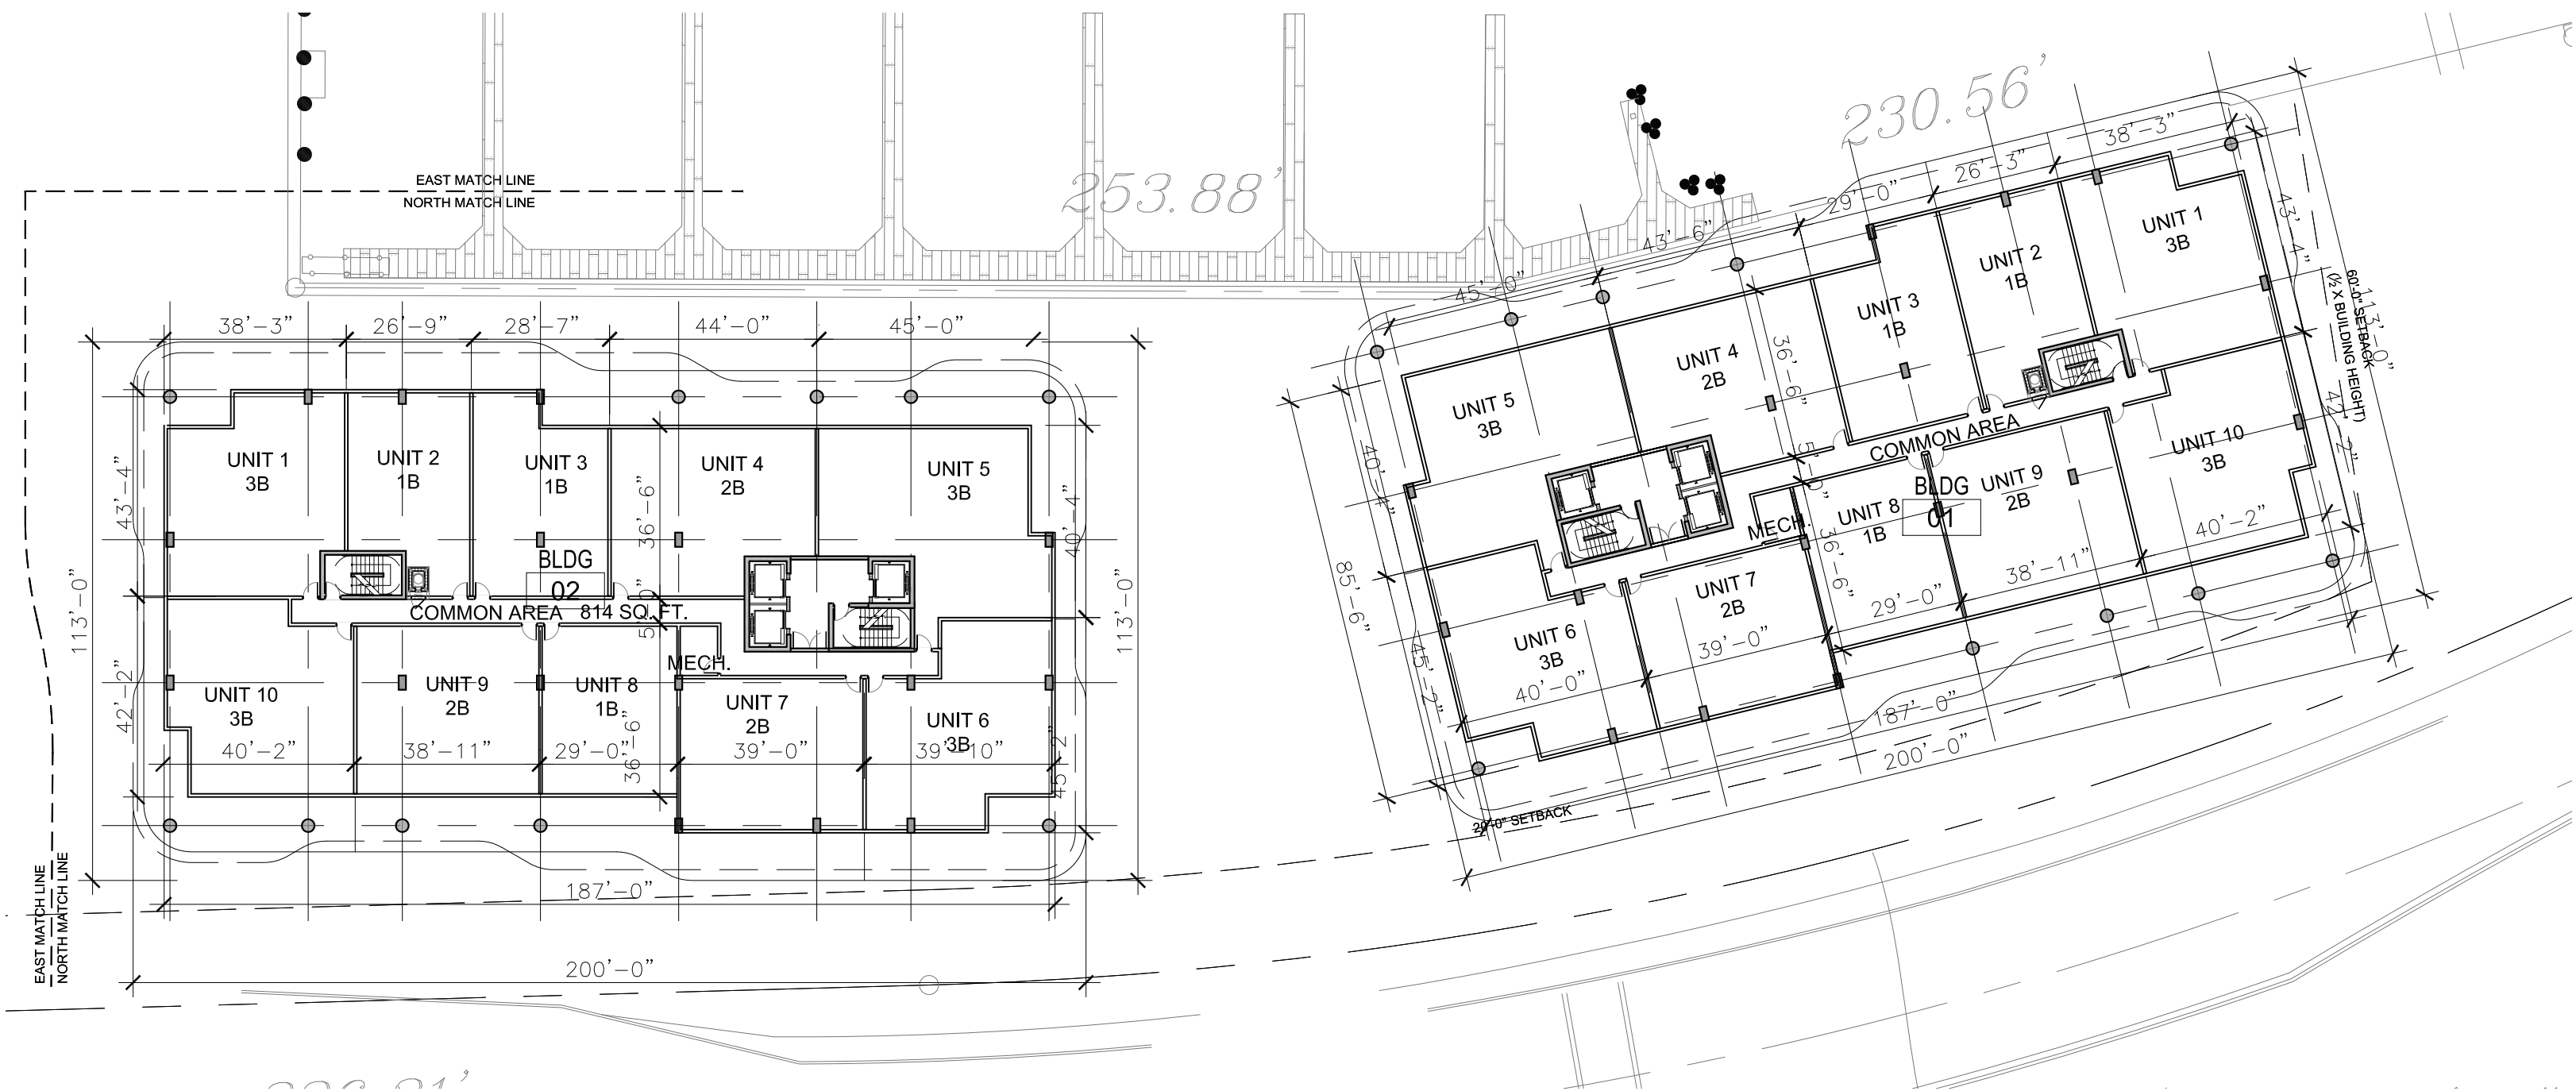

2 ENLARGED LEVEL 2 FLOOR PLAN NORTH
Scale: 1/32" = 1'-0"

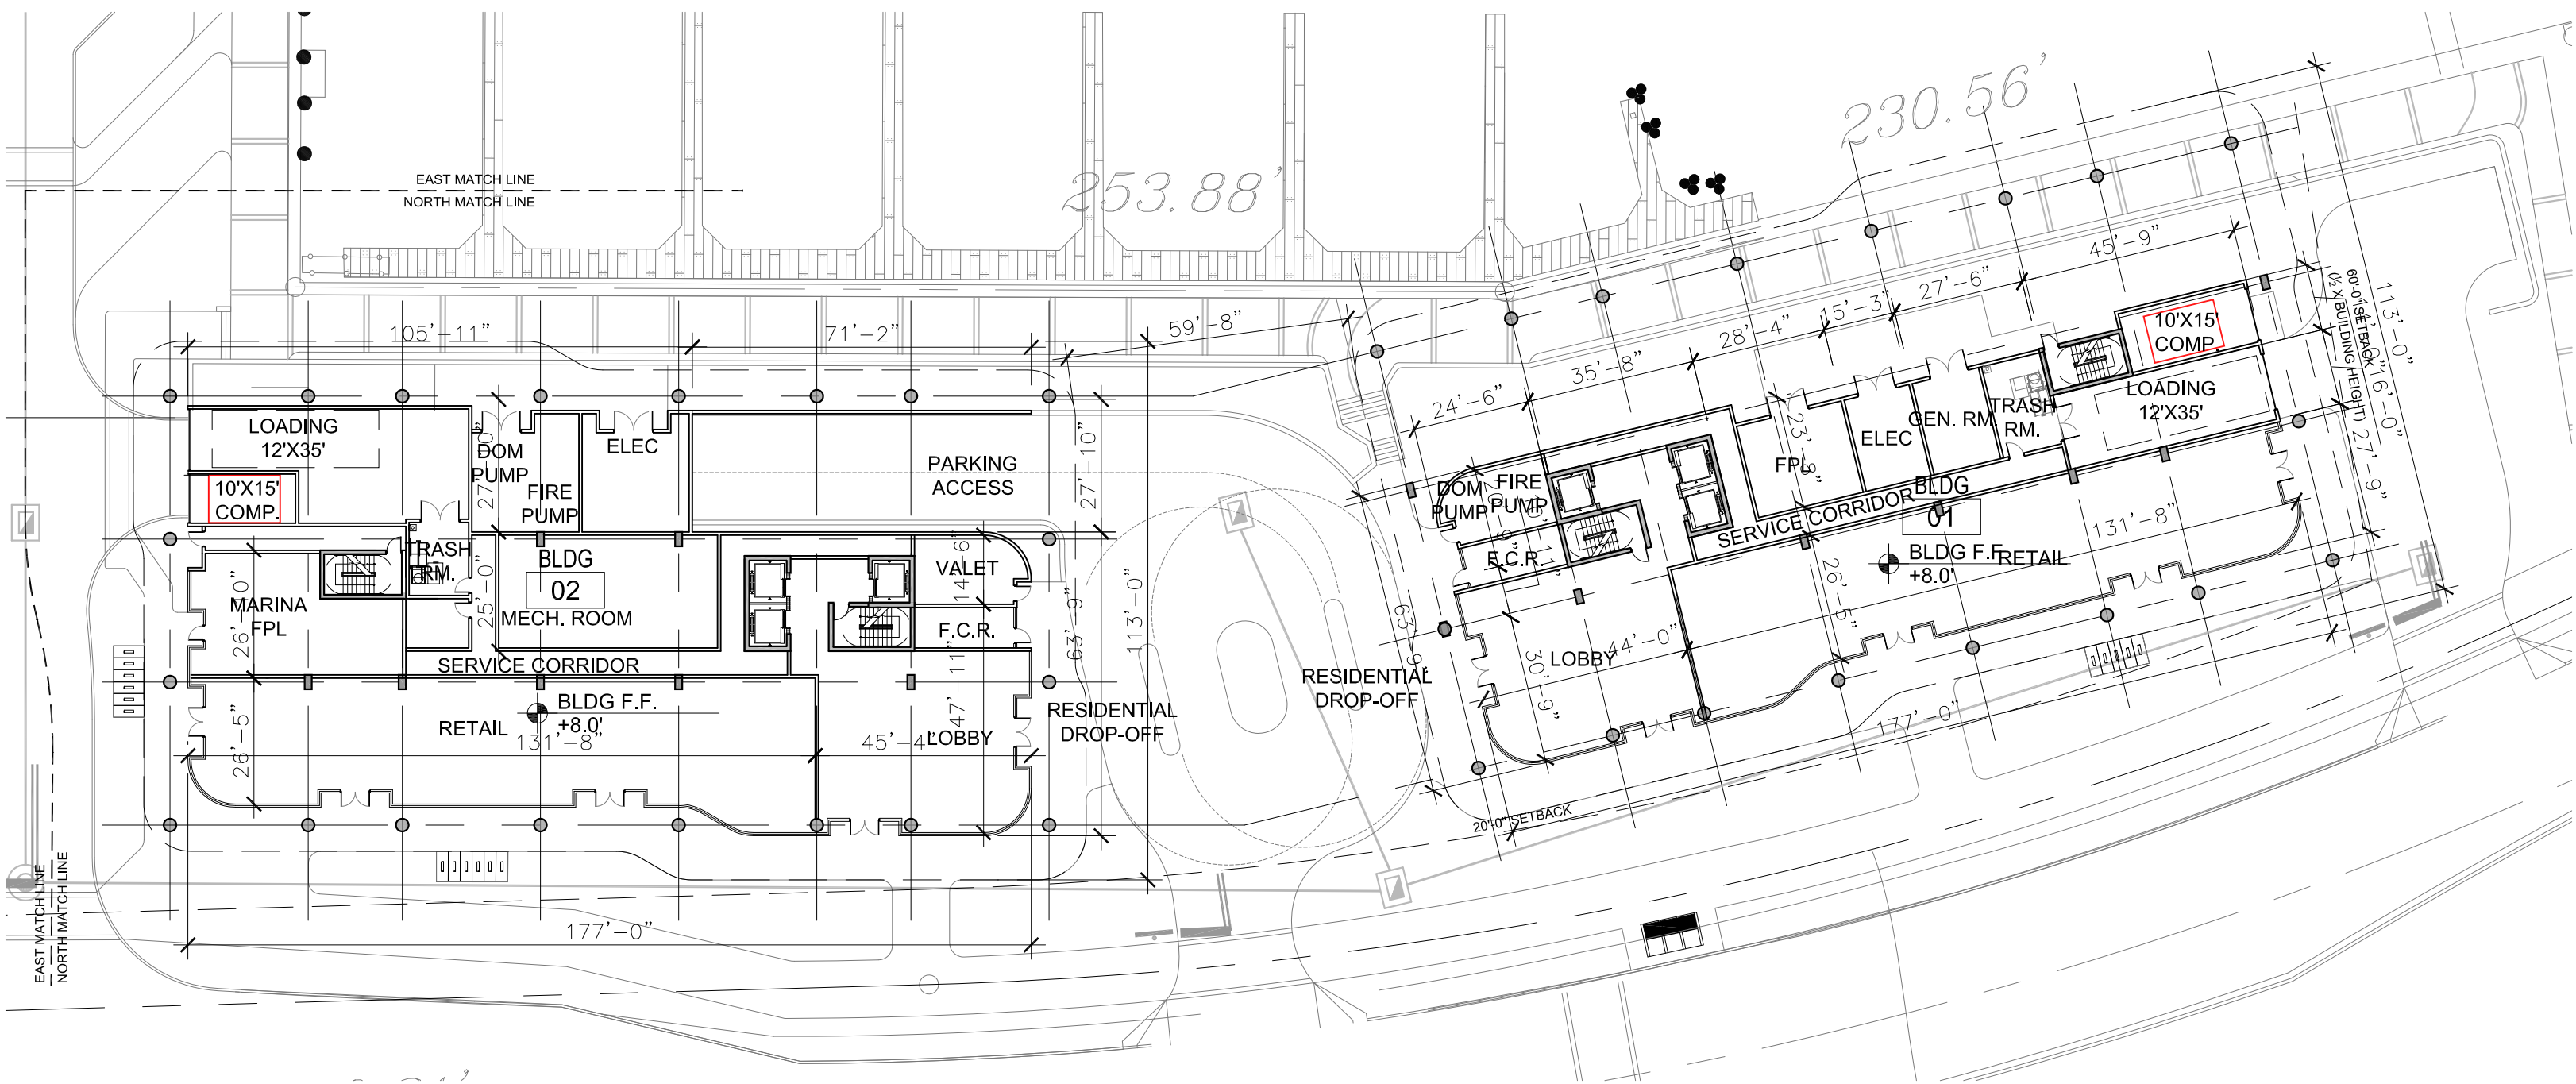

1 ENLARGED LEVEL 1 FLOOR PLAN NORTH
Scale: 1/32" = 1'-0"

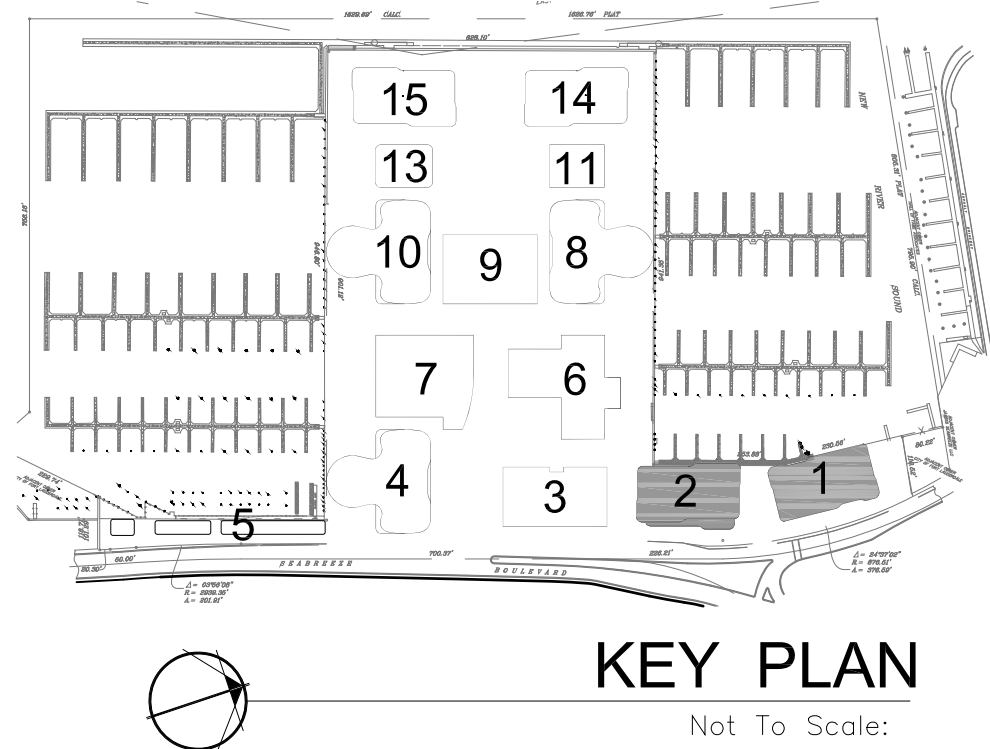

KEY PLAN
Not To Scale:


1657

ALL DRAWINGS AND WRITTEN MATERIAL APPEARING HEREIN
CONSTITUTE THE ORIGINAL AND UNPUBLISHED WORK OF KOB
KARP AND MAY NOT BE REPRODUCED, COPIED, OR INCORPORATED
WITHOUT THE EXPRESS WRITTEN CONSENT OF KOB KARP
ARCHITECTURE & INTERIOR DESIGN, INC. (KAI) 01/2017

BAHIA MAR
801 SEABREEZE BLVD.
FORT LAUDERDALE, FL 33316


LANDSCAPE
ARCHITECT

EDSA, Inc.
1512 E Broward Blvd. #110
Fort Lauderdale, Florida 33301
Tel: 954.524.3330

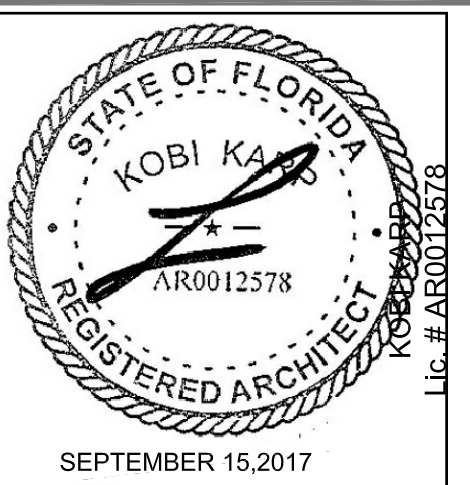

ARCHITECTURE
INTERIOR DESIGN
PLANNING


AIA ASID NCARB
2915 Biscayne Boulevard
Miami, Florida 33137
O: 305.573.1818
F: 305.573.3766
WWW.KOBKARP.COM
Lic. # AR0012578

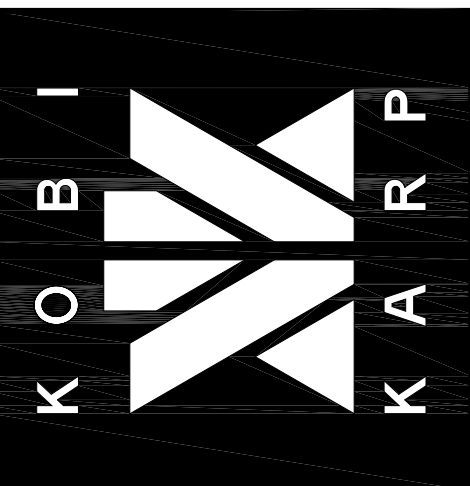


DRAWN BY: MC / AR / JPR / AM
CHECKED BY: AR
DATE: 09/15/2017

ENLARGED
LEVEL 3, 4, & 5
FLOOR PLAN
NORTH


A3.42

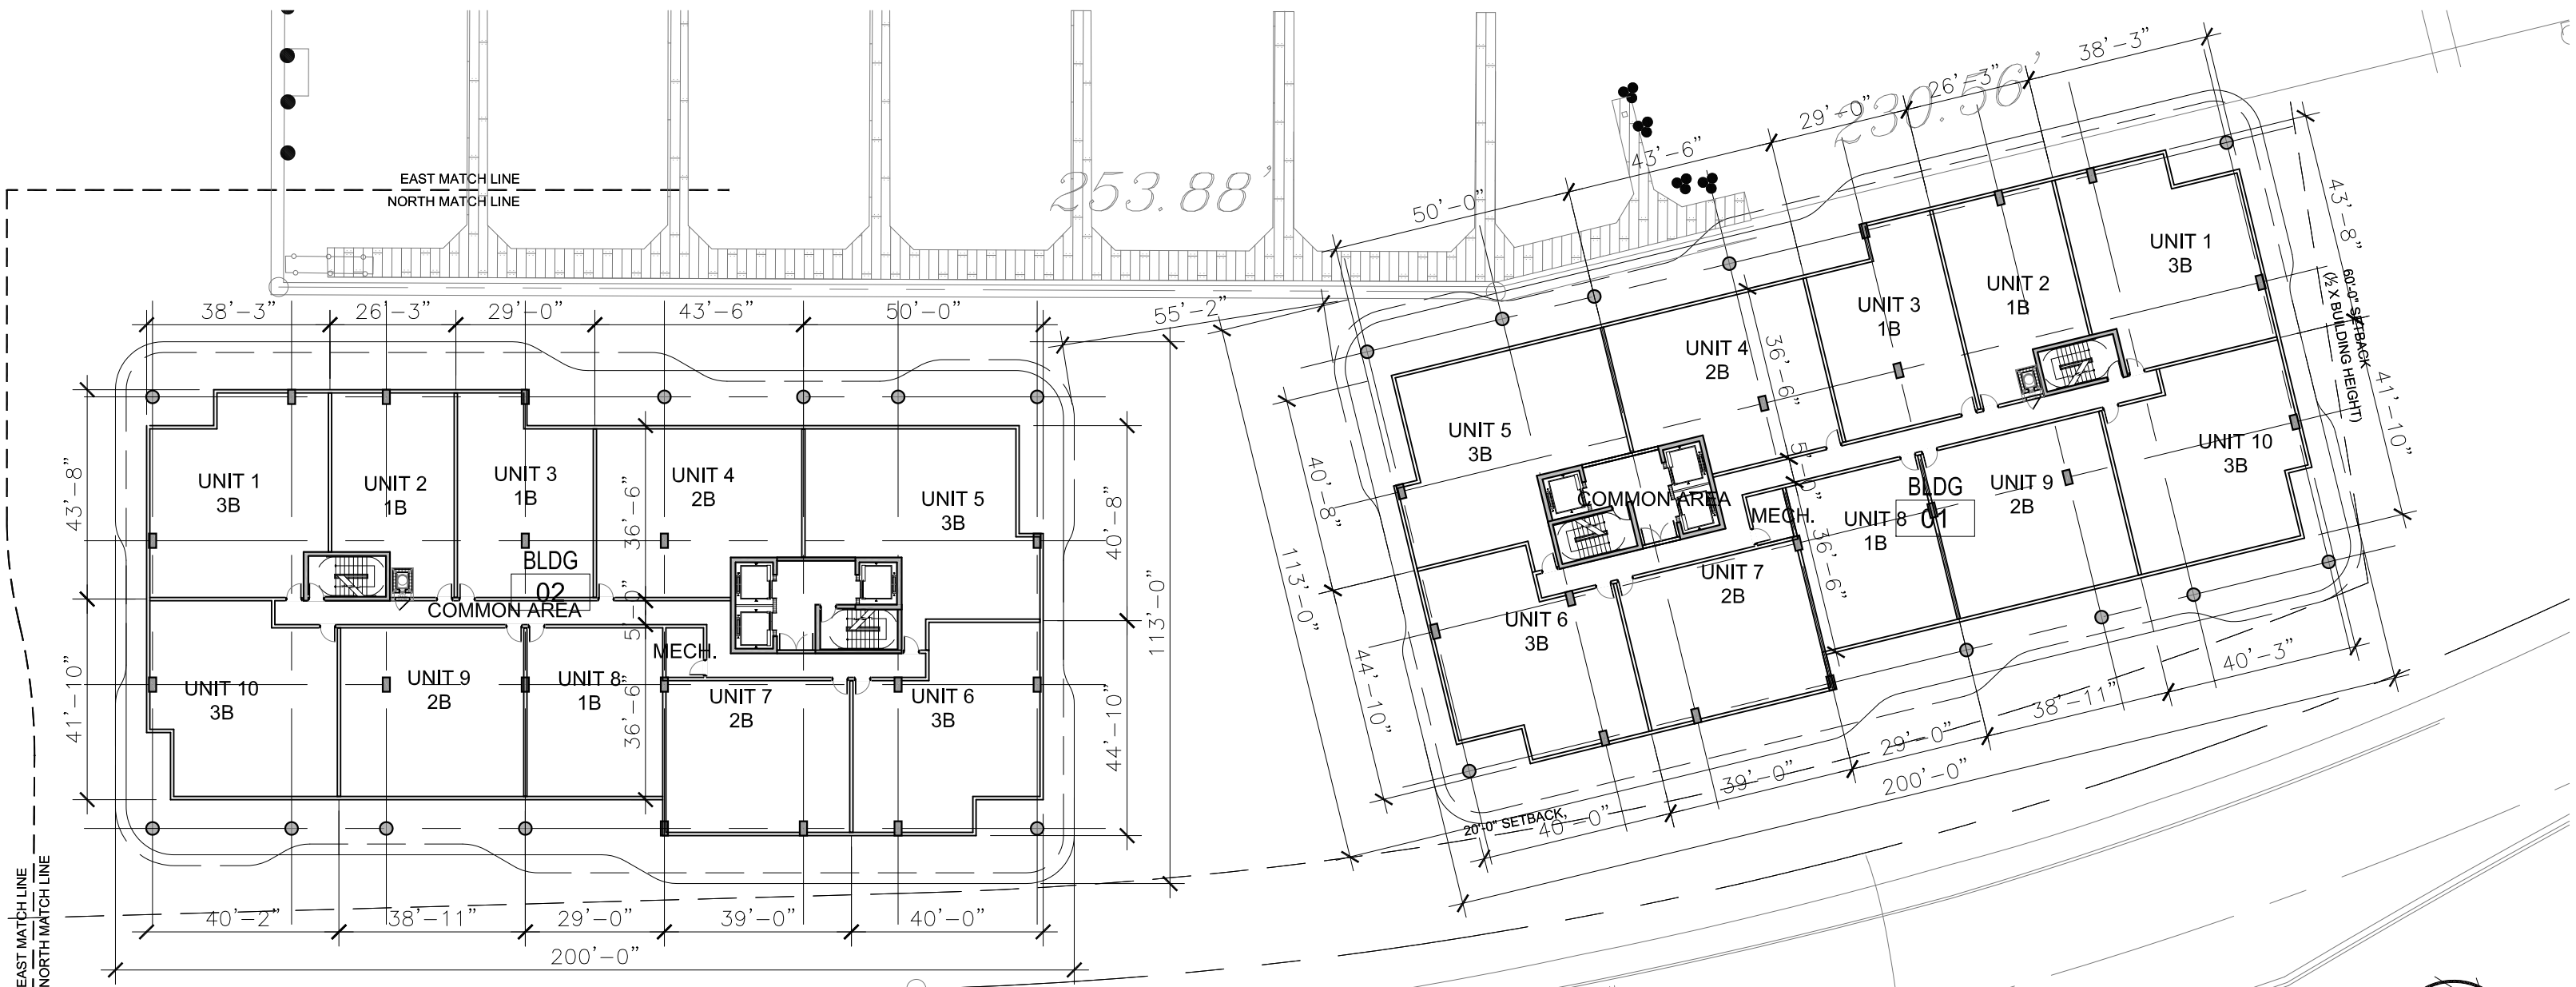


3 ENLARGED LEVEL 5 FLOOR PLAN NORTH
Scale: 1/32" = 1'-0"

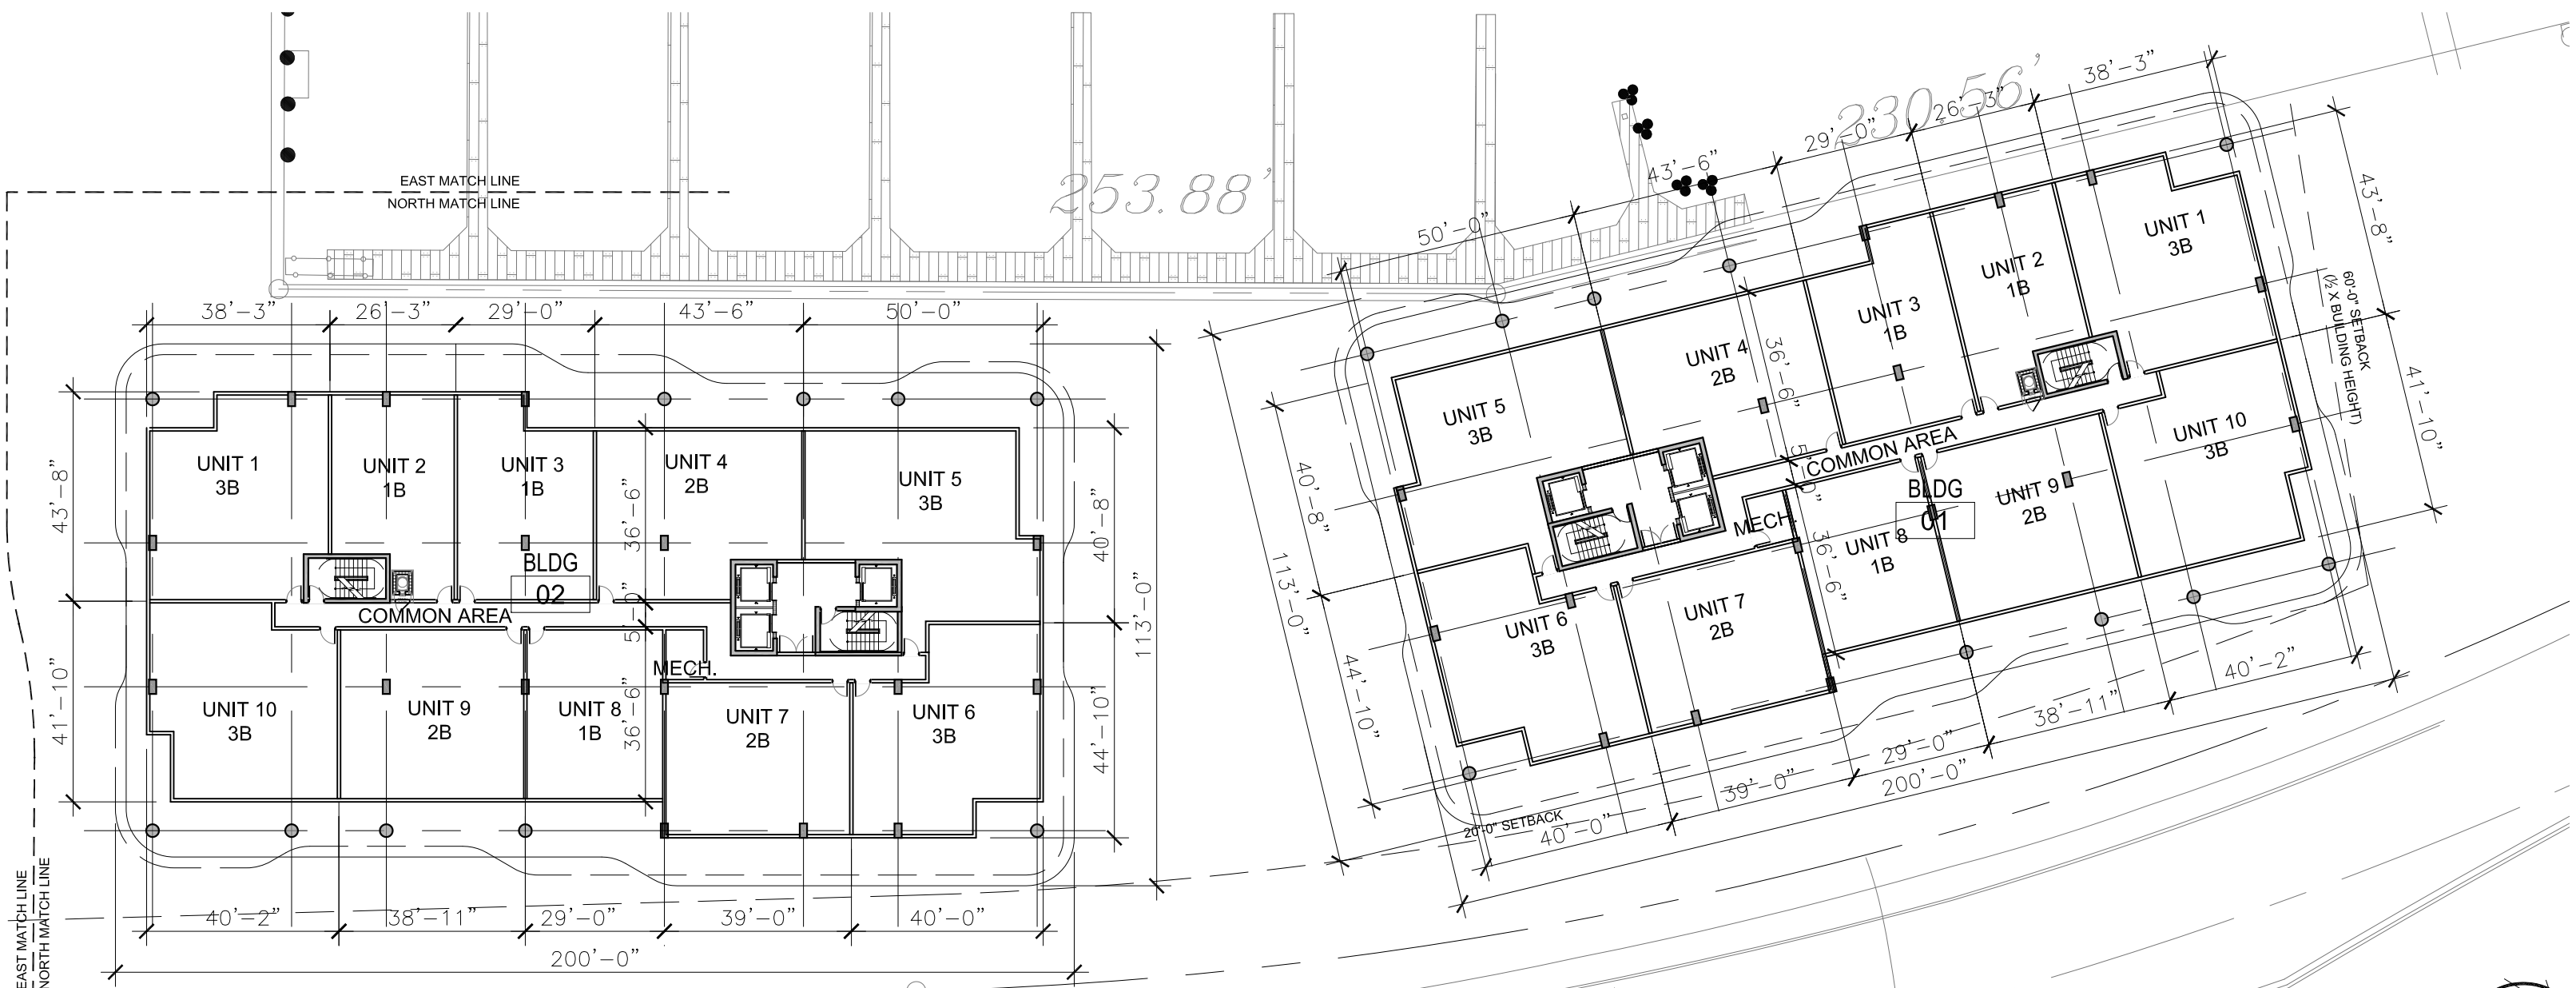

2 ENLARGED LEVEL 4 FLOOR PLAN NORTH
Scale: 1/32" = 1'-0"

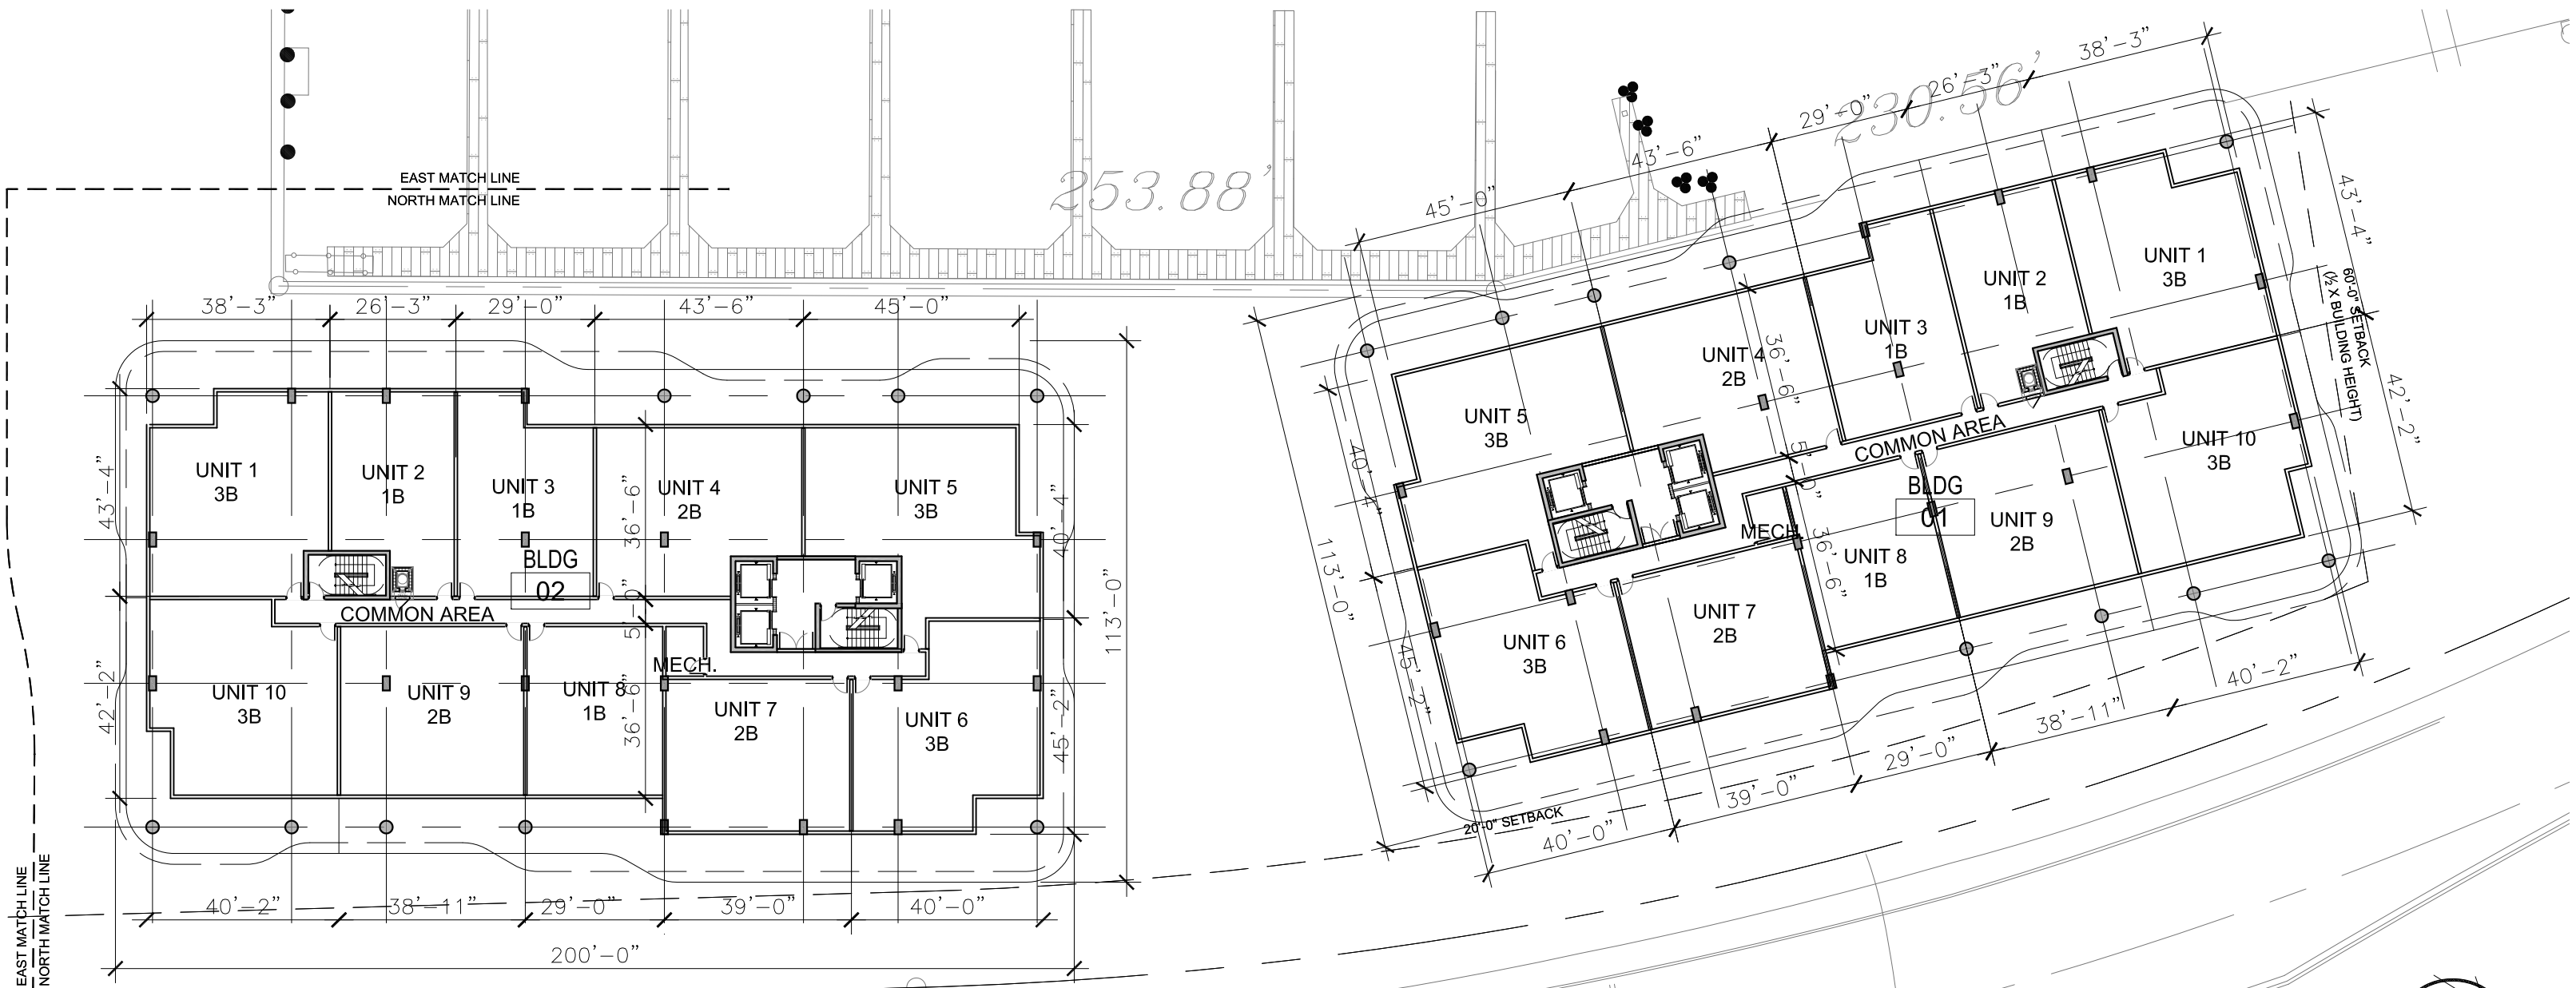

1 ENLARGED LEVEL 3 FLOOR PLAN NORTH
Scale: 1/32" = 1'-0"

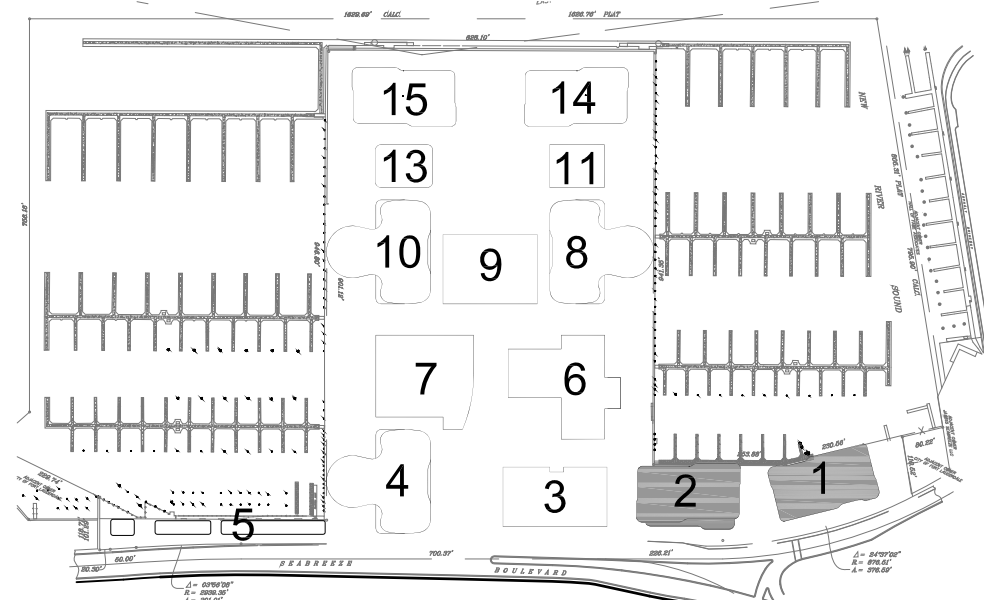

KEY PLAN

Not To Scale:


1657

ALL DRAWINGS AND WRITTEN MATERIAL APPEARING HEREIN
CONSTITUTE THE ORIGINAL AND UNPUBLISHED WORK OF KOB
KARP, INC. AND MAY NOT BE REPRODUCED, COPIED, OR
WITHOUT THE EXPRESS WRITTEN CONSENT OF KOB KARP
ARCHITECTURE & INTERIOR DESIGN, INC. (AIA, AIA 01/2017)

BAHIA MAR
801 SEABREEZE BLVD.
FORT LAUDERDALE, FL 33316


LANDSCAPE
ARCHITECT

EDSA, Inc.
1512 E Broward Blvd. #110
Fort Lauderdale, Florida 33301
Tel: 954.524.3330

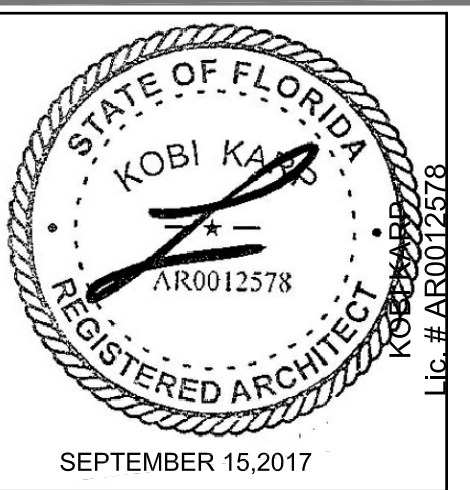

ARCHITECTURE
INTERIOR DESIGN
PLANNING


AIA ASID NCARB
2915 Biscayne Boulevard
Miami, Florida 33137
O: 305.573.1818
F: 305.573.3766
WWW.KOBKARP.COM
Lic. # AR0012578

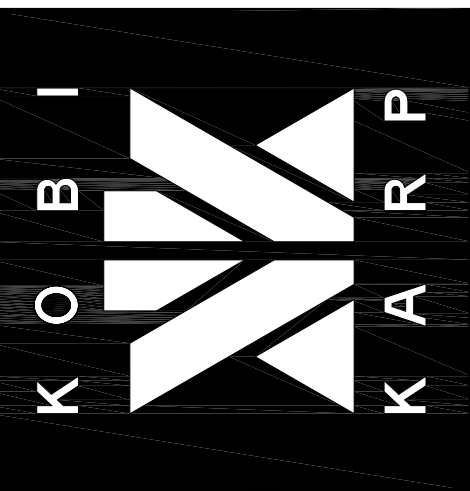

DRAWN BY: MC / AR / JPR / AM
CHECKED BY: AR
DATE: 09/15/2017


ENLARGED
LEVEL 6-7, 8,
9- 10 FLOOR
PLAN NORTH

A3.43

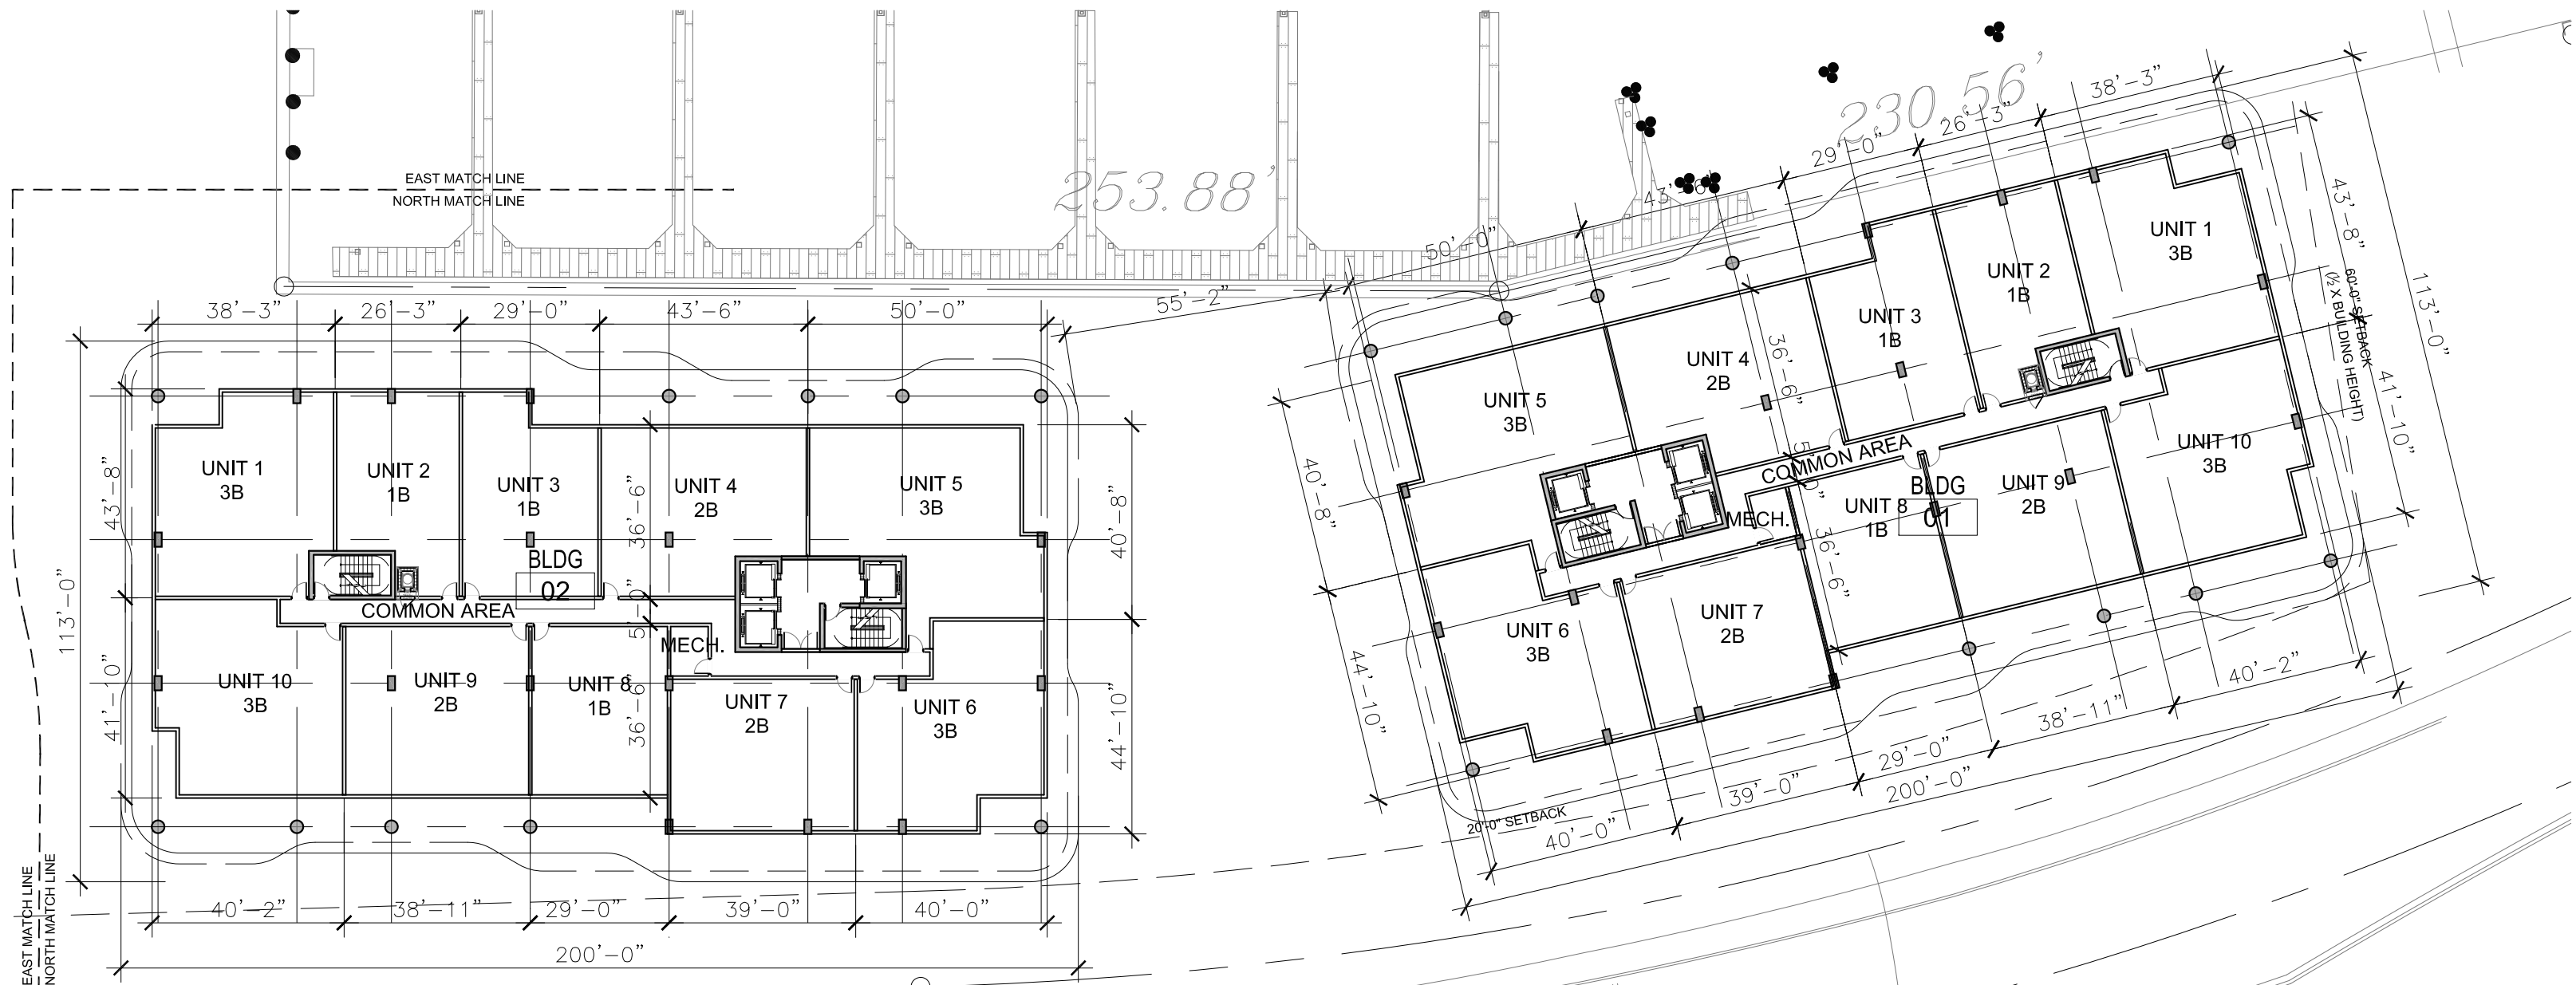


3 ENLARGED LEVEL 9-10 FLOOR PLAN NORTH

Scale: 1/32" = 1'-0"

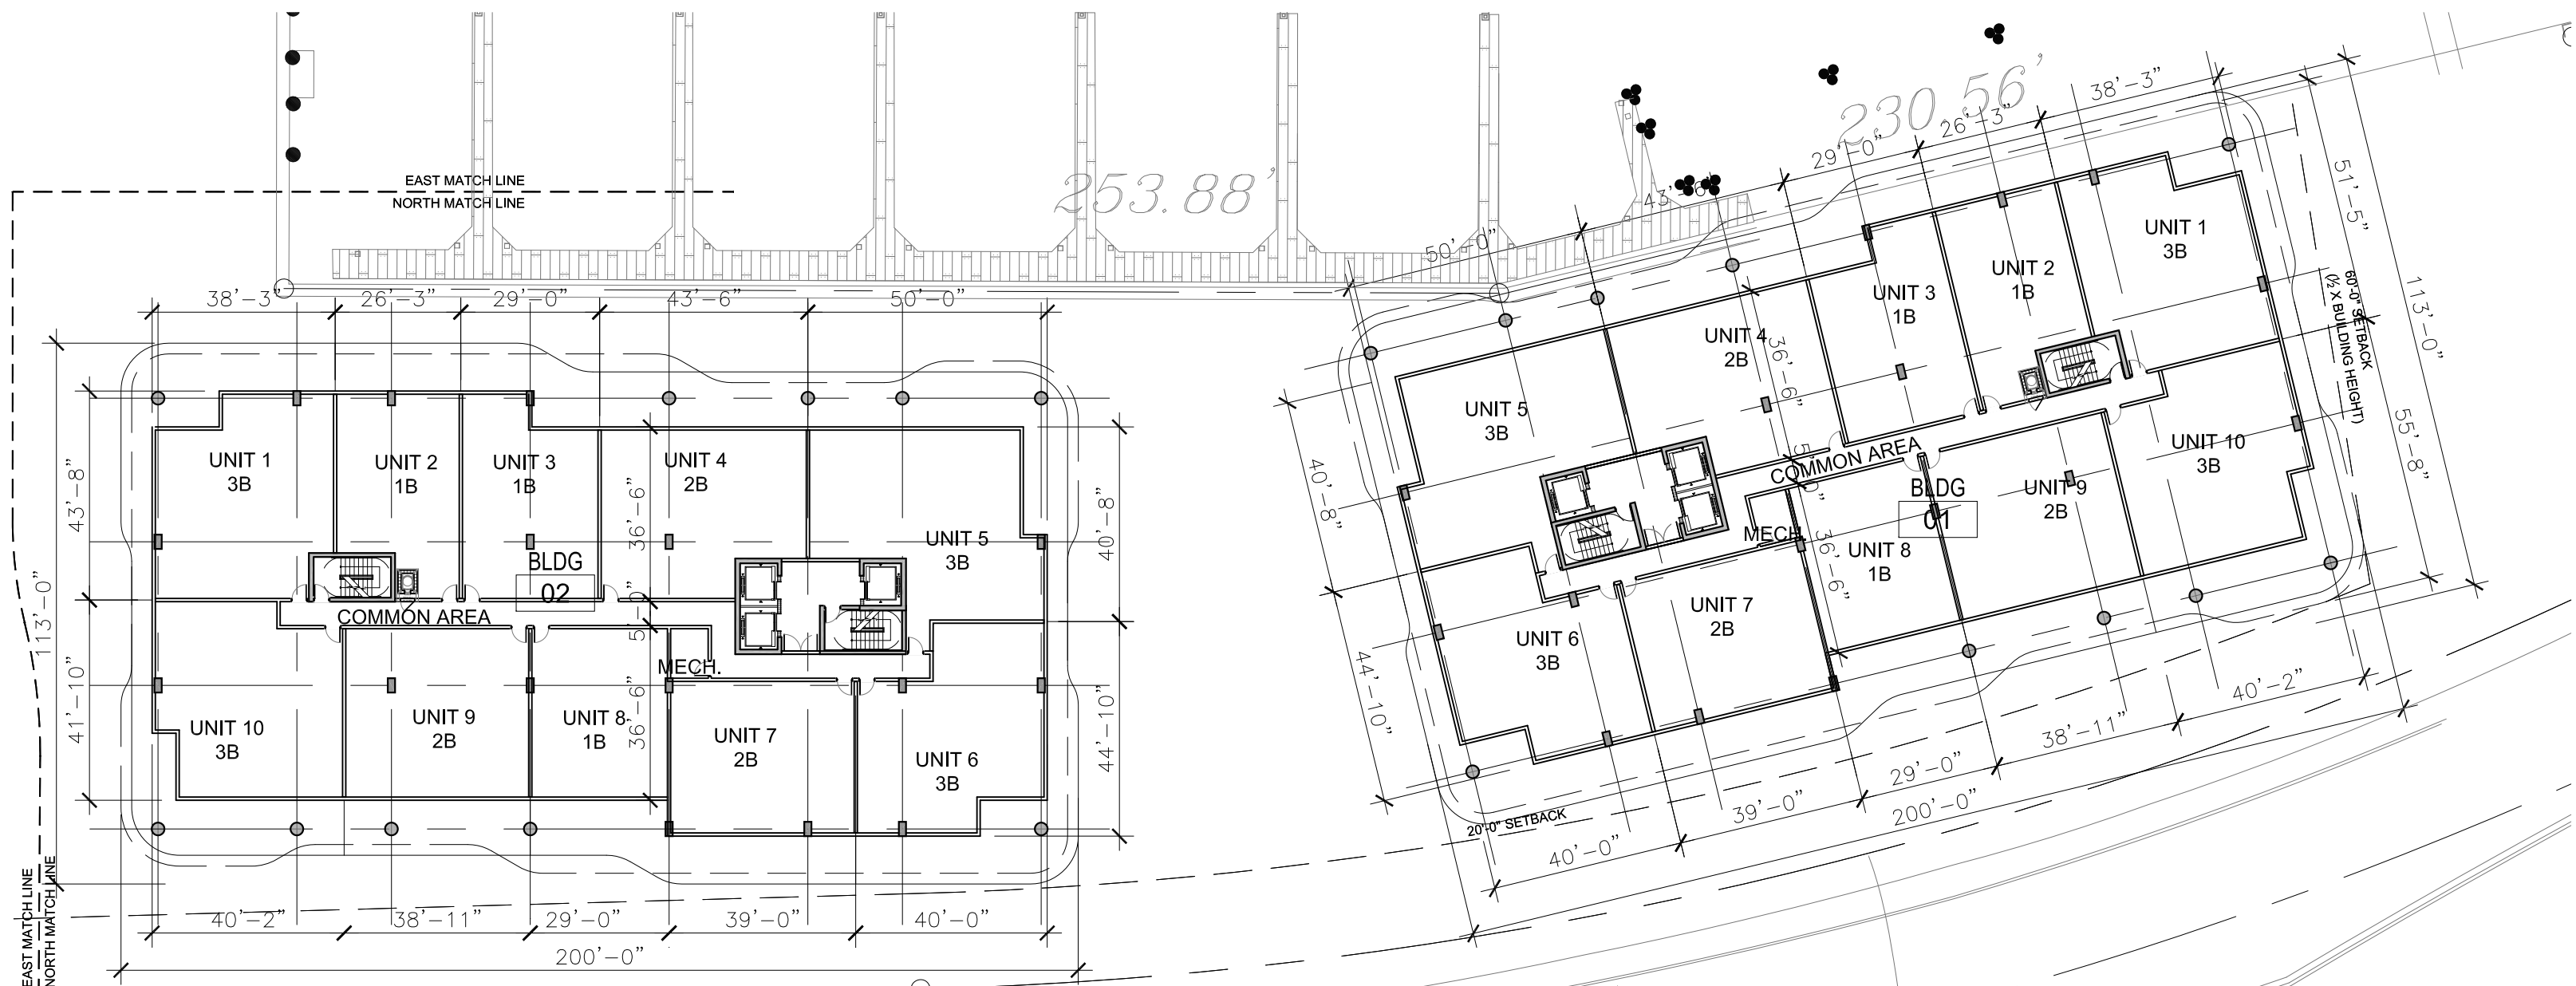


2 ENLARGED LEVEL 8 FLOOR PLAN NORTH

Scale: 1/32" = 1'-0"

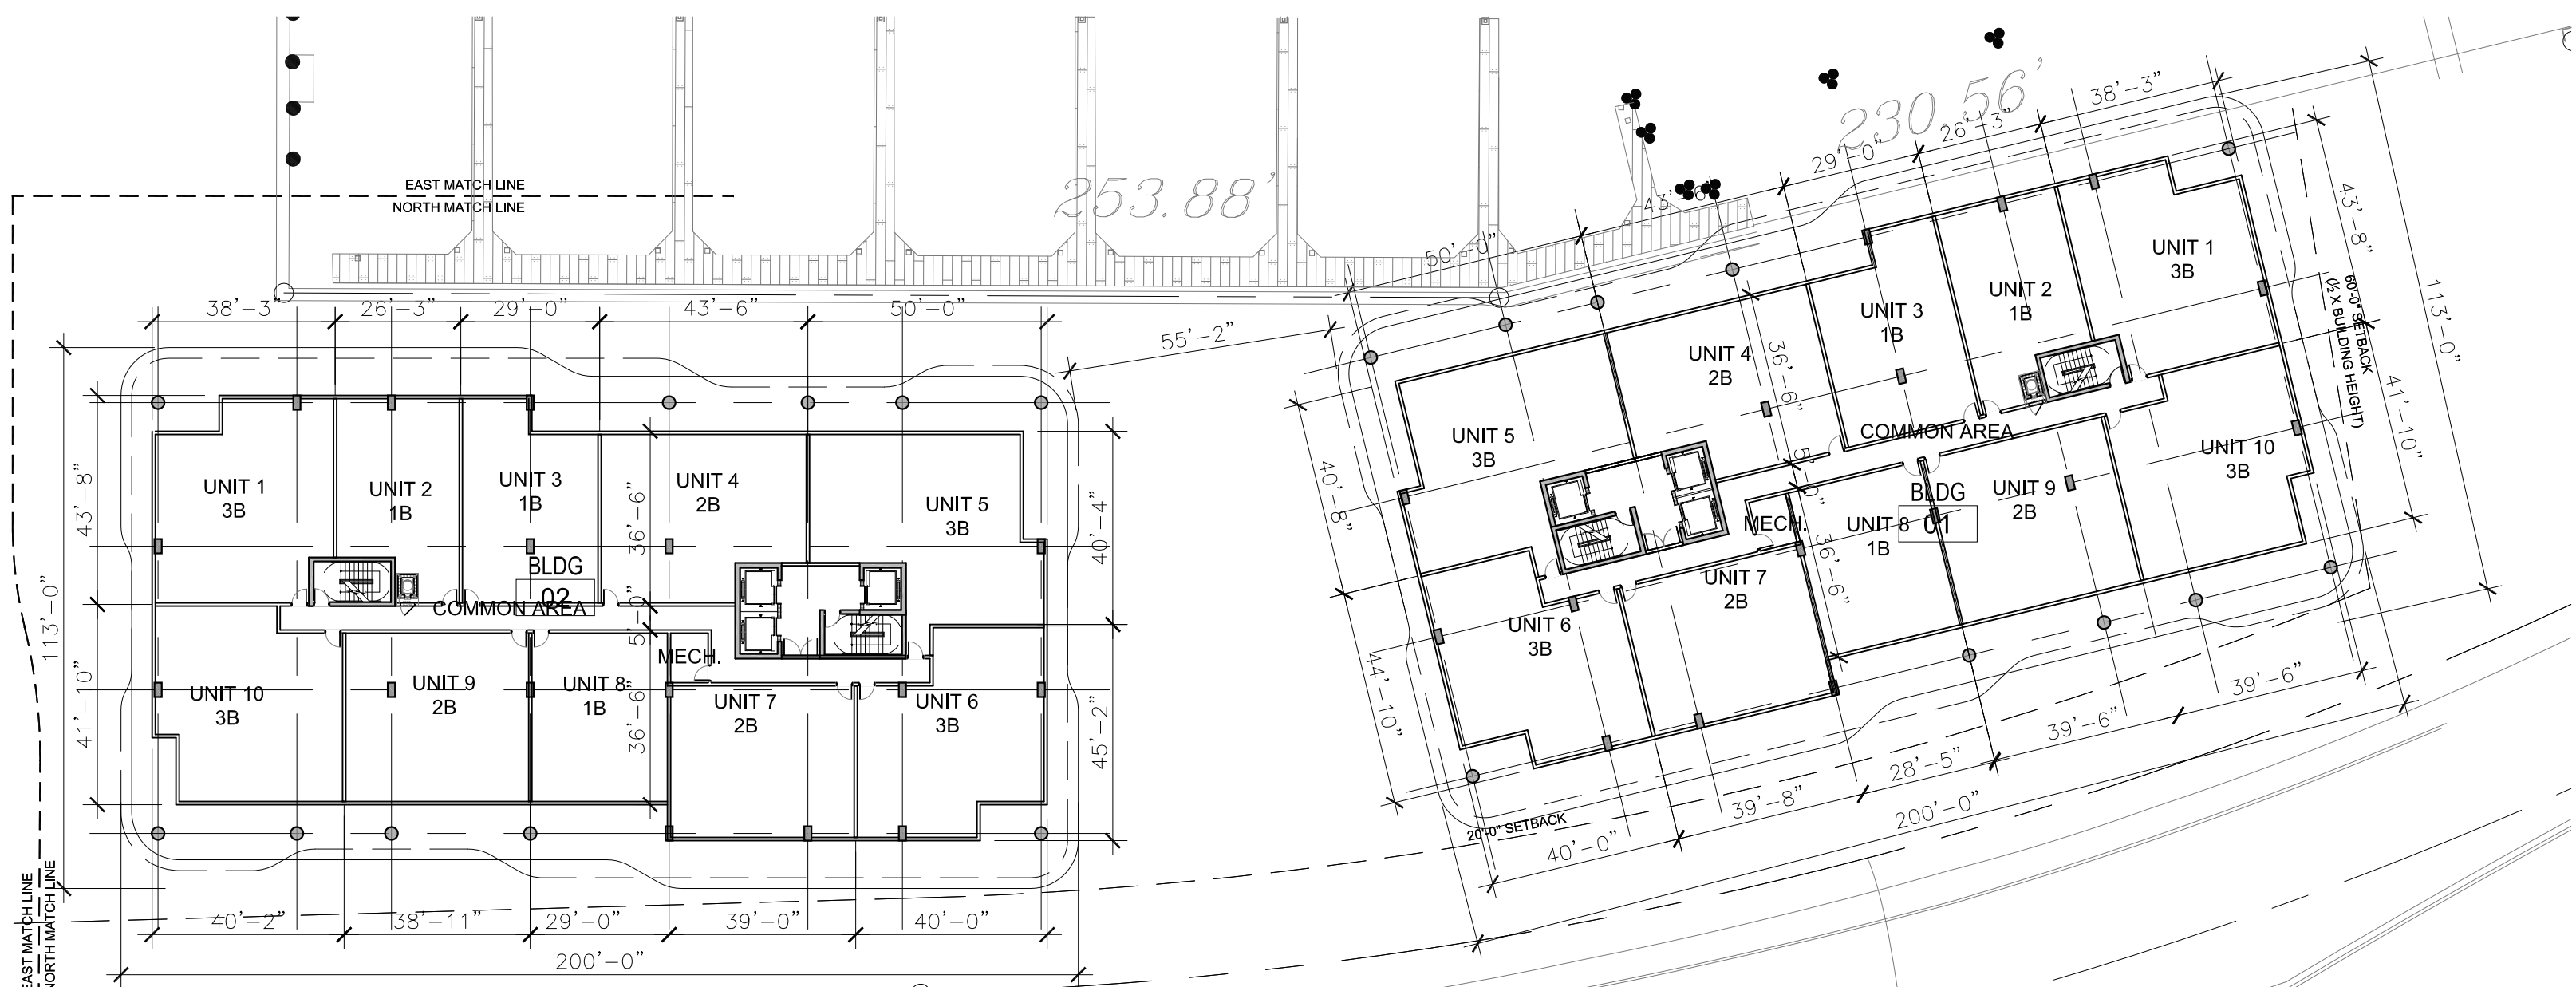

1 ENLARGED LEVEL 6-7 FLOOR PLAN NORTH

Scale: 1/32" = 1'-0"

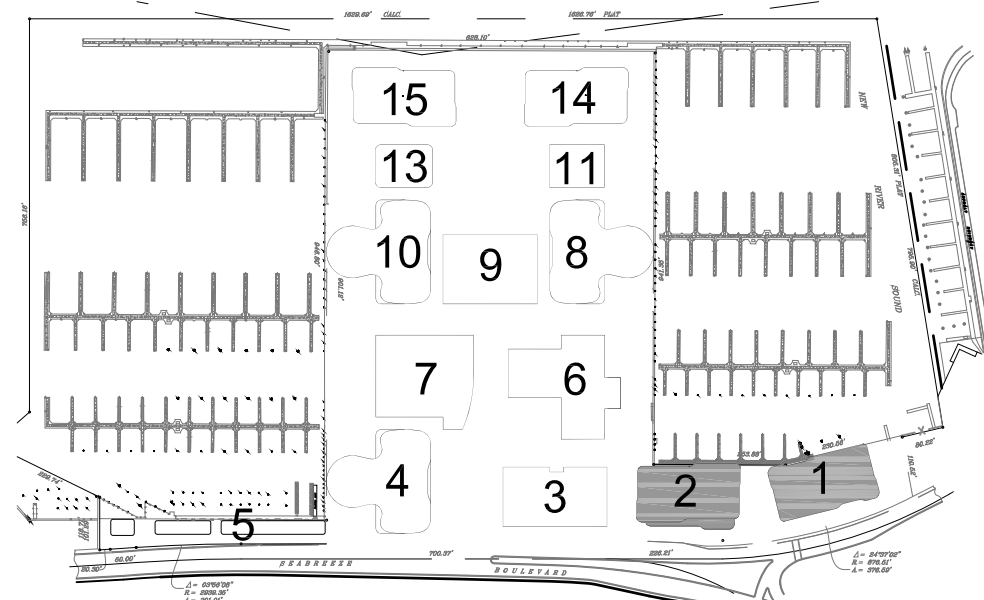

KEY PLAN

Not To Scale:


1657

ALL DRAWINGS AND WRITTEN MATERIAL APPEARING HEREIN
CONSTITUTE THE ORIGINAL AND UNPUBLISHED WORK OF KOBI
KARP AIA, AND MAY NOT BE DUPLICATED, USED, OR DISCLOSED
WITHOUT THE EXPRESS WRITTEN CONSENT OF KOBI KARP
ARCHITECTURE & INTERIOR DESIGN, INC. AIA. (c) 2017

BAHIA MAR
801 SEABREEZE BLVD.
FORT LAUDERDALE, FL 33316

LANDSCAPE
ARCHITECT


EDSA, Inc.
1512 E Broward Blvd. #110
Fort Lauderdale, Florida 33301
Tel: 954.524.3330

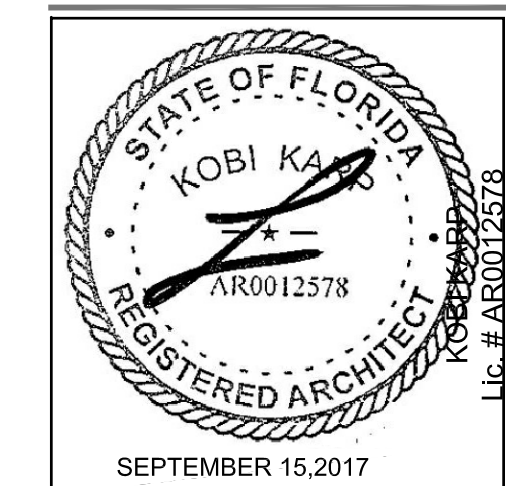

ARCHITECTURE
INTERIOR DESIGN
PLANNING

IA	ASID	NCARB
1	2	3
4	5	6
7	8	9
364	365	366
367		

F: 305.573.3766
WWW.KOBIKARP.COM

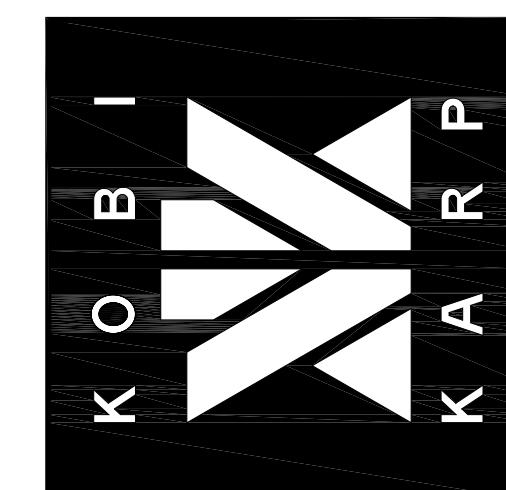

DRAWN BY: MC / AB / JPR / AM

CHECKED BY: _____ AR _____

DATE: 09/15/2017

ENLARGED
LEVEL 11,
ROOF & MECH.
ROOF PLANS
NORTH

A3.44